
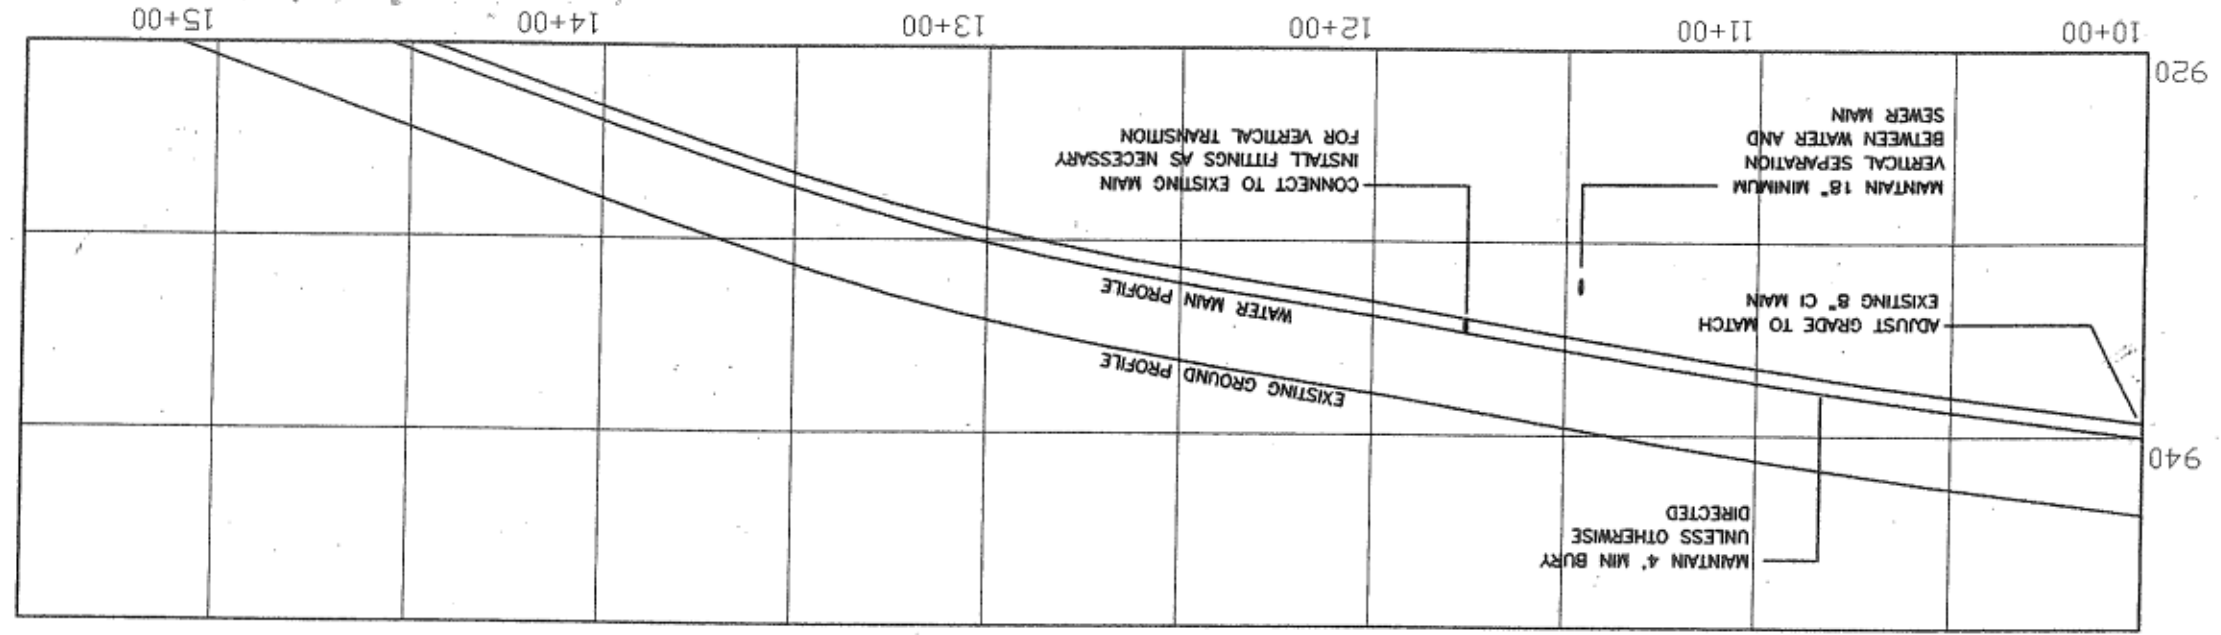


WATER MAIN SCHEDULE


NO. LINE	STATION	OFFSET	NOTES	NO. LINE	STATION	OFFSET	NOTES
①	10+00		CONNECT TO EXISTING MAIN	③	13+74	RT	REMOVE EXISTING TEE
			8" x 8" FL TEE				REMOVE EXISTING VALVES (3)
			8" FL x MJ GV (S)				CONNECT TO EXISTING MAIN (E)
			8" FL x MJ GV (N)				CAP ABANDONED MAIN (N)
			8" FL x MJ GV (E)				CAP ABANDONED MAIN (S)
			10 LF 8" PIPE (E)				

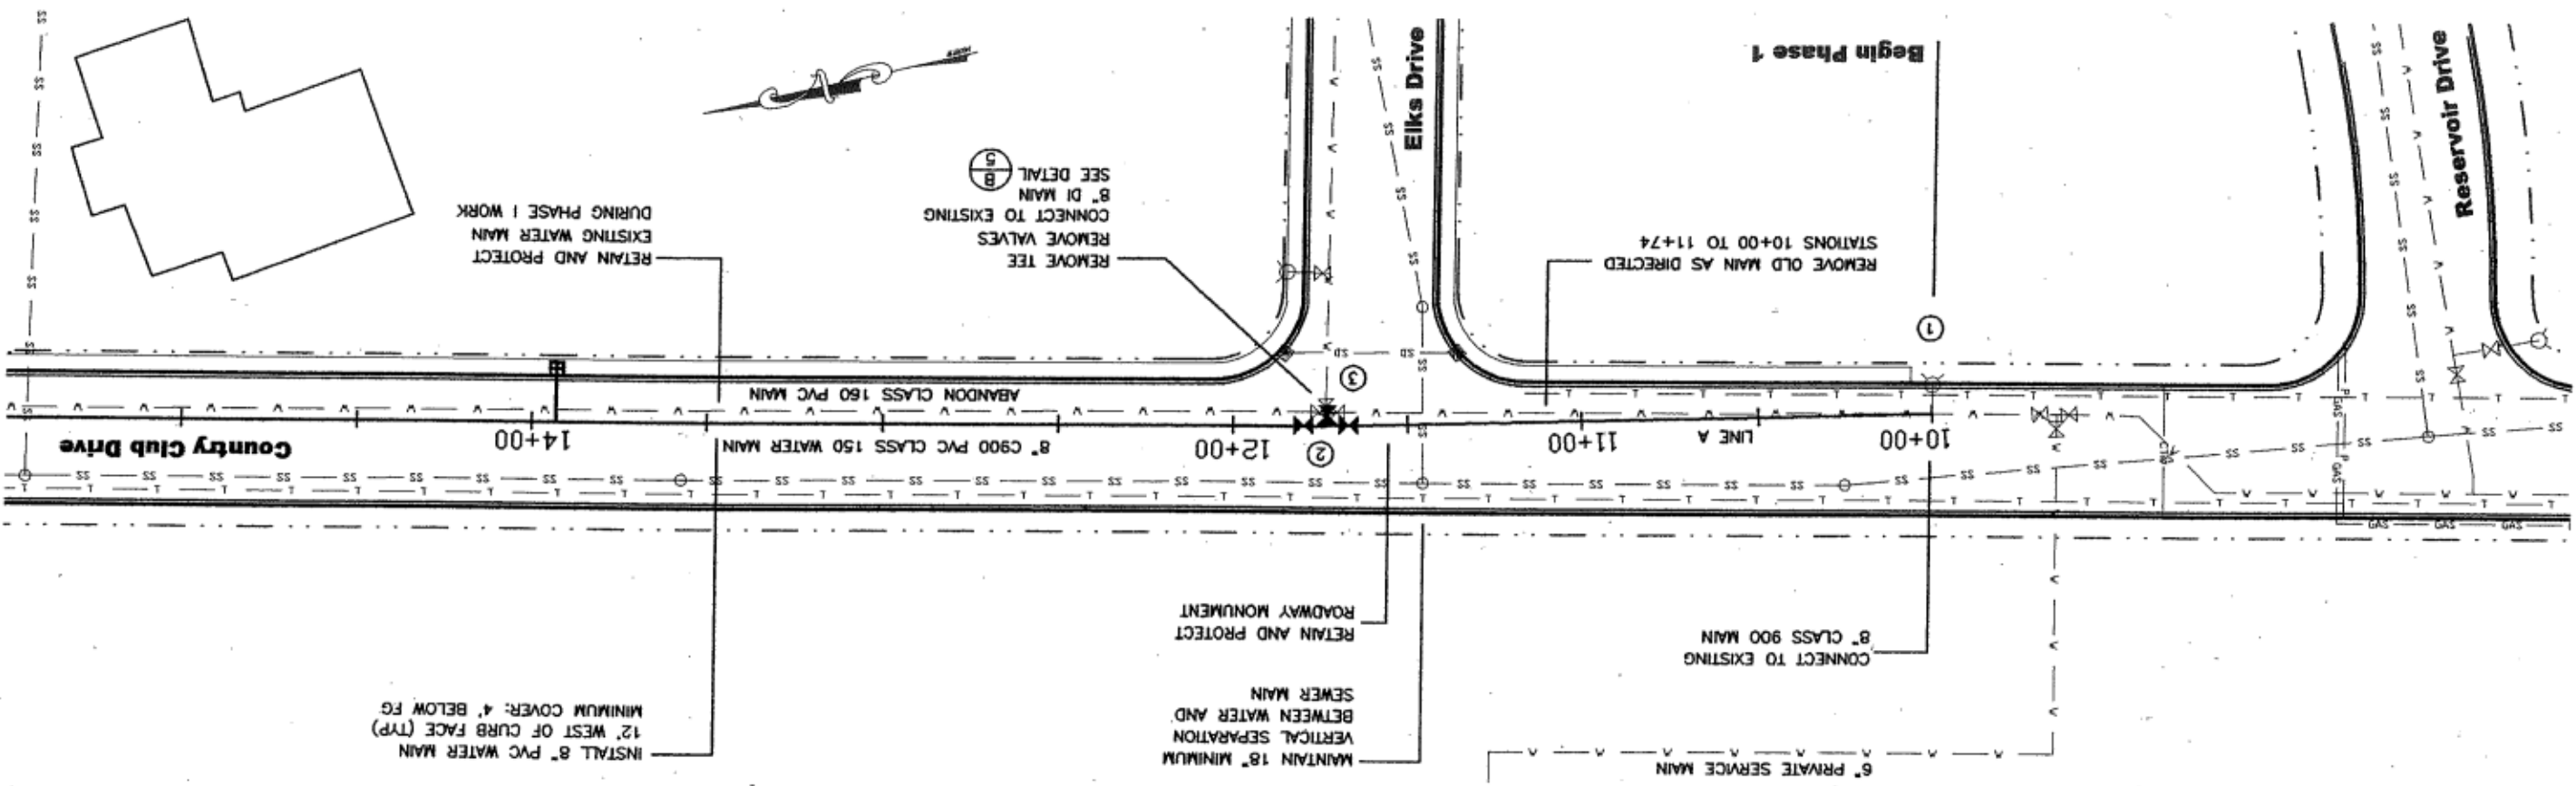

NO.	DATE	REVISION	DESCRIPTION

PLAN AND PROFILE
 ADD ALTERNATE D
 Country Club Drive
 Water Main Replacement

CITY OF LEWISTON
 PUBLIC WORKS DEPARTMENT
 ENGINEERING SERVICES
 134 1st STREET LEWISTON, ID 83501
 (208) 746-9671 FAX (208) 746-9987

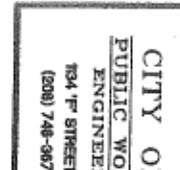

DESIGNED BY: S.M.
 DRAWN BY: S.M.
 CHECKED BY: J.W.
 DATE: May 2003
 DRAWING NO.: 04098.dwg
 SHEET 2 OF 7