





PLAN AND PROFILE  
 ADD ALTERNATE D  
 Country Club Drive

DESIGNED BY	S.M.
DRAWN BY	S.M.
CHECKED BY	L.W.

DATE	May 2009
SCALE	1" = 50'
DRAWING NO.	WaterMain.dwg

**WATER MAIN SCHEDULE**

NO.	LINE	STATION	OFFSET	NOTES
20	A	20+05		ENCASE PIPELINE - 100 LF
21	A	20+39	LT	REMOVE HYDRANT AND VALVE
22	A	22+20		8" 11 DEG MJ ELL
23	A	24+23		8" 22 DEG MJ ELL
24	A	24+42	RT	REMOVE EXISTING VALVE
25	A	24+60		8" 22 DEG MJ ELL
26	A	24+77		8" FL x MJ GV (S)
27	A	23+07		10' LT HYDRANT ASSEMBLY

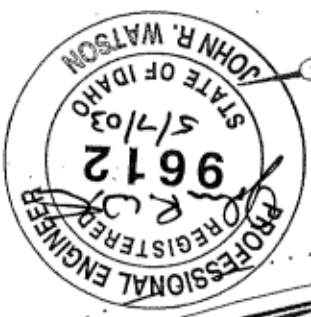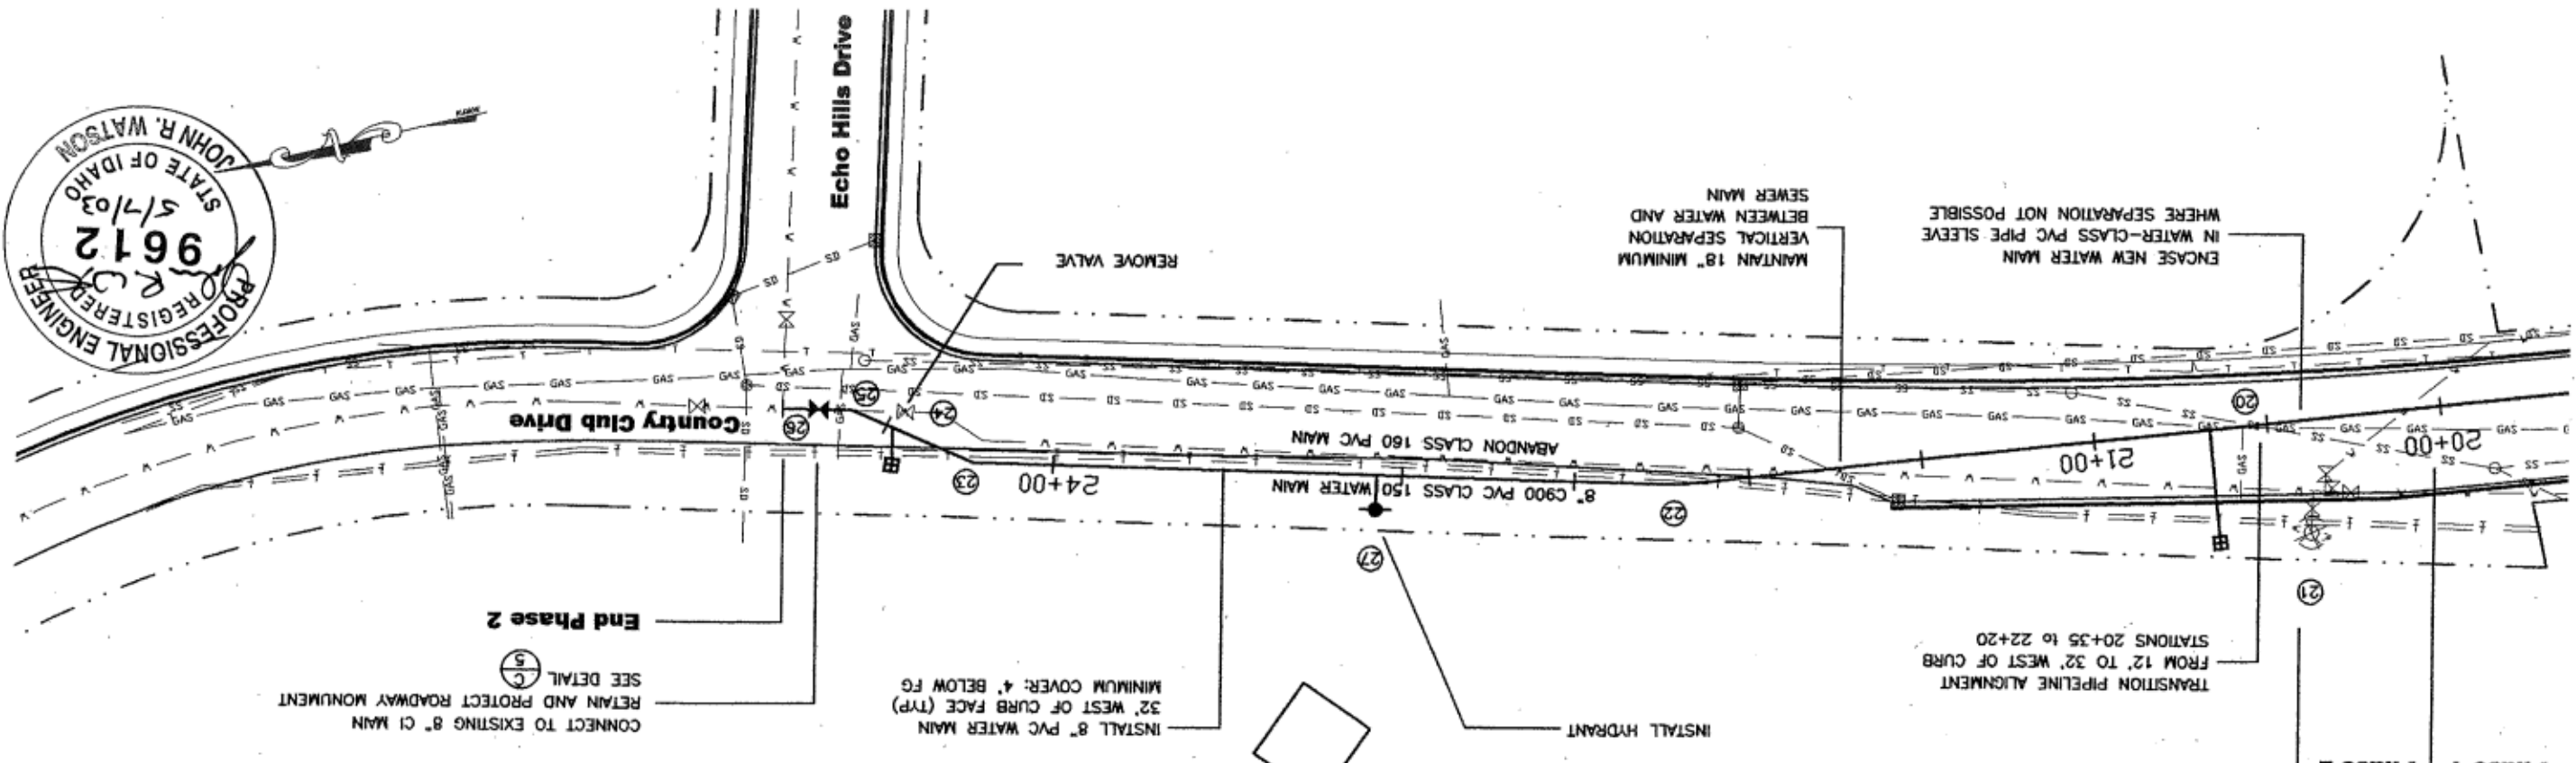

**WATER SERVICE NOTES**

LINE	LOCATION	SIDE	ADDRESS	ID #	APPROX LENGTH	NOTES
A	13+93	RT	3473 EIKS DR	NONE	15 LF	1" SERVICE
A	20+65	LT	3406 CC	5286	33 LF	1" SERVICE
A	24+50	LT	3434 CC	5288	12 LF	1" SERVICE

