
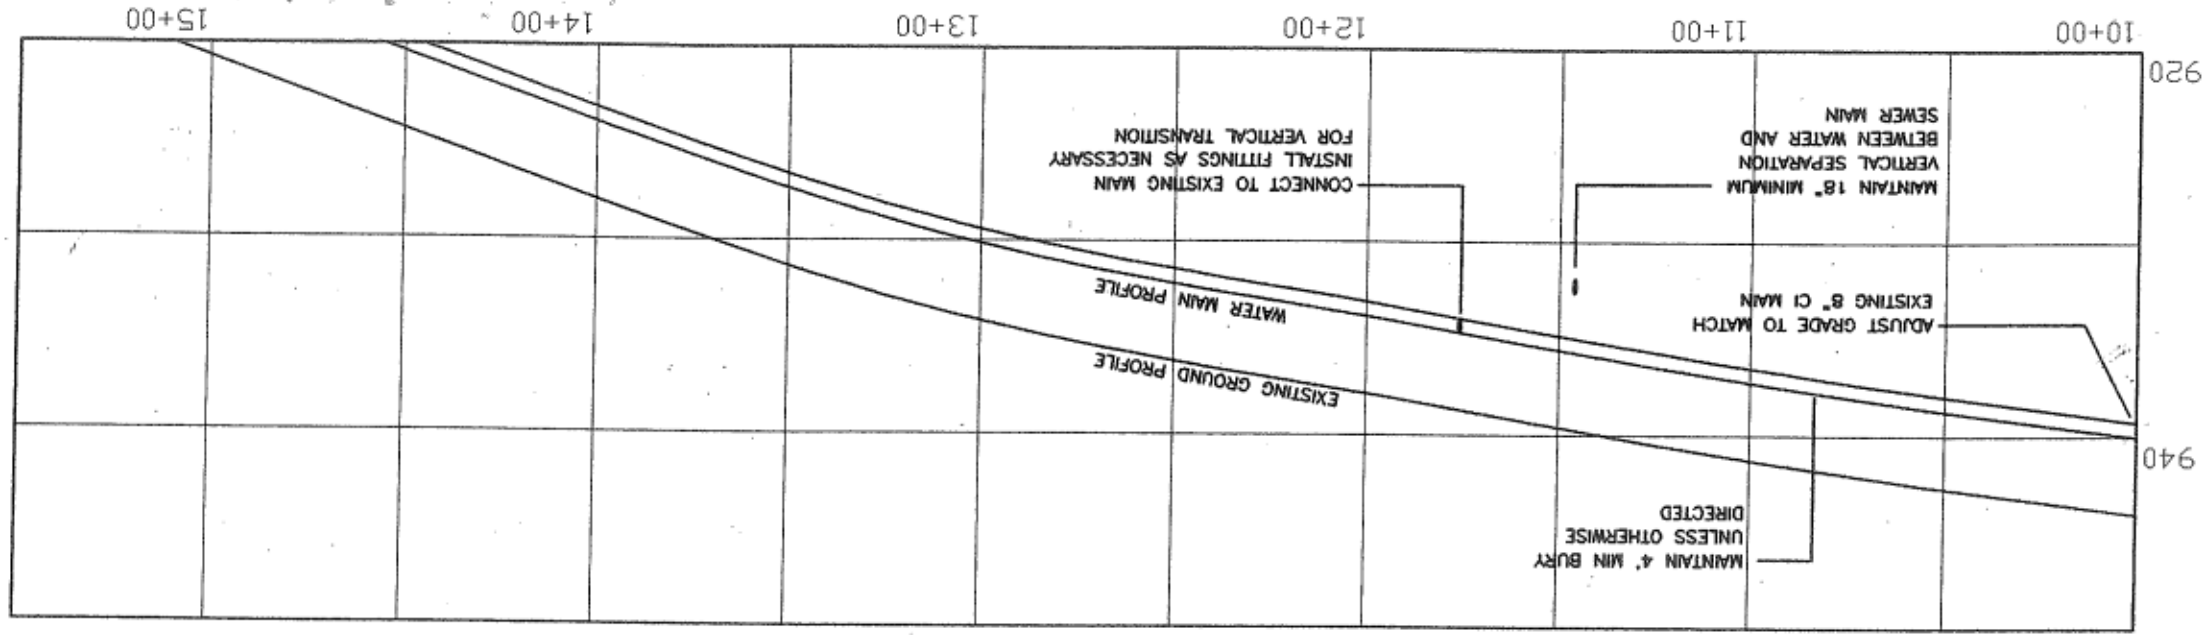


**WATER MAIN SCHEDULE**


NO. LINE	STATION	OFFSET	NOTES	NO. LINE	STATION	OFFSET	NOTES
(1)	10+00		CONNECT TO EXISTING MAIN	(3)	13+74	RT	REMOVE EXISTING TEE
			8" x 8" FL TEE				REMOVE EXISTING VALVES (3)
			8" FL x MJ GV (S)				CONNECT TO EXISTING MAIN (E)
			8" FL x MJ GV (N)				CAP ABANDONED MAIN (N)
			8" FL x MJ GV (E)				CAP ABANDONED MAIN (S)
			10 LF 8" PIPE (E)				

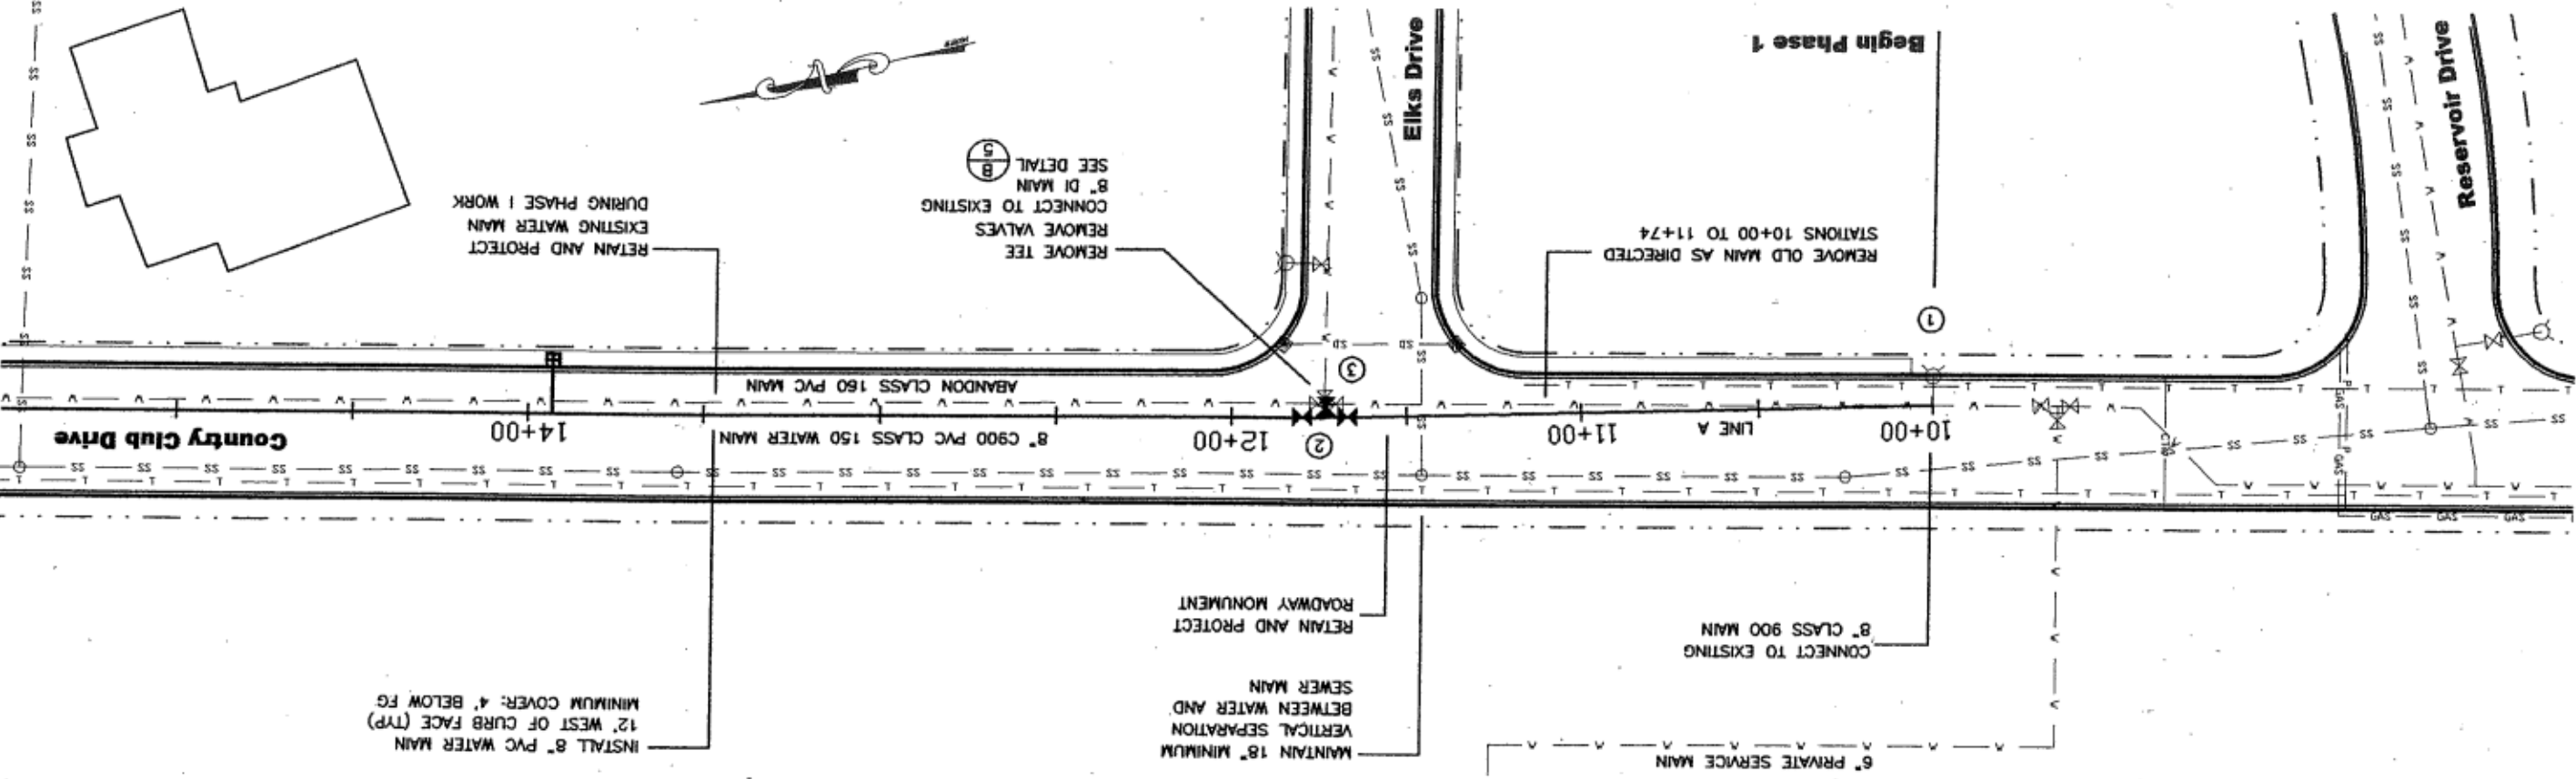

NO.	DATE	REVISION	BY

PLAN AND PROFILE  
 ADD ALTERNATE D  
 Country Club Drive  
 Water Main Replacement

CITY OF LEWISTON  
 PUBLIC WORKS DEPARTMENT  
 ENGINEERING SERVICES  
 134 1<sup>st</sup> STREET LEWISTON, ID 83501  
 (208) 746-9671 FAX (208) 746-9987

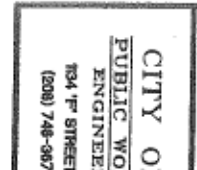

DESIGNED BY	SCALE	DATE
S.M.	1" = 50'	May 2003
CHECKED BY	DRAWING NO.	SHEET
J.W.	208-000	2 OF 7