


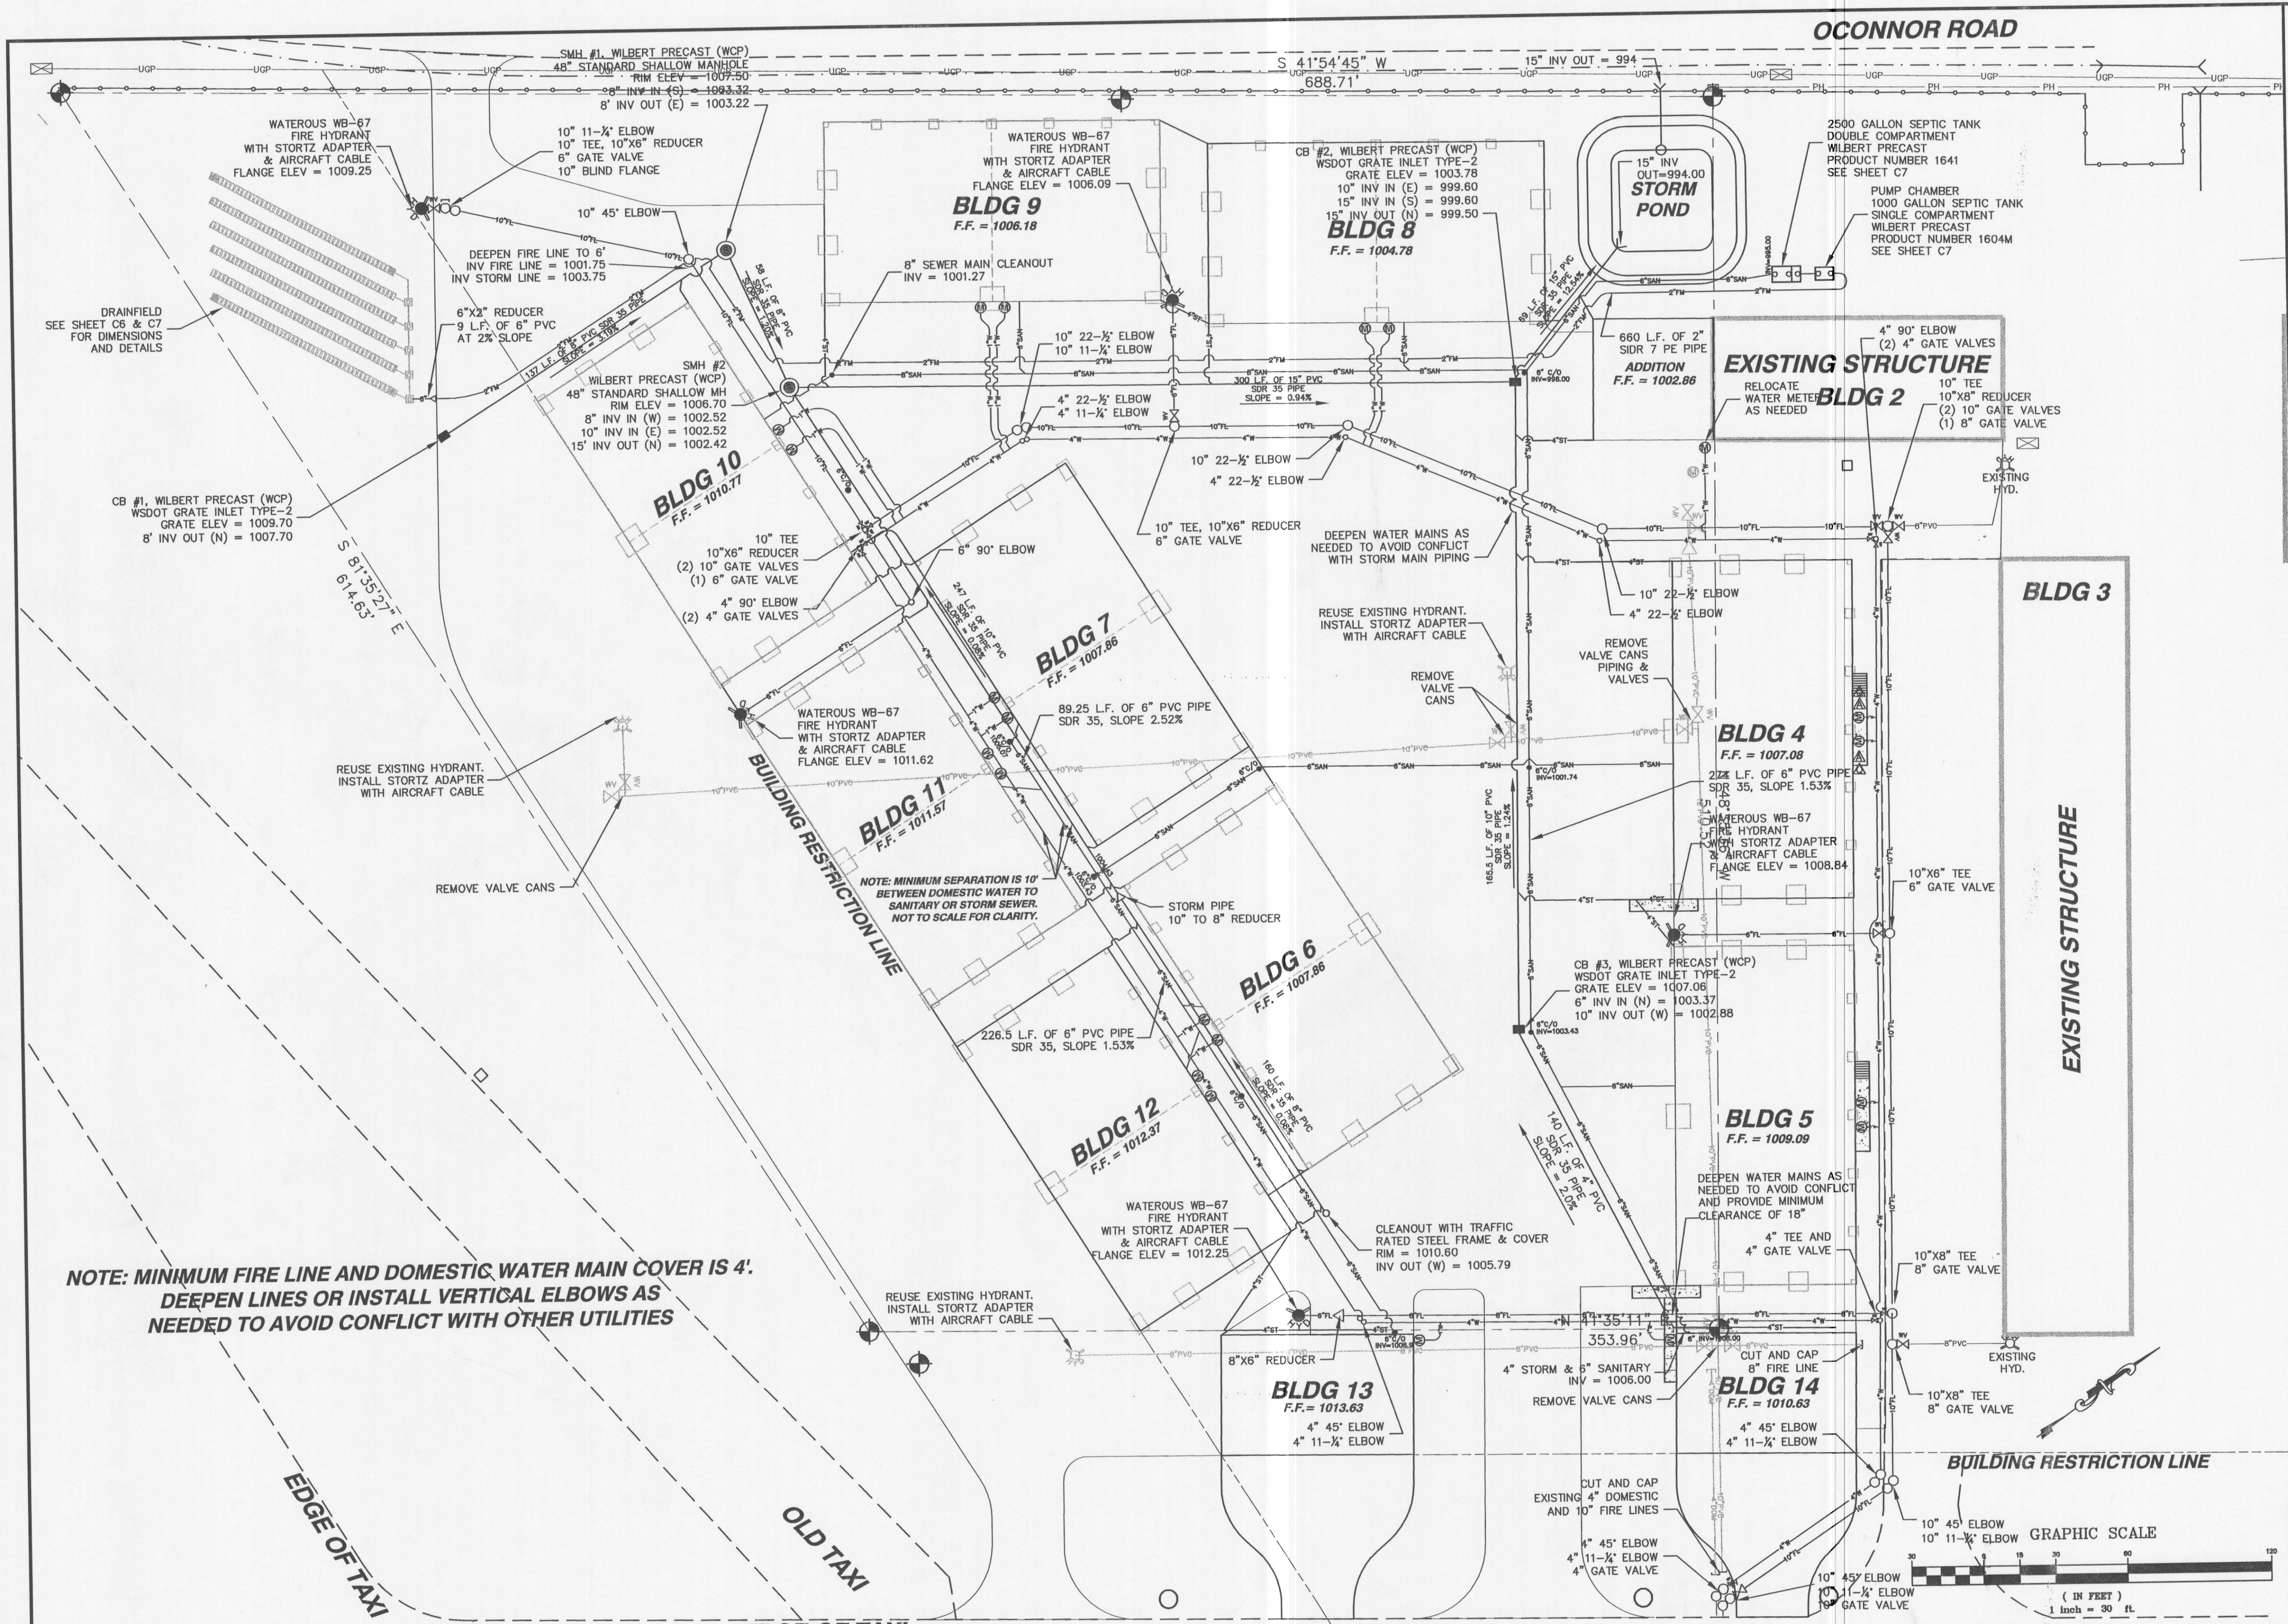

REVISIONS	
NO.	DATE
1	3-19-07

FILE NAME	BY	CHK

DATE	NO.
3-19-07	1

4025 EAGLE COURT
NACLINE ENGINEERING & DRAFTING
FAX (208) 720-1082
(208) 791-8055

HILLCREST AIRCRAFT
HANGER PROJECT 2007
UTILITY PLAN

DRAWN BY:	CHECKED BY:
CRF	CRF

DESIGNED BY:
CRF

SCALE:
1" = 30'

DATE:
3/19/07

PROJECT NO.:
00071

SHEET C4 OF 11