

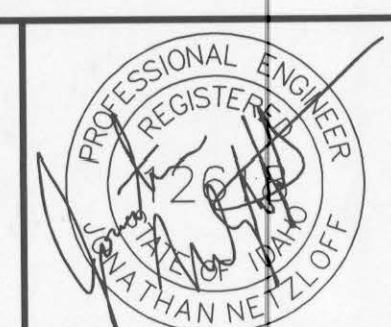


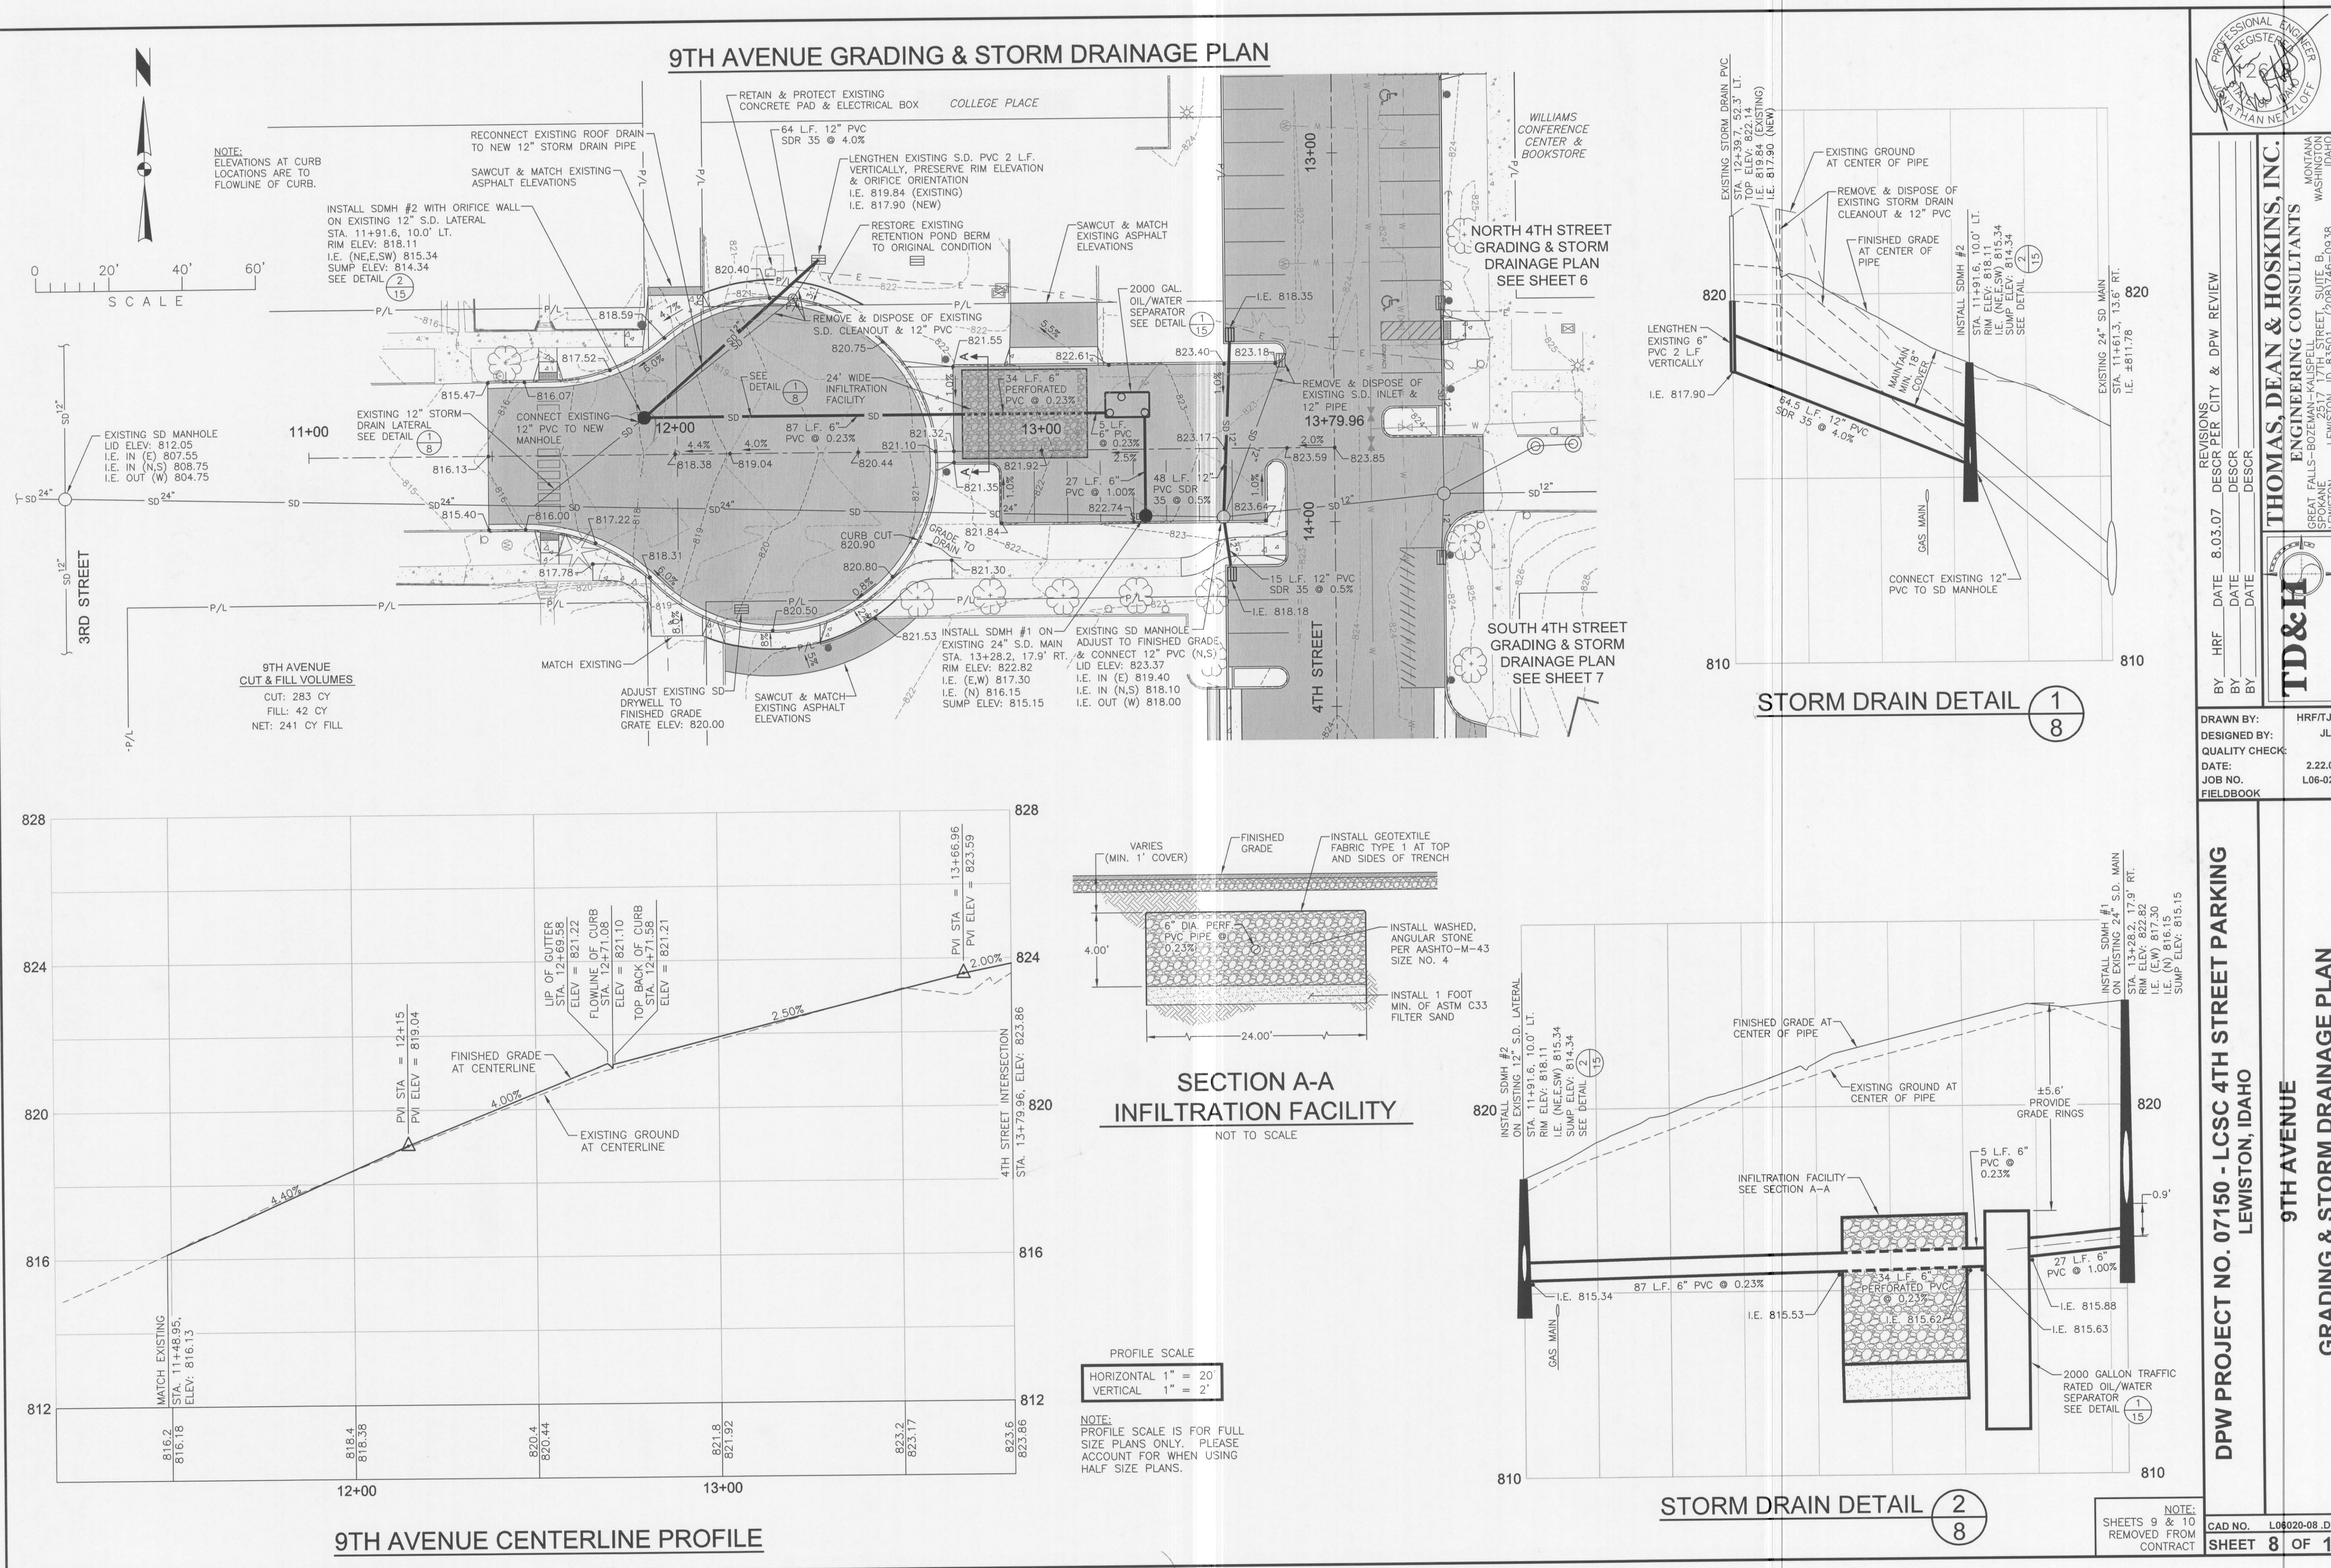

THOMAS, DEAN & HOSKINS, INC.
ENGINEERING CONSULTANTS
GREAT FALLS-BOZEMAN-KALISPELL STREET, SUITE B
LEWISTON, IDAHO 83501 (208) 746-0938

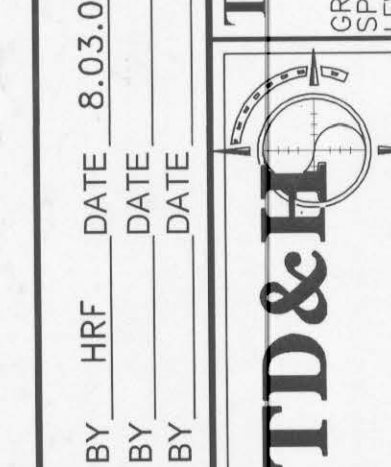

DRAWN BY: HRF/JJP
DESIGNED BY: JLN
QUALITY CHECK: JLN
DATE: 2.22.08
JOB NO. L06-020
FIELDBOOK

DPW PROJECT NO. 07150 - LCSC 4TH STREET PARKING
LEWISTON, IDAHO
9TH AVENUE
GRADING & STORM DRAINAGE PLAN

NOTE:
SHEETS 9 & 10
REMOVED FROM
CONTRACT

CAD NO. L06020-08.DWG
SHEET 8 OF 17