
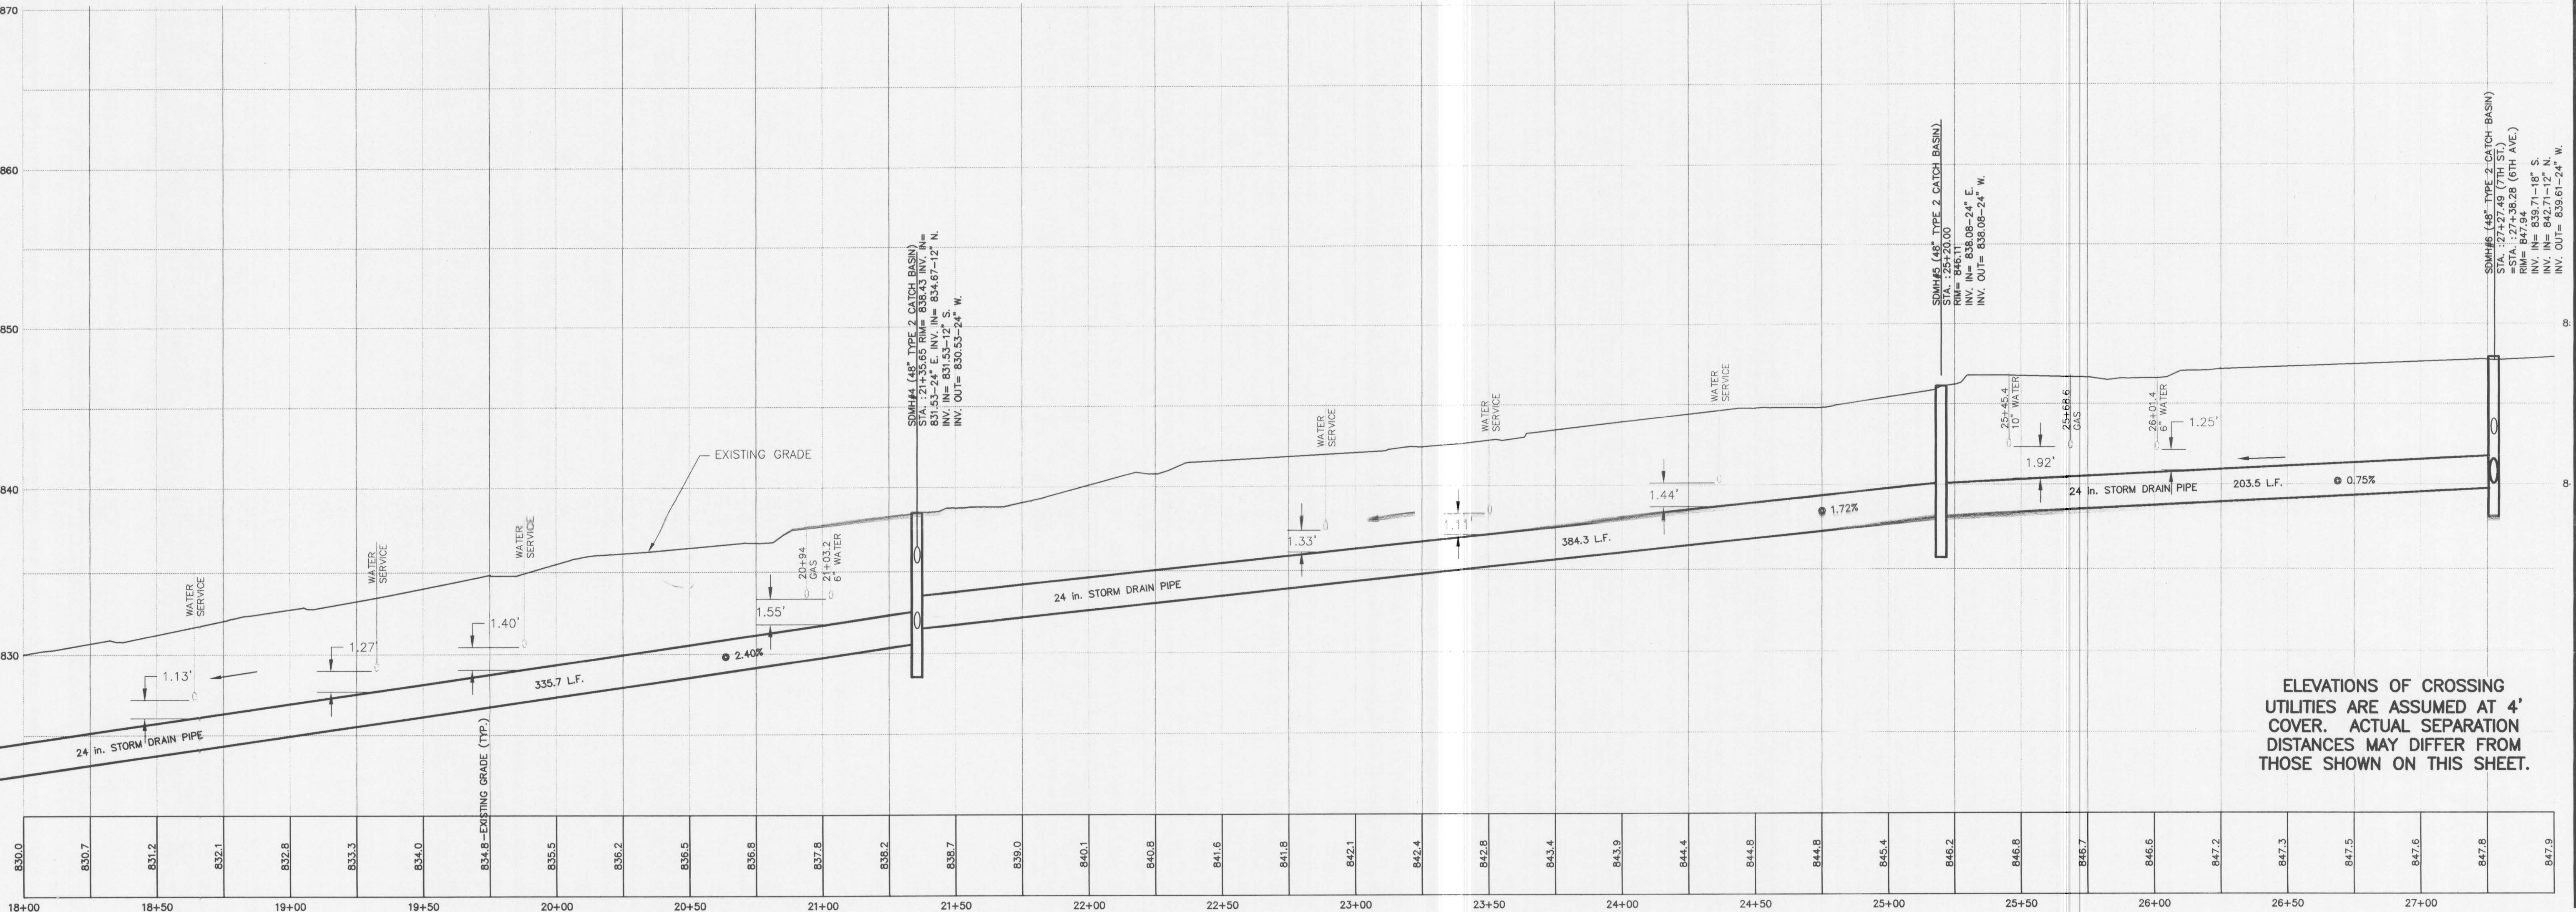


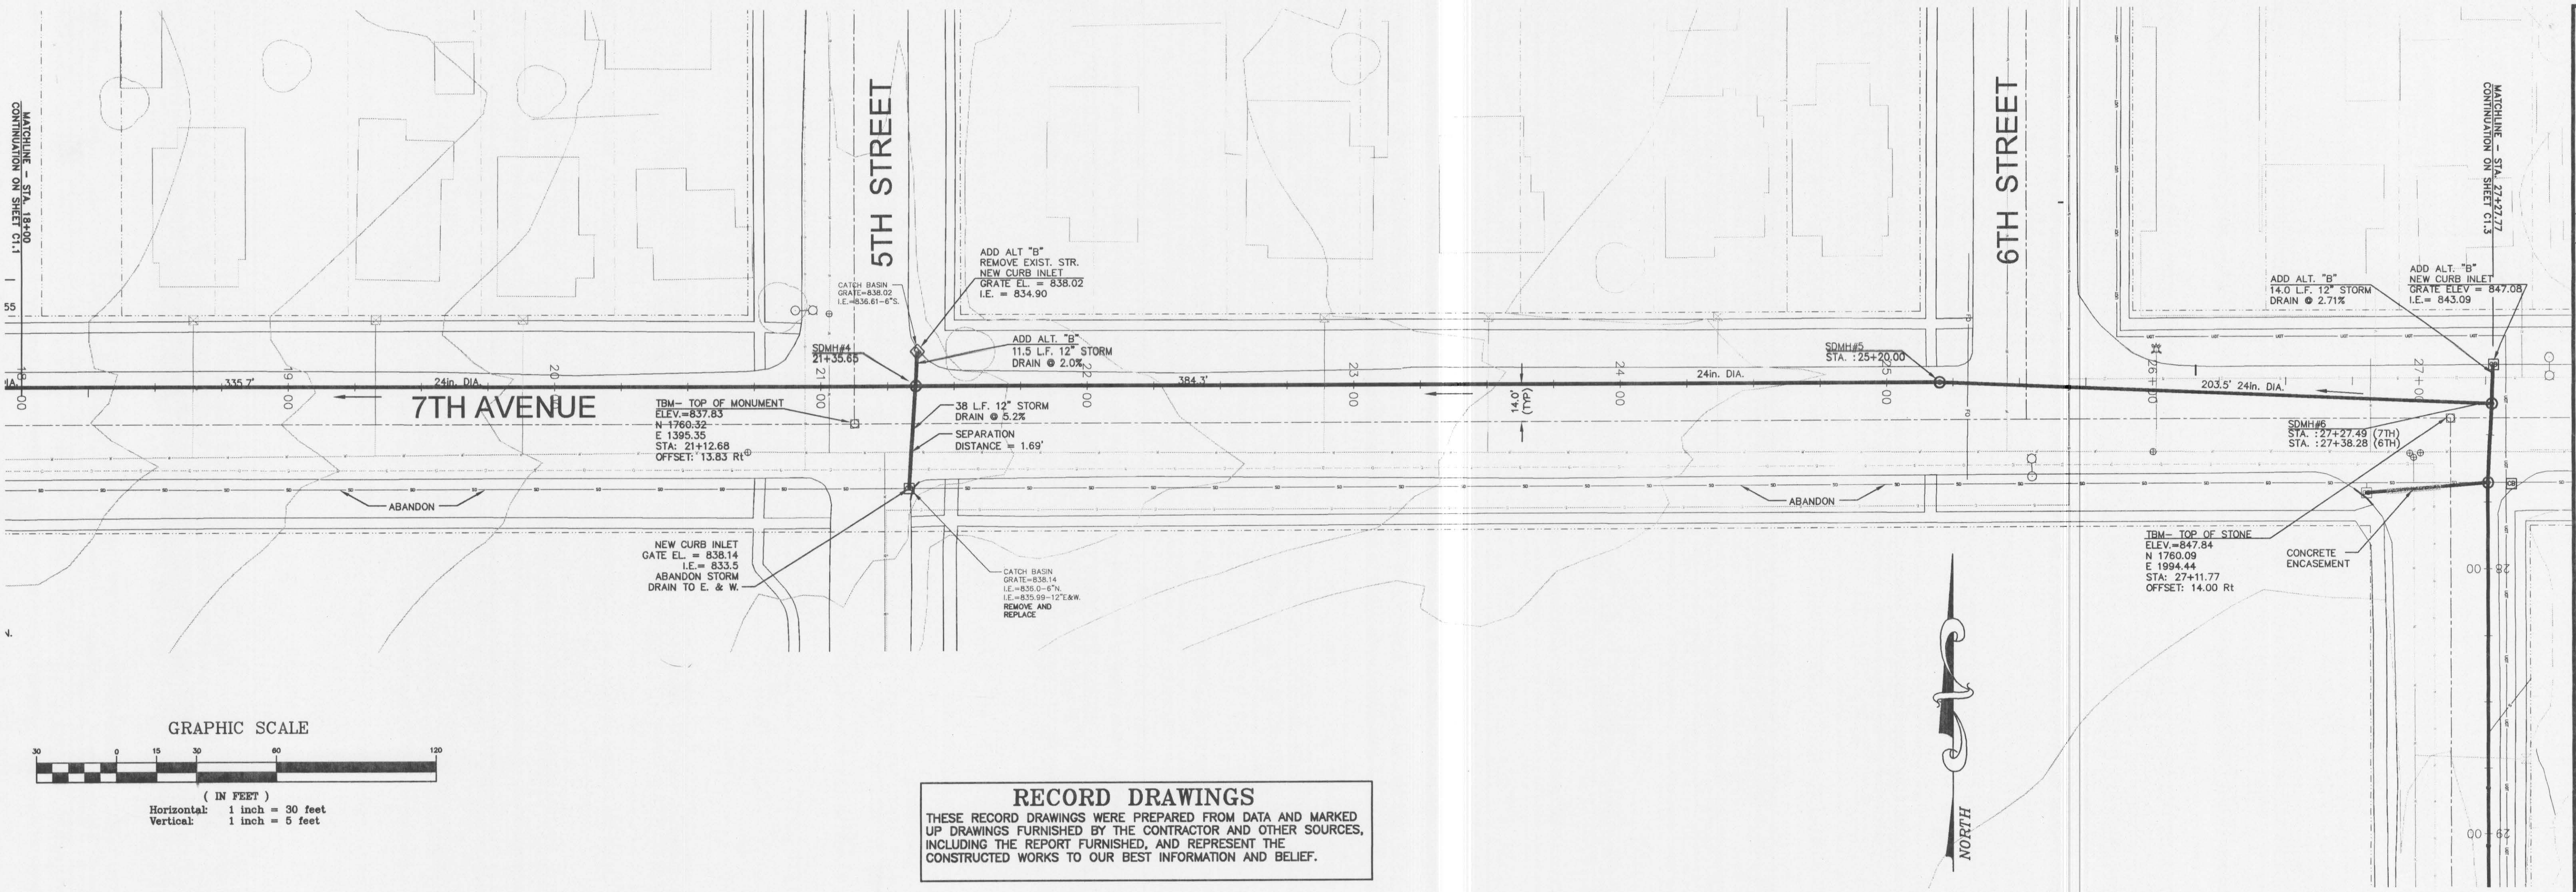

By		Revision		Date	

Engineering • Land Surveying
Planning • Materials Testing

313 S Street, Ste 200
Lewiston, ID 83501
Phone: (208) 746-2661
Fax: (208) 746-6825

LEWIS - CLARK STATE COLLEGE
STORMWATER SYSTEM IMPROVEMENTS 2005
DPW No. 04-150

PLAN AND PROFILE
7TH AVENUE
18+00 - 27+27.77

Project Mgr.	RLL
Drawn	RLL
Drawn	BDS
Checked	AG
Date	04-17-06
Sheet No.:	

C 1.2

USKH W.O. 737602