

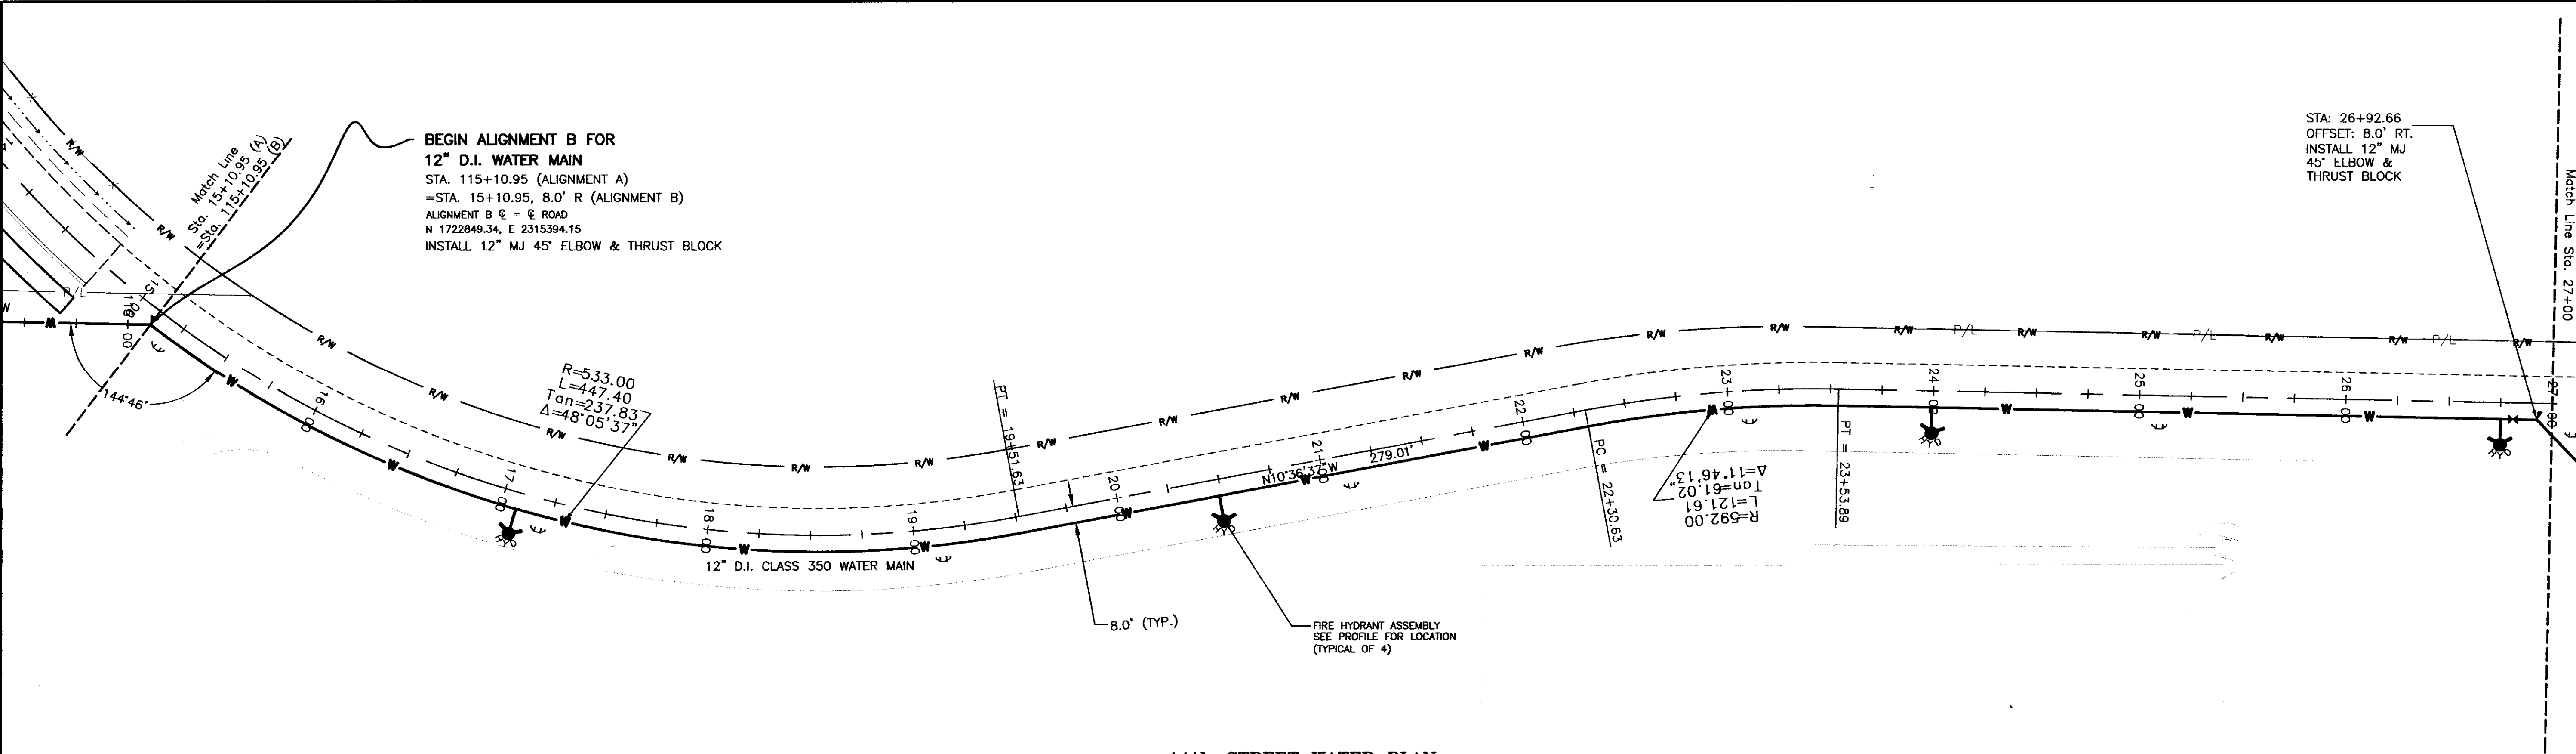


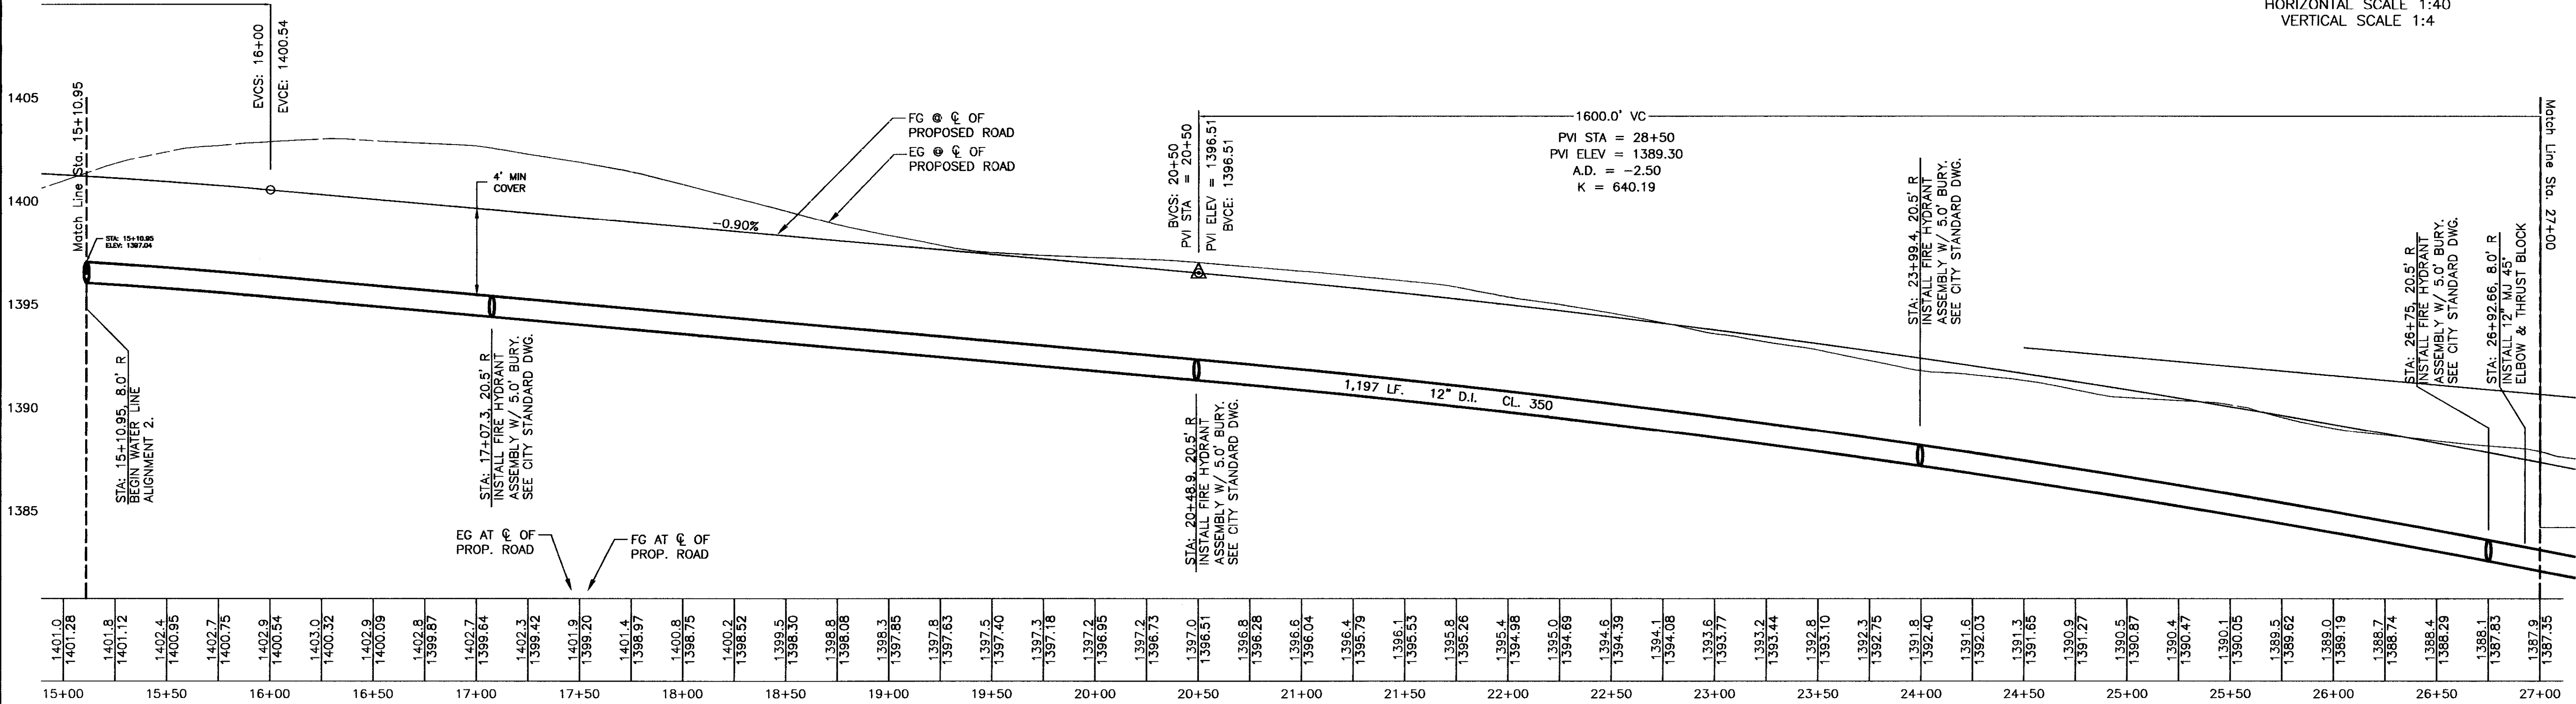

11th STREET WATER PLAN

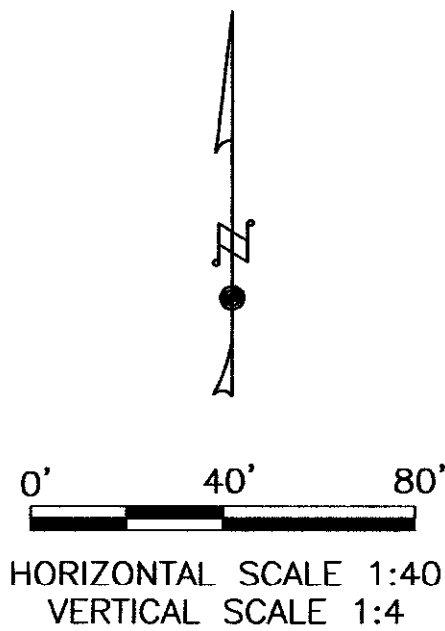

REVISIONS		DESIGNED BY:	SCALE:	1"=40'
		AMB		
		AMB		
		SM		
		COMMUNITY_PARK_ROAD		
		BY:		
		DESCRIPTION		
		FILENAME		
		DATE		
		NO.		

11th STREET WATER EXTENSION
- JOINT USE SITE

WATER MAIN PLAN AND PROFILE
STA. 15+10.95 TO 27+00 (ALIGNMENT B)

PROFESSIONAL ENGINEER
STATE OF IDAHO
KATHARINE M. BAILEY
08/19/2010

CITY OF LEWISTON
1861

CITY OF LEWISTON
PUBLIC WORKS DEPARTMENT
ENGINEERING SERVICES
184 F STREET, LEWISTON ID 83401
208-746-618
FAX 208-746-9667