
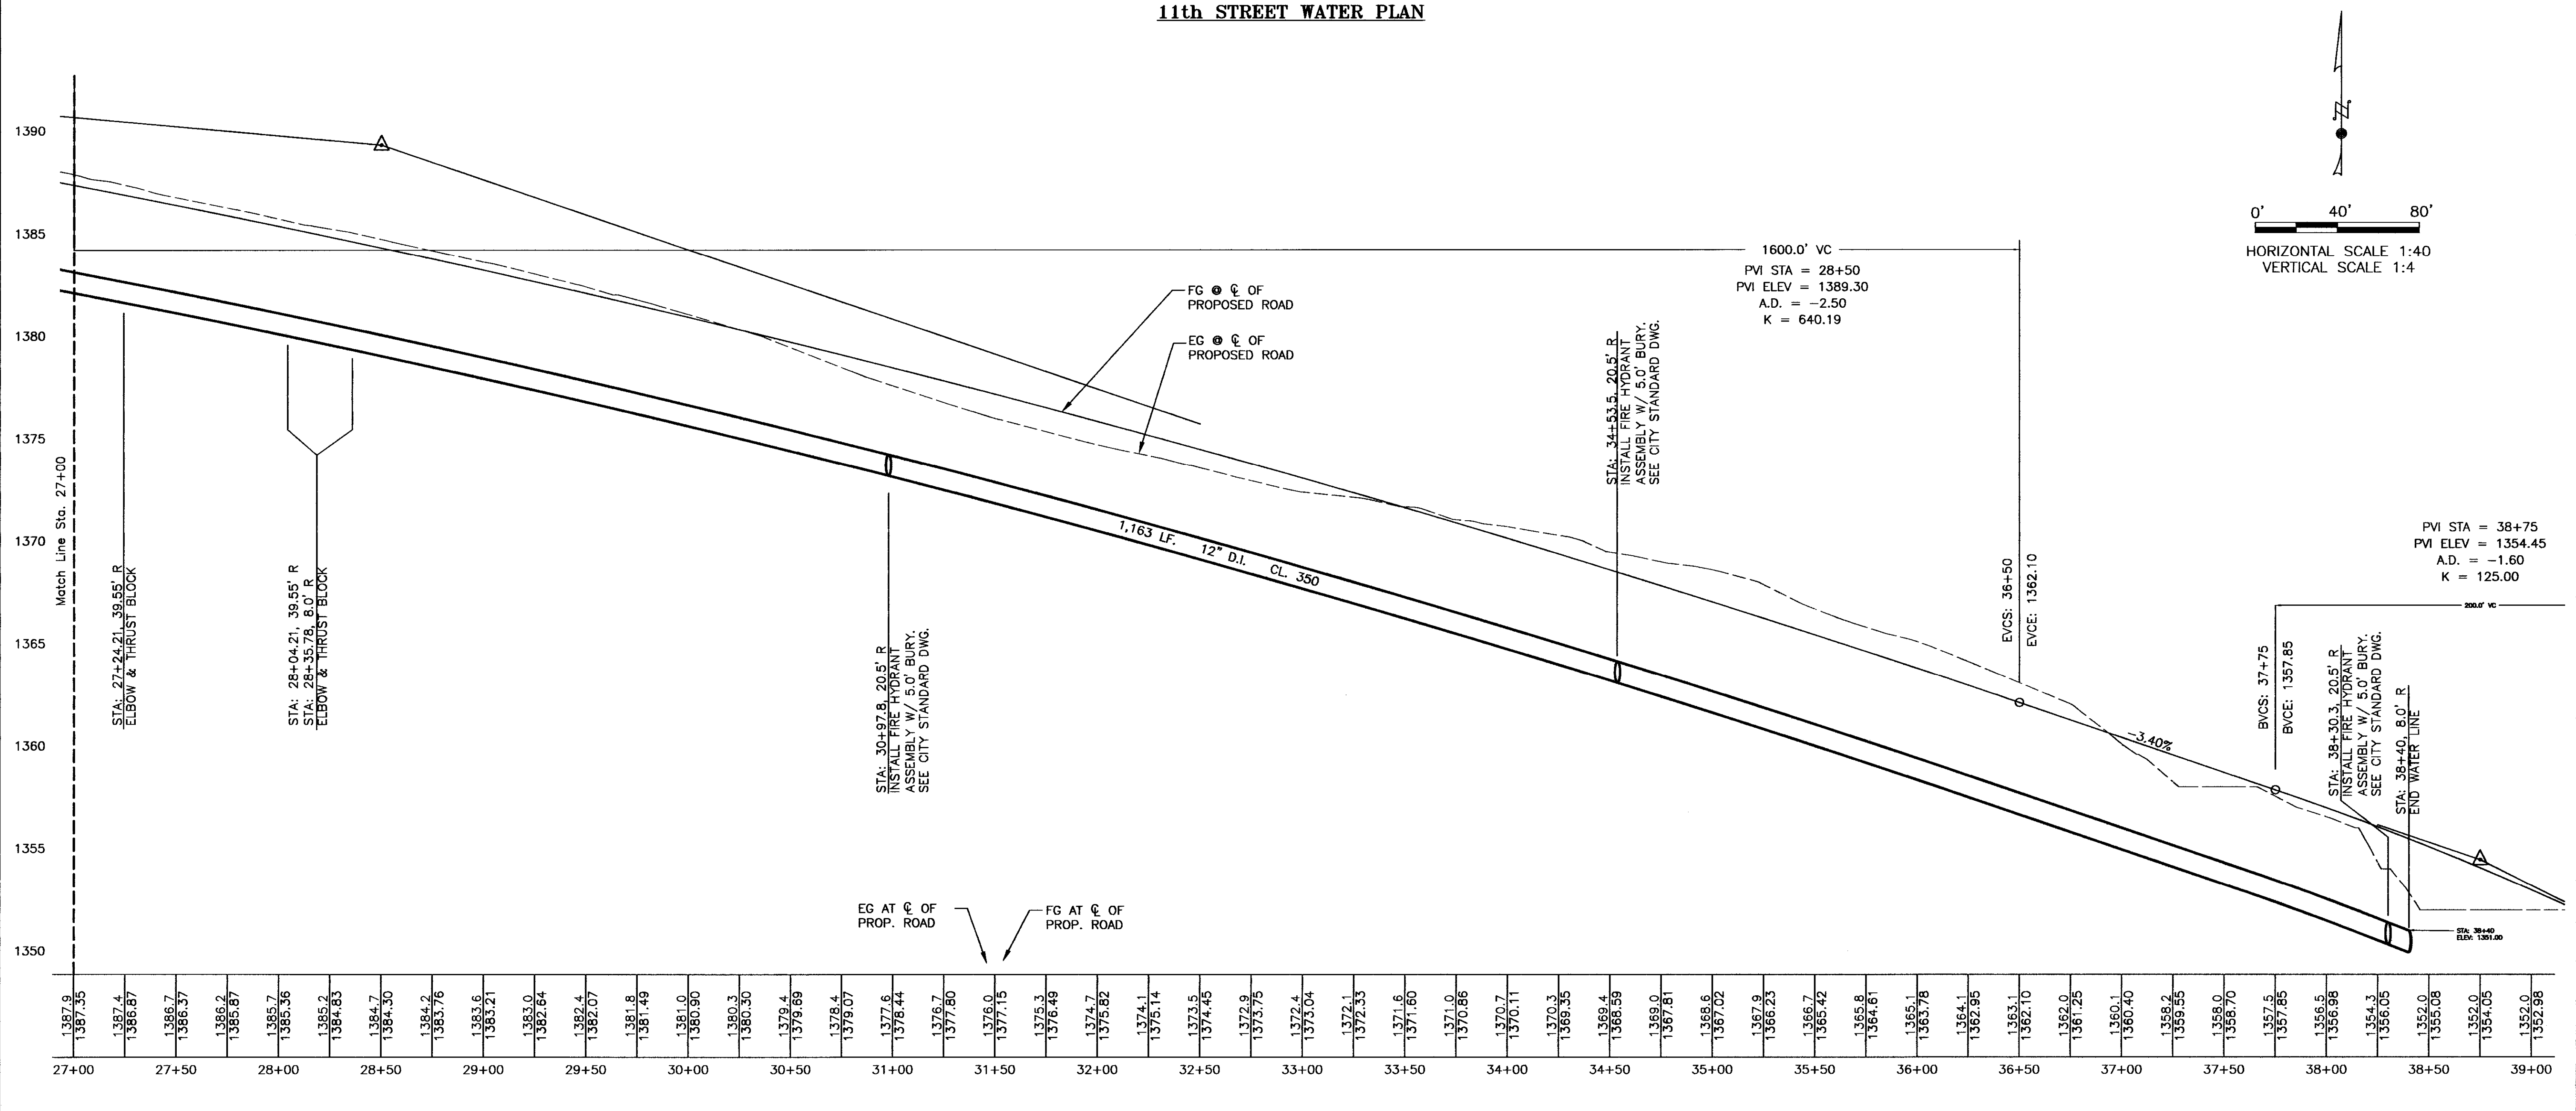


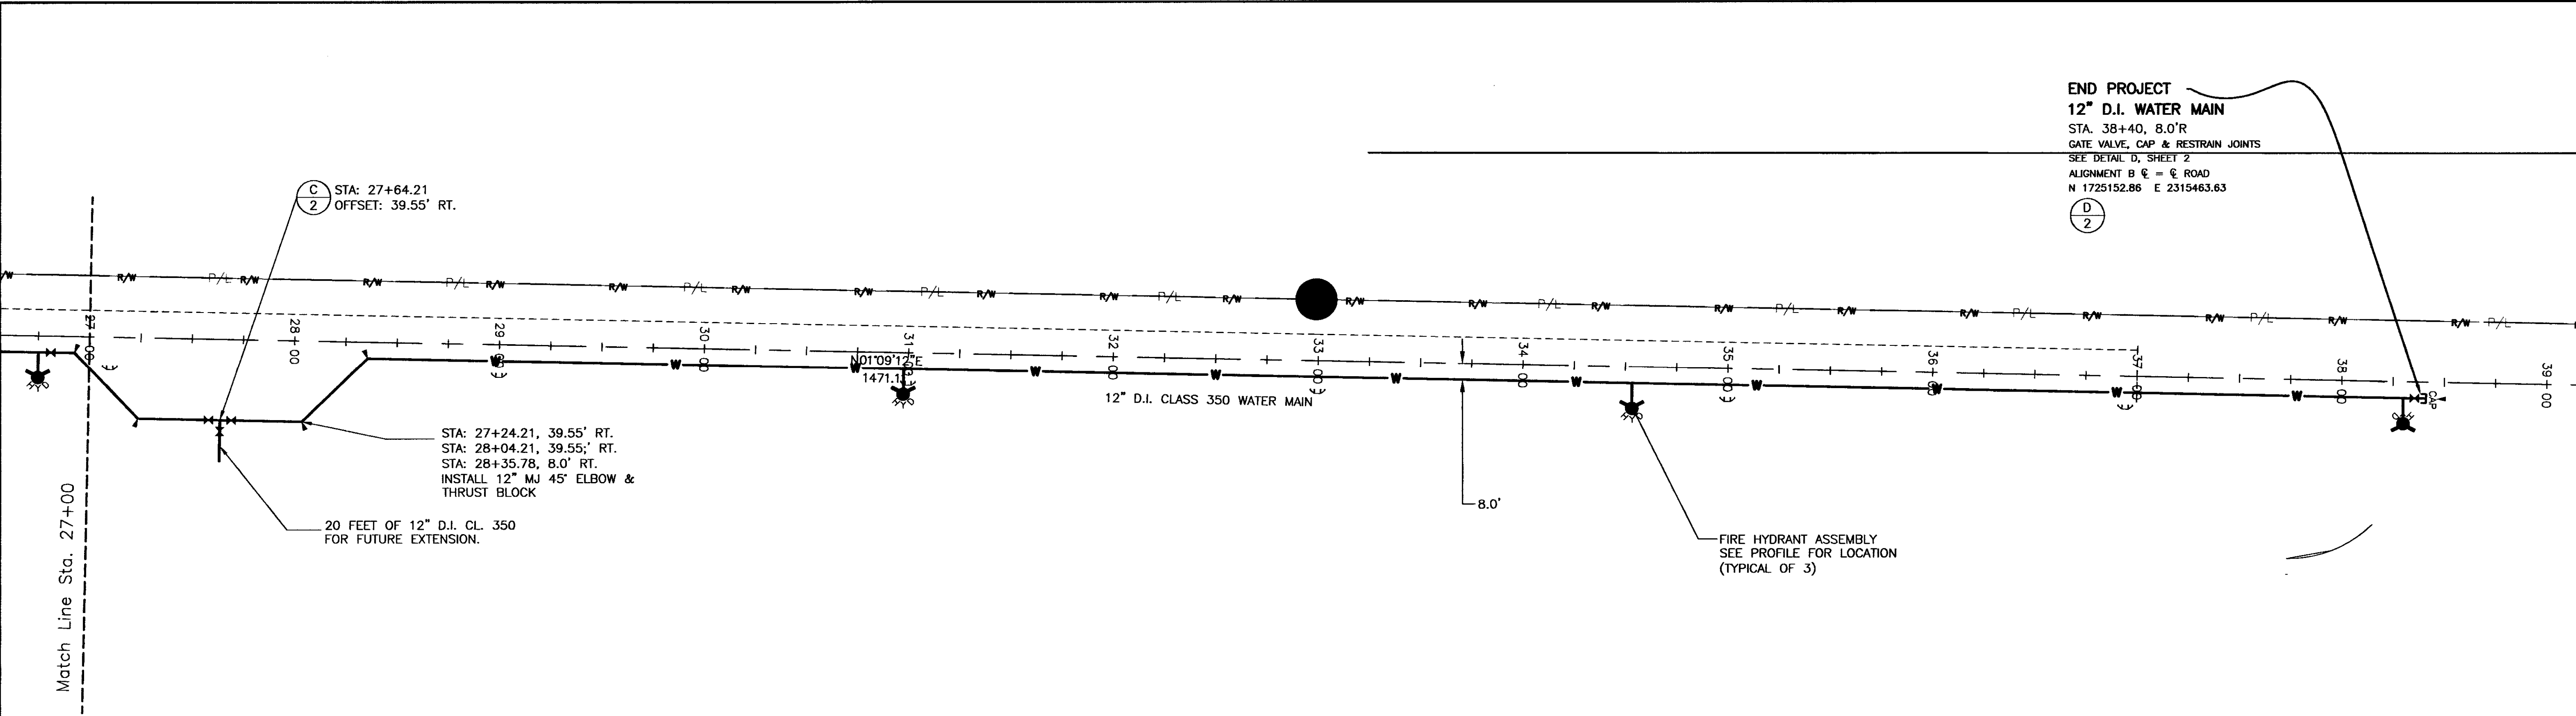

| REVISIONS |  | DESIGNED BY:        | SCALE: | 1"=40' |
|-----------|--|---------------------|--------|--------|
|           |  | AMB                 |        |        |
|           |  | AMB                 |        |        |
|           |  | SM                  |        |        |
|           |  | COMMUNITY_PARK_ROAD |        |        |
|           |  | BY                  |        |        |
|           |  | FILENAME            |        |        |
|           |  | DATE                |        |        |
|           |  | NO.                 |        |        |

11th STREET WATER EXTENSION  
- JOINT USE SITE

WATER PLAN AND PROFILE  
STA. 27+00 TO 38+40 (ALIGNMENT B)

CITY OF LEWISTON  
PUBLIC WORKS DEPARTMENT  
ENGINEERING SERVICES  
184 F STREET, LEWISTON ME 04201  
208-746-936  
FAX 208-746-9687

PROFESSIONAL ENGINEER  
ALAN M. BAILEY  
STATE OF MAINE  
8819/2010

CITY OF LEWISTON  
1861