


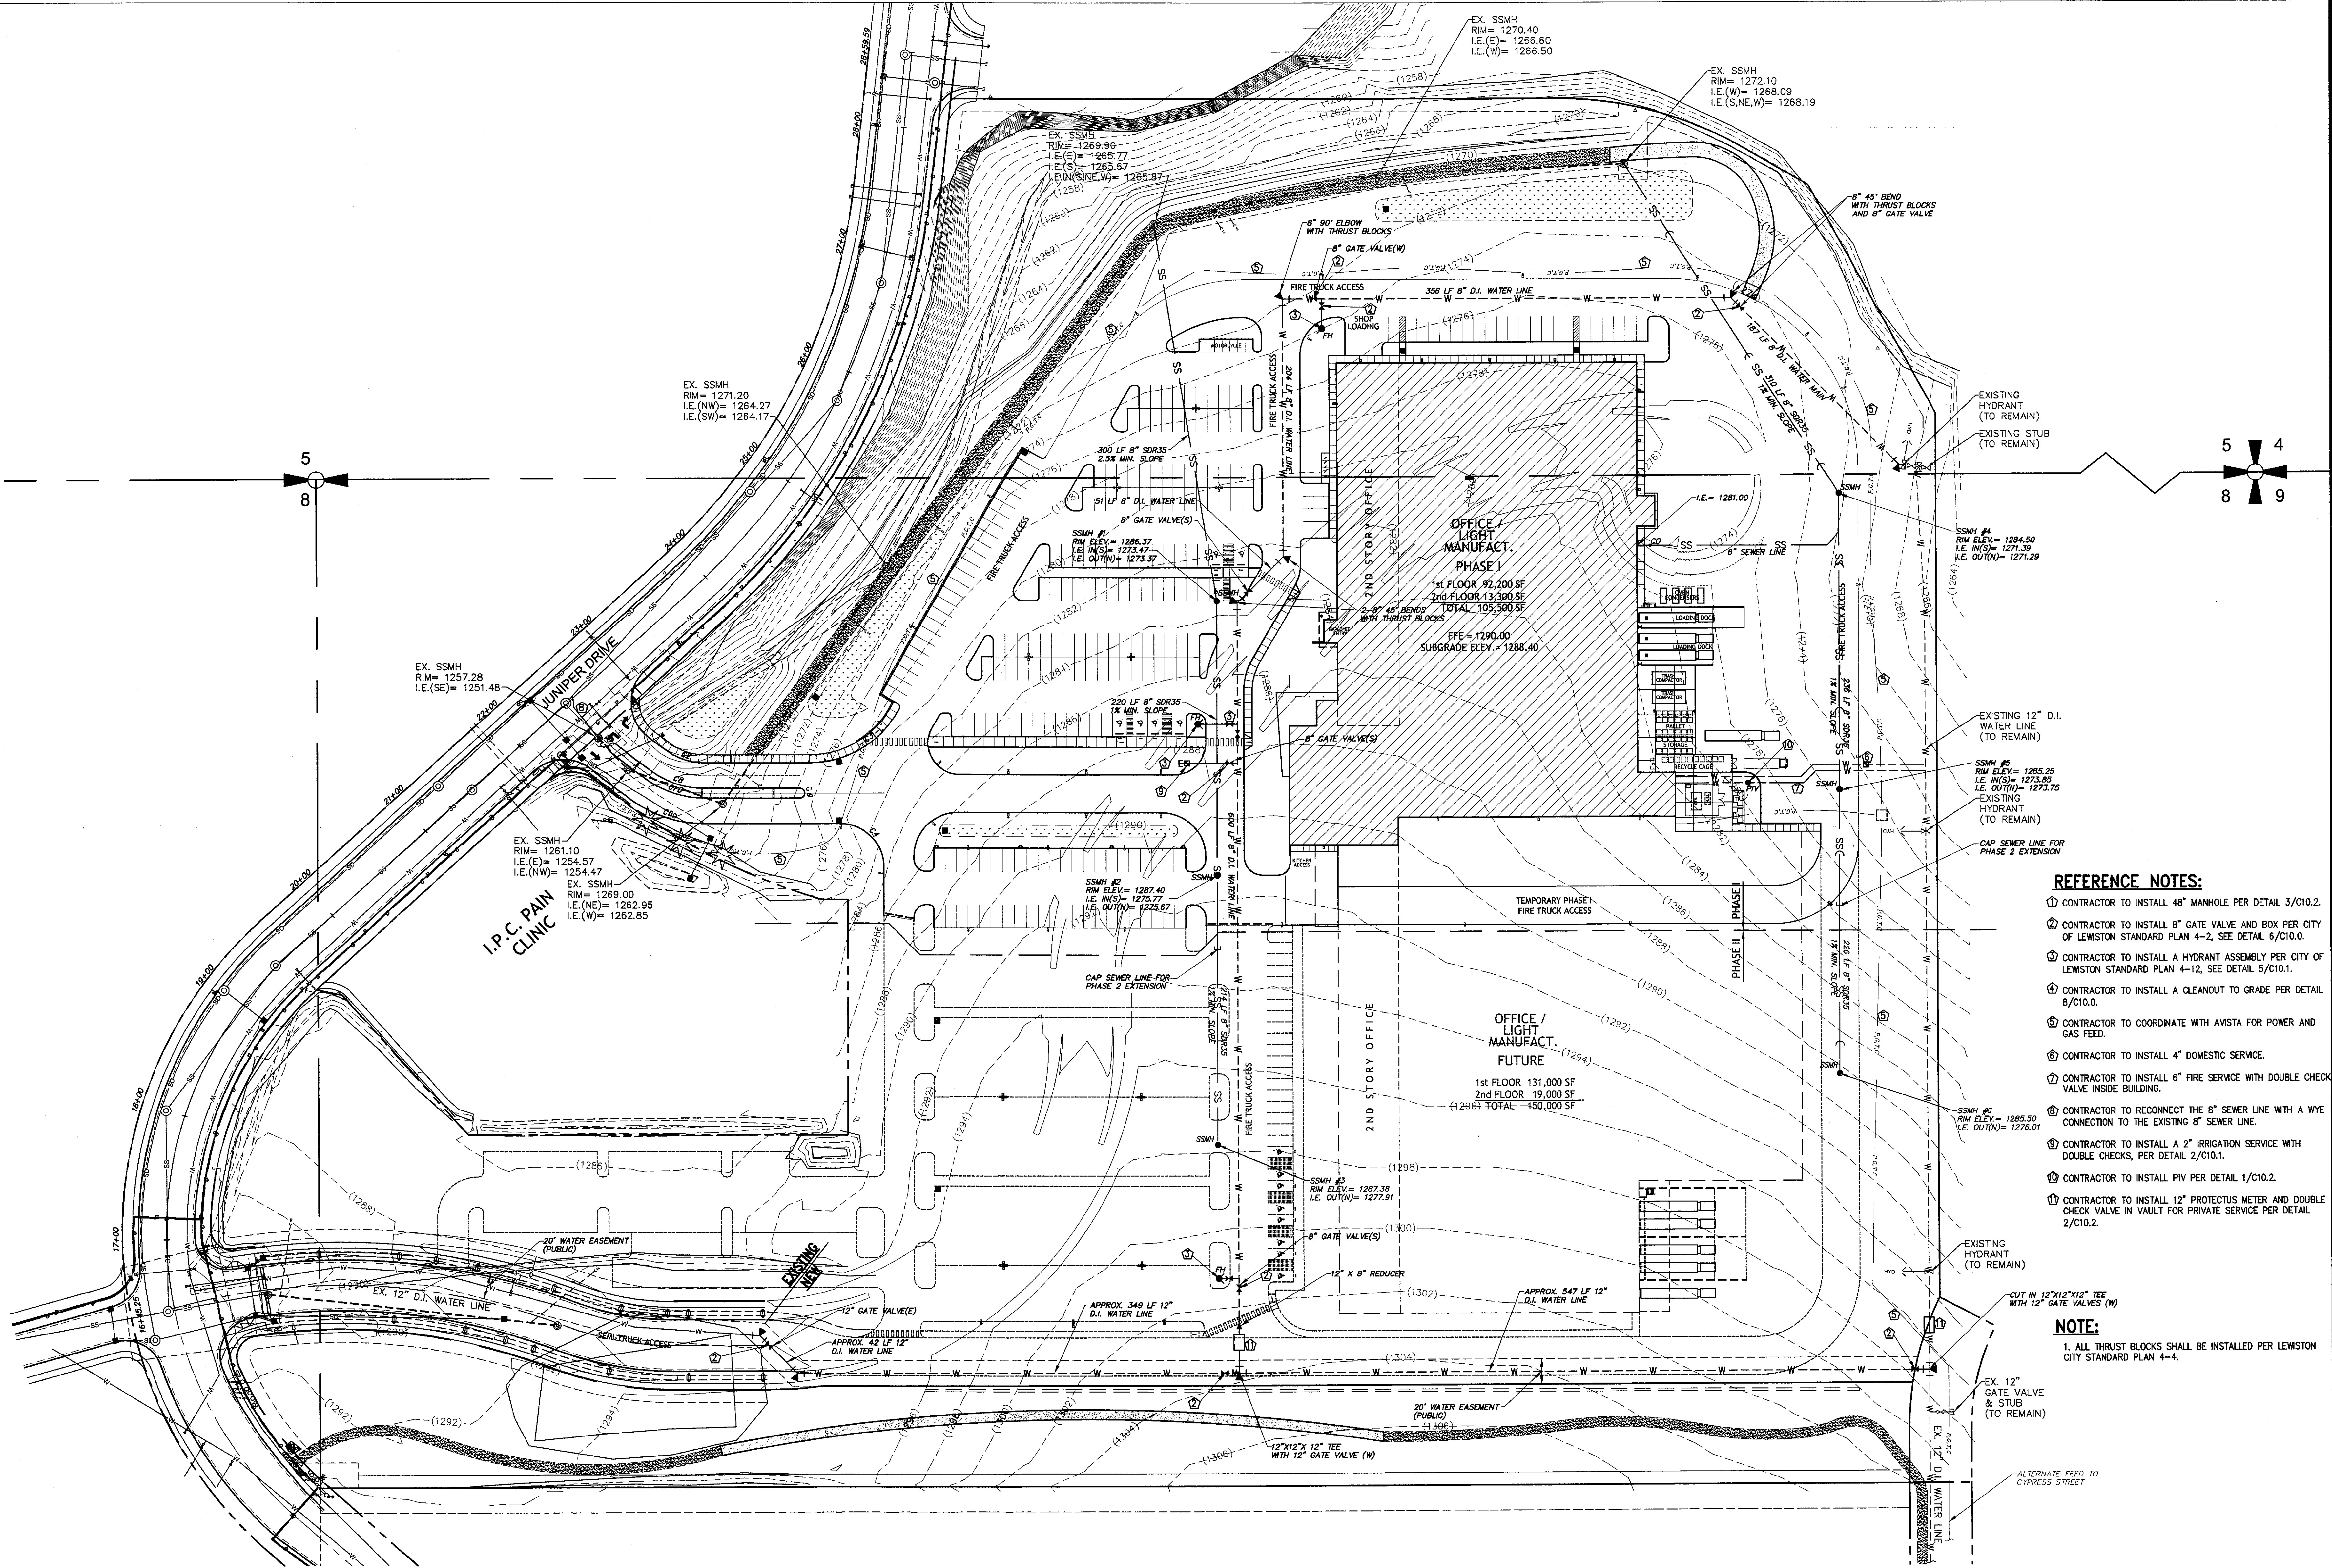

REFERENCE NOTES:


- CONTRACTOR TO INSTALL 48" MANHOLE PER DETAIL 3/C10.2.
- CONTRACTOR TO INSTALL 8" GATE VALVE AND BOX PER CITY OF LEWISTON STANDARD PLAN 4-2, SEE DETAIL 6/C10.0.
- CONTRACTOR TO INSTALL A HYDRANT ASSEMBLY PER CITY OF LEWISTON STANDARD PLAN 4-12, SEE DETAIL 5/C10.1.
- CONTRACTOR TO INSTALL A CLEANOUT TO GRADE PER DETAIL 8/C10.0.
- CONTRACTOR TO COORDINATE WITH AVISTA FOR POWER AND GAS FEED.
- CONTRACTOR TO INSTALL 4" DOMESTIC SERVICE.
- CONTRACTOR TO INSTALL 6" FIRE SERVICE WITH DOUBLE CHECK VALVE INSIDE BUILDING.
- CONTRACTOR TO RECONNECT THE 8" SEWER LINE WITH A WYE CONNECTION TO THE EXISTING 8" SEWER LINE.
- CONTRACTOR TO INSTALL A 2" IRRIGATION SERVICE WITH DOUBLE CHECKS, PER DETAIL 2/C10.1.
- CONTRACTOR TO INSTALL PIV PER DETAIL 1/C10.2.
- CONTRACTOR TO INSTALL 12" PROTECTIVE METER AND DOUBLE CHECK VALVE IN VAULT FOR PRIVATE SERVICE PER DETAIL 2/C10.2.

NOTE:

- ALL THRUST BLOCKS SHALL BE INSTALLED PER LEWISTON CITY STANDARD PLAN 4-4.




GRAPHIC SCALE

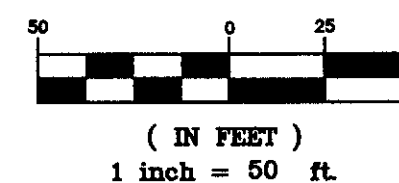

CONTRACTOR NOTE

ALL EXISTING UTILITIES SHOWN ON PLANS ARE TO BE VERIFIED HORIZONTALLY AND VERTICALLY PRIOR TO ANY CONSTRUCTION. ALL EXISTING FEATURES INCLUDING BURIED UTILITIES ARE SHOWN AS INDICATED ON RECORD MAPS AND SURVEYS FURNISHED BY OTHERS. WE ASSUME NO LIABILITY FOR THE ACCURACY OF THOSE RECORDS AND SURVEYS. CONTACT THE UTILITY OWNER/AGENCY FOR THE FINAL LOCATION OF EXISTING UTILITIES IN AREAS CRITICAL TO CONSTRUCTION.

UNDERGROUND SERVICE ALERT
ONE-CALL NUMBER
(800)342-1585
CALL TWO BUSINESS DAYS
BEFORE YOU DIG

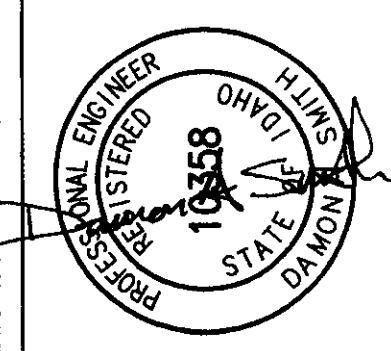

B. W. A. BERNARILLO
ENGINEERS
601 WEST RIVER, SUITE 600
SPOKANE, WASHINGTON 99201
PHONE: (509) 338-4511
FAX: (509) 338-4511
WWW.BERNARILLO.COM

Site Development Package - Permit Set
January 21, 2011
Utility Plan

Schweitzer Engineering Laboratories
Manufacturing Facility - Phase I
2821 Juniper Drive
Lewiston, Idaho 83501

B. W. A. BERNARILLO
ARCHITECTS PC
133 SOUTH JEFFERSON
SPOKANE, WASHINGTON 99201
509-338-4511
FAX 509-338-4505
WWW.BERNARILLO.COM

Project No: 10-42-0041
Drawn by: JFS
Date: 1/21/2011
C9.0