

# CITY OF LEWISTON


## NEZ PERCE COUNTY, IDAHO

### 2018 EAST ORCHARDS SEWER EXPANSION PHASE I



<b>OWNER</b> CITY OF LEWISTON 215 D. STREET LEWISTON, ID 83501 (208) 746-1316	<b>CIVIL/MECHANICAL ENGINEER</b> MOUNTAIN WATERWORKS 111 W MAIN ST, STE 175 LEWISTON, ID 83501 (208) 780-3990	<b>SURVEY/CONSTRUCTION INSPECTION</b> JUB ENGINEERS 201 JACKSON STREET MOSCOW, ID 83843 (208) 746-9010
---	---	--

#### DRAWING INDEX

G-1	TITLE SHEET	C-10	PLAN & SECTION
G-2	GENERAL NOTES	C-11	PLAN & SECTION
G-3	LINE LEGEND / PIPE SCHEDULE	C-12	PLAN & SECTION
G-4	LEGEND AND SYMBOLS	C-13	PLAN & SECTION
K-1	KEY MAP / OVER ALL SITE PLAN	C-14	PLAN & SECTION
TCP-1	TRAFFIC CONTROL PLAN	C-15	PLAN & SECTION
TCP-2	TRAFFIC CONTROL PLAN	CD-1	CIVIL DETAILS
C-1	PLAN & SECTION	CD-2	CIVIL DETAILS
C-2	PLAN & SECTION	CD-3	CIVIL DETAILS
C-3	PLAN & SECTION	CD-4	CIVIL DETAILS
C-4	PLAN & SECTION	CD-5	CIVIL DETAILS
C-5	PLAN & SECTION	CD-6	CIVIL DETAILS
C-6	PLAN & SECTION	CD-7	CIVIL DETAILS
C-7	PLAN & SECTION	CD-8	CIVIL DETAILS
C-8	PLAN & SECTION		
C-9	PLAN & SECTION		

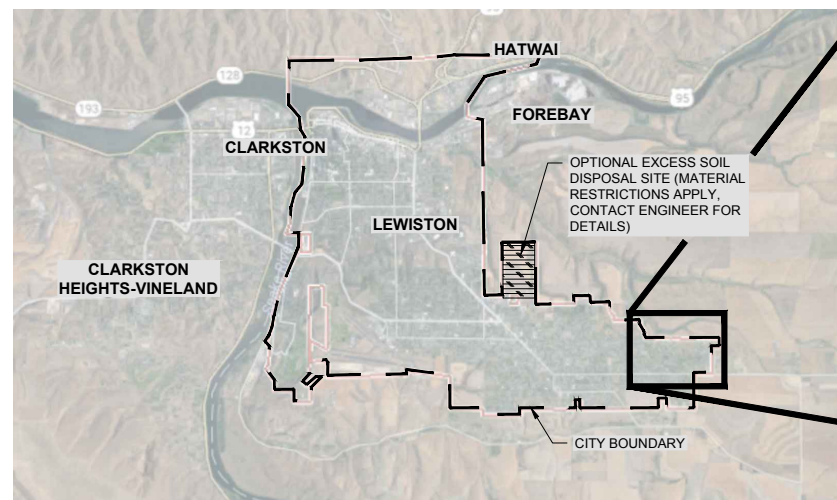

VICINITY MAP

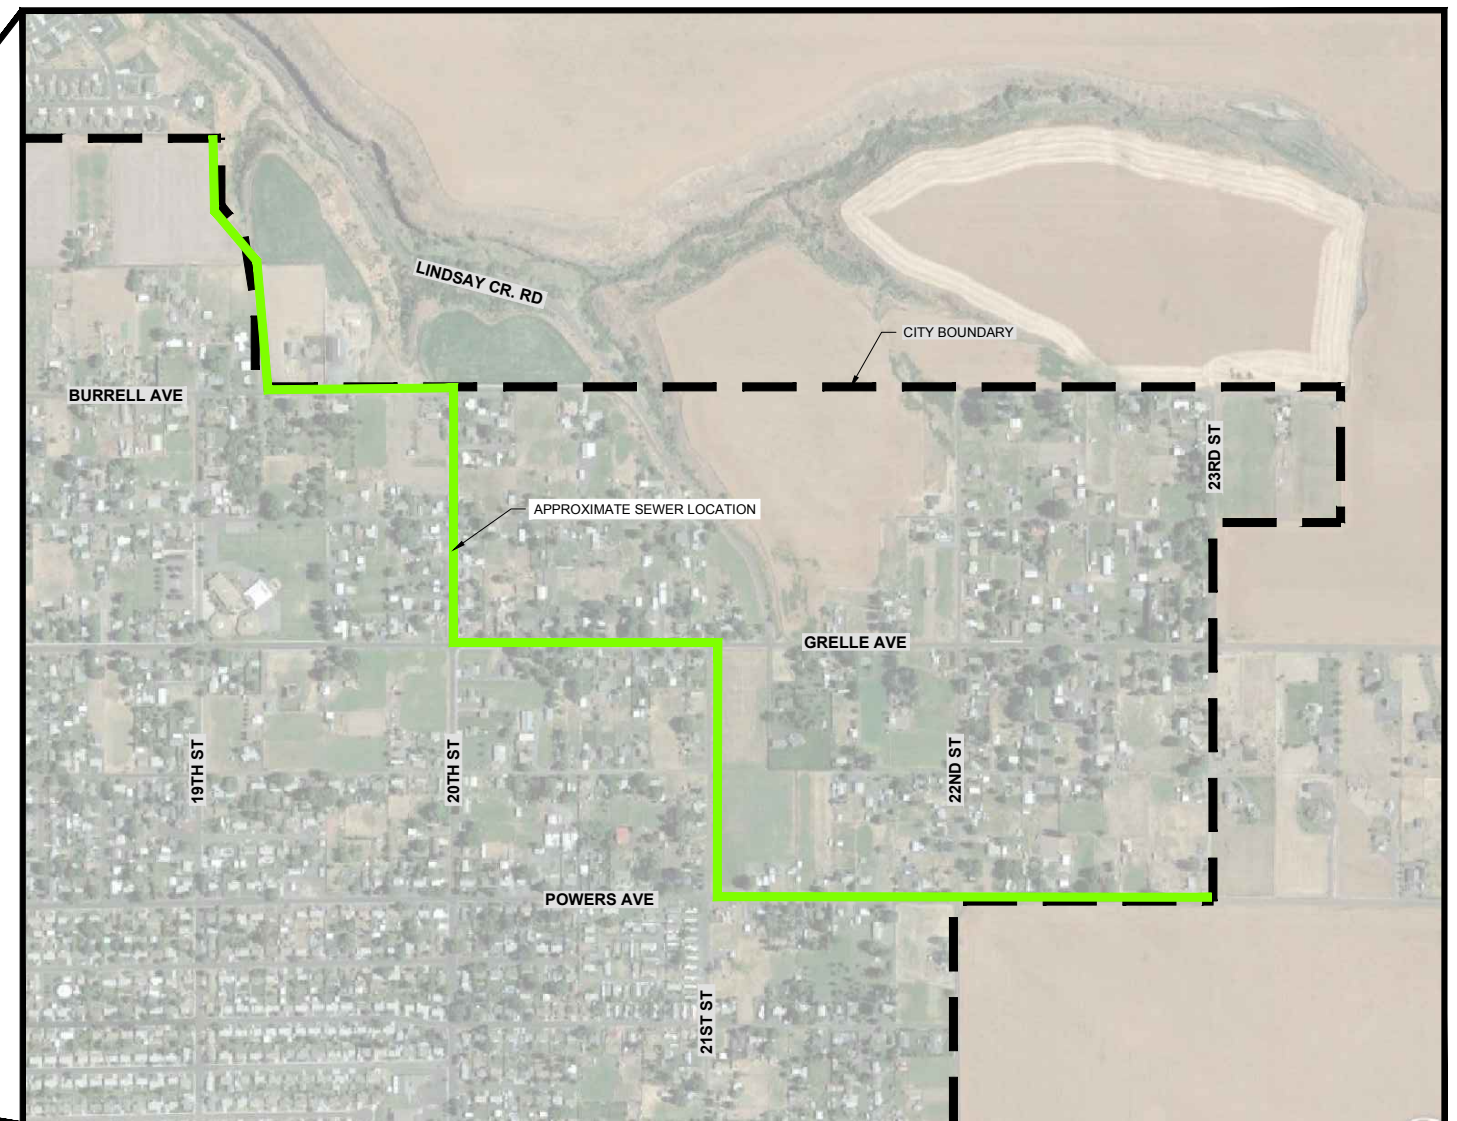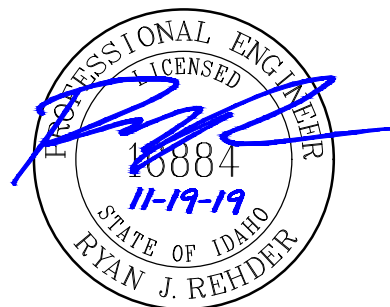

LOCATION MAP



Path: E:\Projects\1810020 Phase I\CA\B\AB C-1.dwg File Name: AB C-1.dwg Plot Date: 11/20/2019 5:08 PM Doc#

NO.	REVISION	BY	DATE	DESIGN
				DRAWN
				OTW
				CHECKED
				APPROVED

#### RECORD DRAWING

THESE RECORD DRAWINGS HAVE BEEN PREPARED BASED IN PART ON INFORMATION PROVIDED BY OTHERS

THIS DRAWING WAS PREPARED ONLY FOR THE PROJECT AND SITE SPECIFICALLY IDENTIFIED HEREON AND IS NOT TO BE USED ELSEWHERE



#### ENGINEERING AND ENVIRONMENTAL SOLUTIONS

111 MAIN ST. SUITE 175  
LEWISTON, IDAHO 83501  
208.780.3990

IDAHO OFFICES  
BOISE · LEWISTON · COEUR D'ALENE

#### EAST ORCHARDS SEWER EXPANSION

LEWISTON, IDAHO

TITLE SHEET

#### VERIFY SCALE

BAR IS ONE INCH ON FULL SIZE DRAWING

PROJECT : 181.0020

DATE : 11/19/2019

DRAWING NO.

G-1

**GENERAL NOTES:**

1. ALL CONSTRUCTION WORK SHALL CONFORM TO THE 2015 VERSION OF THE IDAHO STANDARDS FOR PUBLIC WORKS CONSTRUCTION (ISPMC) , THE PLANS AND SPECIFICATIONS INCLUDING ANY AMENDMENTS, AS WELL AS FEDERAL, STATE AND LOCAL REQUIREMENTS. IN THE CASE OF CONFLICT, REFER TO ARTICLE 9 OF THE AGREEMENT. CONTRACTOR SHALL MAINTAIN A COMPLETE HARD COPY OF THE 2015 EDITION OF THE ISPMC ON THE PROJECT SITE AT ALL TIMES.
2. ALL APPROVALS AND PERMITS REQUIRED BY THE CITY OF LEWISTON, IDAHO DEPARTMENT OF TRANSPORTATION, NEZ PERCE COUNTY, UNITED STATES ENVIRONMENTAL PROTECTION AGENCY AND UNITED STATES ARMY CORPS OF ENGINEERS SHALL BE OBTAINED BY THE CONTRACTOR PRIOR TO THE START OF CONSTRUCTION.
3. EXISTING SITE INFORMATION INCLUDING THE LOCATION OF EXISTING SITE CONDITIONS, SURFACE TOPOGRAPHY AND PROJECT BENCHMARKS AS SHOWN ON THESE PLANS HAVE BEEN PROVIDED BY J-U-B ENGINEERS THROUGH FIELD WORK PERFORMED IN THE SUMMER OF 2017.
4. THE TYPES, LOCATIONS, SIZES AND/OR DEPTHS OF EXISTING UNDERGROUND UTILITIES AS SHOWN ON THESE DRAWINGS WERE OBTAINED FROM SOURCES OF VARYING RELIABILITY. THE CONTRACTOR IS CAUTIONED THAT ONLY ACTUAL EXCAVATION WILL REVEAL THE TYPES, EXTENT, SIZES, LOCATIONS AND DEPTHS OF SUCH UNDERGROUND UTILITIES. THE PROJECT ENGINEER ASSUMES NO RESPONSIBILITY FOR THE COMPLETENESS OR ACCURACY OF THE DELINEATION OF SUCH UNDERGROUND UTILITIES, OR THE EXISTENCE OF OTHER BURIED OBJECTS OR UTILITIES WHICH MAY BE ENCOUNTERED, BUT WHICH ARE NOT SHOWN ON THESE DRAWINGS. IT IS THE RESPONSIBILITY OF THE CONTRACTOR TO IDENTIFY EXACT LOCATIONS OF EXISTING UTILITIES PRIOR TO THE START OF ANY PROJECT CONSTRUCTION. ANY LOCATION WHICH MAY POSE A CONFLICT WITH THE PROPOSED CONSTRUCTION MUST BE REPORTED TO THE PROJECT ENGINEER PRIOR TO THE START OF ANY PROJECT CONSTRUCTION.
5. MINIMUM SEPARATION SHALL BE MAINTAINED BETWEEN POTABLE WATER MAINS AND NON-POTABLE WATER MAINS IN ACCORDANCE WITH THE CITY STANDARD DRAWINGS.
6. UNLESS DETAILED, SPECIFIED, OR OTHERWISE INDICATED ON THE DRAWINGS, CONSTRUCTION SHALL BE AS INDICATED ON THE APPLICABLE TYPICAL DETAILS, CITY STANDARD DRAWINGS, AND GENERAL NOTES. TYPICAL DETAILS SHALL APPLY EVEN THOUGH NOT REFERENCED AT SPECIFIC LOCATIONS ON DRAWINGS.
7. WHERE NO CONSTRUCTION DETAILS ARE SHOWN OR NOTED FOR ANY PART OF WORK, DETAILS SHALL BE THE SAME AS FOR OTHER SIMILAR WORK.
8. ANY CHANGES TO THE DESIGN AS SHOWN IN THESE CONSTRUCTION DRAWINGS MUST BE REVIEWED AND APPROVED BY THE PROJECT ENGINEER BEFORE CHANGES ARE MADE. THIS INCLUDES CHANGES REQUESTED BY THE OWNER AND SUBCONTRACTORS.
9. ALL SEWER MAIN LINES AND MANHOLES SHALL BE AIR/VACUUM TESTED IN ACCORDANCE WITH ISPMC.
10. ALL SEWER MAIN LINES SHALL BE HYDROCLEANED AND T'ED UPON COMPLETION OF ALL UNDERGROUND UTILITY WORK IN ACCORDANCE WITH ISPMC BY A LICENSED CCTV INSPECTION COMPANY SPECIALIZING IN SEWER INSPECTIONS. THE CONTRACTOR SHALL SUBMIT TWO (2) COPIES OF ALL REPORTS TO THE DESIGN ENGINEER FOR REVIEW PRIOR TO PAVING.
11. COAT ALL ALUMINUM IN CONTACT WITH CONCRETE WITH COAL TAR EPOXY.
12. COAT ALL WALL THIMBLES WITH COAL TAR EPOXY.
13. CONTRACTOR SHALL MAINTAIN A COPY OF THE IDAHO DEPARTMENT OF ENVIRONMENTAL QUALITY APPROVED PLANS AND SPECIFICATIONS ON-SITE AT ALL TIMES.
14. THE CONTRACTOR SHALL CALL DIG LINE (800-342-1585) TO LOCATE ALL EXISTING UTILITIES ON EACH SEWER LINE SEGMENT AT LEAST ONE WEEK PRIOR TO EXCAVATION OF THAT SEWER LINE SEGMENT.

15. THE CONTRACTOR SHALL NOTIFY THE CITY OF LEWISTON AND THE LEWISTON ORCHARDS IRRIGATION DISTRICT (LOID) A MINIMUM OF SEVENTY-TWO (72) HOURS PRIOR TO A PLANNED DISRUPTION OF SEWER OR WATER SERVICE.
16. CONTRACTOR SHALL PROTECT ALL EXISTING MONUMENTS, SURVEY MARKERS, STREET SIGNS, UTILITIES, IRRIGATION LINES, PAVEMENT, TREES, FENCES, AND ANY OTHER IMPORTANT OBJECTS ON OR ADJACENT TO THE JOB SITE FROM DAMAGE AND REPAIR OR REPLACE DAMAGED FACILITIES AS REQUIRED BY THE OWNER AND THE PROJECT ENGINEER.
17. THE CONTRACTOR SHALL VERIFY ALL DIMENSIONS BEFORE STARTING WORK AND SHALL IMMEDIATELY NOTIFY THE PROJECT ENGINEER OF ANY DISCREPANCIES.
18. CONTRACTOR SHALL PROVIDE THE PROJECT ENGINEER WITH ONE COPY OF REDLINED AS-BUILT DRAWINGS PRIOR TO PROJECT ACCEPTANCE.
19. THE CONTRACTOR SHALL NOTIFY THE CITY OF LEWISTON AND THE PROJECT ENGINEER A MINIMUM OF FORTY-EIGHT (48) HOURS PRIOR TO ANY SEWER PIPELINE TESTING, TV WORK AND THE POURING OF CONCRETE COLLARS.
20. THE CONTRACTOR WILL BE RESPONSIBLE FOR ALL TRAFFIC CONTROL REQUIREMENTS AS REQUIRED BY THE CITY OF LEWISTON, NEZ PERCE COUNTY OR THE IDAHO DEPARTMENT OF TRANSPORTATION.
21. CONTRACTOR IS RESPONSIBLE FOR COMPLIANCE WITH ALL APPLICABLE SAFETY LAWS OF ANY JURISDICTIONAL BODY INCLUDING, BUT NOT LIMITED TO, SAFE WORKING PRACTICES WITHIN AND AROUND THE CONSTRUCTION AREA. IN ADDITION, JURISDICTIONAL AGENCIES, THE OWNER AND THE PROJECT ENGINEER SHALL NOT BE RESPONSIBLE FOR ENFORCING SAFETY REGULATIONS.
22. CONTRACTOR IS REQUIRED TO PAY FOR ALL COMPACTION TESTING, INCLUDING NUCLEAR DENSITY TESTING OF THE SUBGRADE, SUBBASE, BASE COURSE AND ASPHALT, AND THE COST ASSOCIATED WITH PROCTORS FOR THE BASE COURSE MATERIAL AND ASPHALT PAVEMENT. TESTING SHALL BE CONDUCTED BY AN INDEPENDENT THIRD PARTY.
23. THE SEWER COLLECTION SYSTEM IS THE CITY OF LEWISTON'S ONLY MEANS OF CONVEYING DOMESTIC WASTEWATER FROM INDIVIDUAL PRIVATE RESIDENCES TO THE WASTEWATER TREATMENT FACILITY. IMPAIRING THE OPERATIONAL CAPABILITIES OF THIS COLLECTION SYSTEM WILL RESULT IN DISRUPTION OF SEWER DISCHARGE FROM THE INDIVIDUAL SEWER SYSTEM USERS IN THE CITY.
24. CONDUCT WORK IN A MANNER THAT WILL NOT IMPAIR THE OPERATIONAL CAPABILITIES OF ESSENTIAL ELEMENTS OF THE COLLECTION SYSTEM.
25. LIMIT THE DURATION OF COLLECTION SYSTEM DISRUPTION TO INDIVIDUAL USERS TO A SINGLE DAY DURING APPROVED WORK HOURS.
26. THE COLLECTION SYSTEM IS CONSIDERED OPERATIONAL WHEN ALL INDIVIDUAL USERS CAN FLOW SEWAGE FROM THE RESIDENCE TO THE WASTEWATER TREATMENT FACILITY.
27. NO CITY COLLECTION SYSTEM USER WILL BE WITHOUT SEWER SERVICE LONGER THAN PERMITTED WORK HOURS OR 10 HOURS IN ANY GIVEN DAY BETWEEN THE HOURS OF 8:00 AM AND 6:00 PM. IF CONSTRUCTION REQUIRES LONGER DISRUPTION OF SERVICE THE CONTRACTOR WILL COORDINATE WITH THE CITY AND ENGINEER 24 HOURS IN ADVANCE. THE CONTRACTOR WILL INSTALL TEMPORARY FACILITIES TO PROVIDE SEWER SERVICE TO INDIVIDUAL RESIDENCES DURING NON-PERMITTED WORK HOURS.
28. GROUNDWATER MAY BE ENCOUNTERED DURING CONSTRUCTION. IT IS THE CONTRACTORS RESPONSIBILITY TO DEWATER THE TRENCH DURING CONSTRUCTION PER ISPMC SECTION 205.
29. THE CONTRACTOR MUST FOLLOW THE TRAFFIC CONTROL PLAN AT ALL TIMES, INCLUDING IF WORK IS OCCURRING IN MORE THAN ONE LOCATION WITHIN THE PROJECT AREA.
30. LOCAL ACCESS TO INDIVIDUAL DRIVEWAYS CANNOT BE BLOCKED FOR MORE THAN EIGHT (8) CONSECUTIVE HOURS. CONTRACTOR TO COORDINATE BLOCKING OF ACCESS WITH HOMEOWNERS.

31. THE CONTRACTOR SHALL BE RESPONSIBLE FOR COORDINATING WITH PROPERTY OWNERS AND UTILITY COMPANIES DURING CONSTRUCTION.
32. OWNER TO PROVIDE CONSTRUCTION SURVEY CONSISTING OF ONE (1) TIME PLACEMENT OF STAKES FOR STRUCTURE RIM AND INVERT ELEVATIONS, SUBGRADE AND TOP OF GRAVEL VERIFICATION IN 50-FOOT INTERVALS ALONG THE ALIGNMENT WITH 25-FOOT INTERVALS AT INTERSECTIONS, AS WELL AS REFERENCE AND RESET MONUMENTS AS NECESSARY. CONTRACTOR TO SUPPLY MATERIALS FOR MONUMENTS. ALL OTHER SURVEYING NECESSARY TO COMPLETE THE WORK SHALL BE THE RESPONSIBILITY OF THE CONTRACTOR.

**EROSION AND SEDIMENT CONTROL NOTES:**

1. PRIOR TO START OF CONSTRUCTION, A STORM WATER POLLUTION PREVENTION PLAN (SWPPP) SHALL BE PREPARED BY THE CONTRACTOR. ALL CONTRACTORS WILL BE REQUIRED TO ADOPT AND FOLLOW ALL REQUIREMENTS SET FORTH IN THE SWPPP. THE SWPPP WILL BE SUBMITTED TO THE OWNER AND ENGINEER FOR REVIEW.
2. CONTRACTOR SHALL BE RESPONSIBLE FOR PROPER INSTALLATION AND MAINTENANCE OF ALL EROSION AND SEDIMENT CONTROL MEASURES/STORMWATER BEST MANAGEMENT PRACTICES (BMP'S) IN ACCORDANCE WITH LOCAL, STATE, AND FEDERAL REQUIREMENTS.
3. THE IMPLEMENTATION OF THESE EROSION AND SEDIMENT CONTROL MEASURES INCLUDING CONSTRUCTION, MAINTENANCE, REPLACEMENT AND UPGRADING OF THIS PLAN IS THE RESPONSIBILITY OF THE CONTRACTOR UNTIL ALL PROJECT CONSTRUCTION IS COMPLETED AND APPROVED BY THE OWNER. THE OWNER SHALL BE RESPONSIBLE FOR ALL MAINTENANCE AFTER THE PROJECT IS APPROVED.
4. ALL EROSION CONTROL BMP'S SHALL BE INSTALLED PRIOR TO THE START OF ANY PROJECT CONSTRUCTION OR EARTH DISTURBING ACTIVITIES AND SHOULD REMAIN IN PLACE UNTIL ALL DISTURBED/EXPOSED AREAS HAVE BEEN STABILIZED AND/OR REVEGETATED.
5. ALL STORMWATER, EROSION AND SEDIMENT CONTROL FACILITIES SHALL BE REGULARLY INSPECTED AND MAINTAINED BY THE CONTRACTOR DURING CONSTRUCTION.
6. WORK ACTIVITIES SHALL TAKE PLACE IN GRADING LIMITS AS SHOWN ON THESE PLANS. CONTRACTOR SHALL PRESERVE NATURAL LANDSCAPE OUTSIDE OF CONSTRUCTION LIMITS.
7. DURING CONSTRUCTION CONTRACTOR SHALL SPRINKLE ALL DISTURBED AREAS AS NECESSARY FOR DUST ABATEMENT.
8. CONTRACTOR SHALL STOCKPILE TOPSOIL REMOVED DURING CONSTRUCTION ONSITE AND REUSE/DISTRIBUTE OVER GRADED AREAS PRIOR TO RESEEDING.
9. ALL SLOPE AND OUTLET PROTECTION SHALL BE INSTALLED IMMEDIATELY AFTER GRADING.
10. TOPSOILING AND RESEEDING OF ALL DISTURBED AREAS TO BE COMPLETED IMMEDIATELY AFTER GRADING USING A NATIVE SEED MIXTURE.

**ROCK EXCAVATION:**

1. CONTROLLED BLASTING MAY BE CONSIDERED IN UNDEVELOPED AREAS OF THE ALIGNMENT ON A CASE BY CASE BASIS AND MUST BE PERFORMED IN STRICT ACCORDANCE WITH CITY CODE, LEWISTON FIRE DEPARTMENT STANDARDS, AND THE MOST RECENT EDITION OF ISPMC. CONTACT THE LEWISTON FIRE DEPARTMENT FOR BLASTING PERMITTING INFORMATION AT (208) 743-3554. ROCK BLASTING IS ALLOWED FROM MH 4222 TO MH 4253.
2. A PRELIMINARY GEOTECHNICAL INVESTIGATION WAS COMPLETED USING A 1.5-INCH DIAMETER HYDRAULIC HAMMER PROBE TO DETERMINE THE DEPTH TO BEDROCK. THE DEPTH TO WEATHERED ROCK, THE DEPTH TO REFUSAL, AND THE TESTING LOCATIONS ARE INDICATED ON THE DRAWINGS. THE INDICATED DEPTHS ARE CONSIDERED APPROXIMATE AND DO NOT NECESSARILY REPRESENT THE ACTUAL BEDROCK PROFILE.

Path: E:\projects\111\lewiston\_1610020 Phase I\CA\B\B C-2.dwg File Name: AB C-2.dwg Plot Date: 11/20/2019 5:08 PM Doc#

NO.	REVISION	BY	DATE	DESIGN

**RECORD DRAWING**

THESE RECORD DRAWINGS HAVE BEEN PREPARED BASED IN PART ON INFORMATION PROVIDED BY OTHERS

THIS DRAWING WAS PREPARED ONLY FOR THE PROJECT AND SITE SPECIFICALLY IDENTIFIED HEREON AND IS NOT TO BE USED ELSEWHERE



ENGINEERING AND ENVIRONMENTAL SOLUTIONS

111 MAIN ST. SUITE 175  
LEWISTON, IDAHO 83501  
208.780.3990

IDAHO OFFICES  
BOISE · LEWISTON · COEUR D'ALENE



**EAST ORCHARDS SEWER EXPANSION**

**LEWISTON, IDAHO**


GENERAL NOTES

VERIFY SCALE	181.0020
BAR IS ONE INCH ON FULL SIZE DRAWING	11/19/2019
PROJECT :	181.0020
DATE :	11/19/2019
DRAWING NO.	G-2




**LINE LEGEND**

SECTION LINE (SURVEYED)	----
EXISTING DEED OR LOT LINE (SURVEYED)	----
CENTERLINE	----
RIGHT OF WAY	----
EASEMENT	----
SILT FENCE	— S — S — S — S — S —
EXISTING BUILDING	
EXISTING EDGE OF CONCRETE	----
EXISTING EDGE OF PAVEMENT	— EP — EP — EP — EP —
EXISTING EDGE OF PAVEMENT	— EP — EP — EP — EP —
EXISTING EDGE OF GRAVEL	— EG — EG — EG — EG —
PROPOSED EDGE OF GRAVEL	— EG — EG — EG — EG —
EXISTING UNDERGROUND GAS LINE	— G — G — G — G —
EXISTING WATER LINE	— W — W — W — W —
EXISTING SEWER LINE	— SS — SS — SS — SS —
EXISTING SERVICE (WATER,GAS)	----
PROPOSED SEWER LINE	— SS — SS — SS — SS —
EXISTING STORM DRAIN	— SD — SD — SD — SD —
EXISTING OVERHEAD POWER	— OHP —
EXISTING UNDERGROUND POWER	— UP —
EXISTING UNDERGROUND TELEPHONE	— UT —
EXISTING FLOW LINE	— < — < — < — < —
EXISTING PRESSURE IRRIGATION LINE	— PIRR — PIRR — PIRR —
EXISTING GRAVITY IRRIGATION LINE	— IRR — IRR — IRR —
EXISTING FIBER OPTIC	— UGFO —
EXISTING CHAIN LINK FENCE	— O — O — O — O — O — O —
EXISTING WOOD FENCE	— □ — □ — □ — □ — □ —
EXISTING VINYL FENCE	— X — X — X — X — X —
EXISTING WIRE FENCE	— X — X — X — X — X —
EXISTING 1' CONTOUR	— 2601 —
EXISTING 5' CONTOUR	— 2600 —
EXISTING DRAINAGE PIPE	
EXISTING DRAINAGE PIPE	

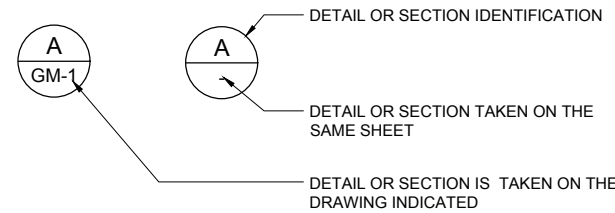

**AT TITLE**

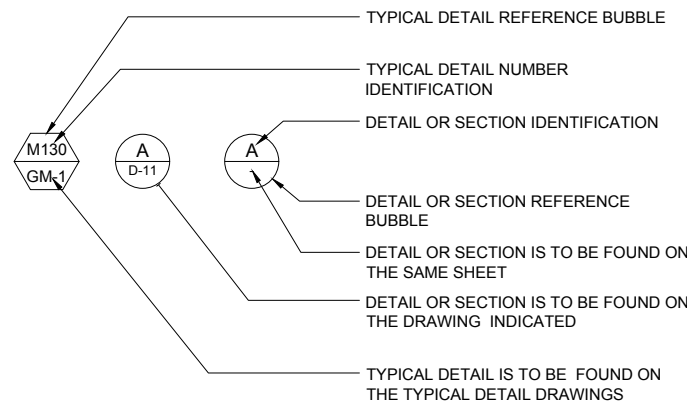


**AT CROSS REFERENCE**

**DRAWING CROSS REFERENCE**



**CROSS SECTION**

**EQUIPMENT DESIGNATION LEGEND**

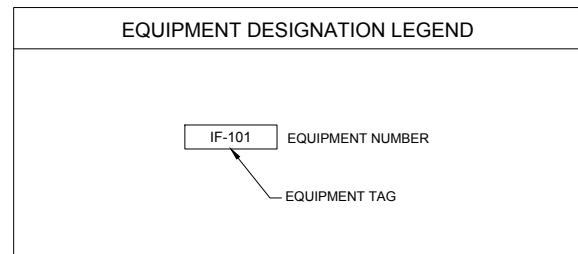


**PIPE MATERIAL SCHEDULE**

ABBREV.	SERVICE	FITTINGS
B1	BLACK IRON PIPE	BLACK IRON, CLASS 300, ASTM 197, A 197M, NPT
C1	CONCRETE PIPE	NONE
C6	HUBLESS CAST IRON PIPE	CAST IRON, ASTM A 74
C7	HUB AND SPIGOT CAST IRON SOIL PIPE	CAST IRON, ASTM A 74
CU1	COPPER, SOFT TEMPERED, TYPE "K"	COPPER, SOLDERED JOINTS
CU2	COPPER, HARD TEMPERED, TYPE "L"	COPPER, SOLDERED JOINTS
D1	DUCTILE IRON, AWWA C150/151, PC150, CEMENT MOTAR LINED, RESTRAINED	DUCTILE IRON, AWWA C110, CL 150
D2	DUCTILE IRON, AWWA C150/151, PC150, CEMENT MOTAR LINED, UNRESTRAINED	DUCTILE IRON, AWWA C110, CL 150
D3	DUCTILE IRON, AWWA C150/151, PC 350	DUCTILE IRON, AWWA C110, CL 350
D4	DUCTILE IRON, AWWA C150/151, PC150, GLASS LINED	DUCTILE IRON, AWWA C110, CL 150
P1	POLYVINYL CHLORIDE, SCH. 80	PVC SCH 80, SOLVENT WELD SOCKET
P2	POLYVINYL CHLORIDE, SCH. 40	PVC SCH 40, SOLVENT WELD SOCKET
P3	POLYVINYL CHLORIDE, SDR 35, ASTM 3034 (PS46, ASTM F679)	POLYVINYL CHLORIDE, SDR 35 ASTM 3034
P4	POLYVINYL CHLORIDE, AWWA C900, DR18	DUCTILE IRON, AWWA C110, CL150
P5	CHLORINATED POLYVINYL CHLORIDE, SCH. 80	CPVC, SCH. 80, SOLVENT WELD SOCKET
P7	HIGH DENSITY POLYPROPYLENE, MIN. SDR 7.3	HDPE
P8	NALGENE 980 BRAIDED VIYNL TUBING, OR EQUAL	
P9	POLYVINYL CHLORIDE, PIP 100 PSI	PVC PIP100 PSI
P10	HDPE IPS SDR 32.5 ASTM D335 PE 3408	HDPE IPS SDR 32.5 ASTM D3350 P3408
P11	HDPE SINGLE WALL CORRUGATED PERFORATED PLASTIC DRAIN PIPE ASTM-F-667-"C"	NONE
P12	HDPE, AWWA C901, DR9	HDPE
S1	STEEL, SCH. 40 GALVANIZED	THREADED OR FLANGED, GALVANIZED
S2	WELDED STEEL, AWWA C200, MORTAR LINED AND COATED	STEEL, AWWA C208, MORTAR LINED
S3	WELDED STEEL, AWWA C200, MORTAR LINED AND EPOXY COATED	STEEL, AWWA C208, MORTAR LINED
S4	STAINLESS STEEL, TYPE 304L OR 316L, SCH. 5	STAINLESS STEEL
S5	STAINLESS STEEL, TYPE 304L OR 316L, SCH. 10	STAINLESS STEEL
S6	STAINLESS STEEL, TYPE 304L OR 316L, SCH. 40	STAINLESS STEEL
S7	STAINLESS STEEL, ALLOY 20	STAINLESS STEEL, ALLOY 20
S8	STEEL, ASTM A106 OR 53, SCH. 80, SEAMLESS, BLACK	THREADED, SOCKET, BUTT-WELD OR FLANGED W/ AMMONIA UNIONS
S9	STEEL, ASTM 53, SCH. 40, BLACK, NATURAL GAS	MALLEABLE 150 PSI THRD. 2-INCH OR SMALLER, GREATER THAN 2-INCH WELD
S10	STEEL, ASTM 53, SCH. 10	THREADED, SOCKET, BUTT-WELD OR FLANGED W/ AMMONIA UNIONS
S11	CORRUGATED METAL PIPE	NONE

**PIPE SCHEDULE**


ABBREV.	SERVICE	TEST METHOD	TEST PRESSURE (PSI)
AS	AIR SCOUR OR AIR AGITATION	AM	15
CD	CENTRATE DRAIN	GR	5-6.5
CON	CONDUIT	AM	5
DR	DRAIN	AM	5
EFF	EFFLUENT	HH	150
FE	FILTER EFFLUENT	HH	150
HWS	HOT WATER SUPPLY	HH	100
IRR	IRRIGATION WATER	HH	100
ML	MIXED LIQUOR	HH	150
OF	OVERFLOW	LH	20
PA	PLANT AIR	HH	150
PC	PRESSURE CENTRATE	HH	150
PR	PRESSURE REUSE	HH	150
PS	PRESSURE SEWER	HH	150
PW	POTABLE WATER	HH	150
RAS	RETURN ACTIVATED SLUDGE	HH	150
RW	RAW WATER	GR	6.5
SA	SAMPLE	HH	100
SC	SUCTION CENTRATE	HH	150
SD	STORM DRAIN	GR	6.5
SE	SECONDARY EFFLUENT	HH	150
SH	SODIUM HYPOCHLORITE	HH	125
SS	SANITARY SEWER	GR	5-6.5
ST	SODIUM THIOSULFATE	HH	125
UW1	UTILITY WATER TYPE 1 (POTABLE)	HH	150
UW2	UTILITY WATER TYPE 2 (NON-POTABLE)	HH	150
VNT	VENT	AM	15
WAS	WASTE ACTIVATED SLUDGE	HH	150

**PIPE DESIGNATION LEGEND**

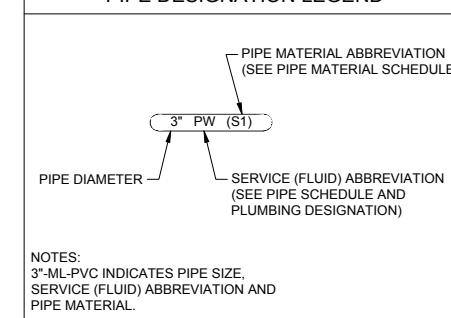

Path: G:\Projects\11-Lewiston\_1610020 Phase 1\CA\B\G-3.dwg File Name: AB G-3.dwg Plot Date: 11/20/2019 5:10 PM Duce

NO.	REVISION	BY	DATE	DESIGN
				DRAWN
				CHECKED
				APPROVED

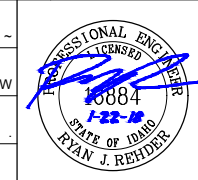

**ENGINEERING AND ENVIRONMENTAL SOLUTIONS**  
 111 MAIN ST. SUITE 175  
 LEWISTON, IDAHO 83501  
 208.780.3990  
 IDAHO OFFICES  
 BOISE · LEWISTON · COEUR D'ALENE

**EAST ORCHARDS SEWER EXPANSION**  
**LEWISTON, IDAHO**  
 LINE LEGEND / PIPE SCHEDULE

VERIFY SCALE	BAR IS ONE INCH ON FULL SIZE DRAWING
PROJECT :	181.0020.00
DATE :	1/22/2018
DRAWING NO.	

LEGEND AND SYMBOLS

	BOLLARD
	EXISTING MANHOLE
	NEW MANHOLE
	EXISTING WATER MANHOLE
	EXISTING WATER METER
	EXISTING WATER SERVICE
	EXISTING WATER VALVE
	EXISTING TREE, BUSH
	WATER SURFACE ELEVATION
	NEW CLEANOUT
	EXISTING UTILITY POLE
	UTILITY POLE ANCHOR
	EXISTING FIRE HYDRANT
	EXISTING LIGHT POLE
	EXISTING ELECTRICAL BOX
	EXISTING GAS METER/RISER
	EXISTING POWER METER
	EXISTING STORM MANHOLE
	EXISTING STORM DRAIN CATCH BASIN
	EXISTING MONITORING WELL
	EXISTING TELEPHONE RISER
	EXISTING TELEPHONE JUNCTION BOX
	FINISHED ELEVATION
	EXISTING ELEVATION
	BREAK LINE
	DRAINAGE FLOW OR PIPE FLOW DIRECTION
	SURVEY MONUMENT
	BENCH MARK (BM)
	REVISION NUMBER
	BOREHOLE
	SURVEY CONTROL POINT
	KEY NOTE
	COORDINATE NUMBER
	CONCRETE (PLAN AND SECTION)
	EARTH
	GRAVEL/DRAINROCK/AGGREGATE BASE
	AC PAVEMENT
	REVISION CLOUD

TYPE OF JOINT OR COUPLER	THREE LINE PIPE
FLANGED JOINT	
MECHANICAL JOINT	
WELDED JOINT	
PUSH-ON JOINT	
RESTRAINED PUSH-ON JOINT	
SCREWED OR GLUED JOINT	
CONCRETE OR CLAY PIPE JOINT	
GROOVED COUPLING	
RESTRAINED FLANGED COUPLING ADAPTER	
FLEXIBLE COUPLING	
RESTRAINED FLEXIBLE COUPLING FOR STEEL PIPE	
RESTRAINED FLEXIBLE COUPLING FOR FLANGED PIPE	
DISMANTLING JOINT	
EXPANSION JOINT	
PIPE SUPPORT (CALL OUT DETAIL)	


Schematic Valves	
	AIR VACUUM AND AIR RELEASE ASSEMBLY
	ANGLE
	BACK-PRESSURE
	BALL
	BALL CHECK
	BUTTERFLY
	CHECK
	DIAPHRAGM
	GATE
	GLOBE
	MULTIPORT - 3 WAY
	NEEDLE
	PLUG
	PRESSURE RELIEF
	SOLENOID
	PRESSURE REDUCING
	GATE VALVE, BURIED WITH VALVE BOX
	BUTTERFLY VALVE, BURIED WITH VALVE BOX
	ECCENTRIC PLUG VALVE, BURIED WITH VALVE BOX
	PRESSURE TRANSDUCER
	PRESSURE SWITCH
	CHECK CHANGE IN PIPE MATERIAL
	MOTOR OPERATOR FOR VALVES (P = PNEUMATIC)
	MOTOR OPERATOR FOR VALVES (M = ELECTRIC)
	PRESSURE GAUGE
	FLOW TUBE
	MAGNETIC METER
	PROPELLER METER
	FLOW METER

	ROTAMETER (SIDE)
	ROTAMETER (TOP/BOTTOM)
	INJECTOR OR EDUCATOR
	PIPE SUPPORT (IN PLAN)
	PULSATION DAMPENERS
	BACK FLOW PREVENTOR
	FLANGED FITTING
	MECHANICAL-TYPE FITTING (GROOVED)
	SCREWED, WELDED, SOCKET-WELD, BELL AND SPIGOT OR HUBLESS FITTING
	STOP GATE
	SLIDE GATE
	SLUICE GATE
	FIRE HYDRANT
	HUB DRAIN
	FLOOR DRAIN
	FLOOR SINK
	YARD HYDRANT
	PIPE END
	SLEEVE TYPE COUPLING
	FLANGED ADAPTER
	MECHANICAL TYPE COUPLING
	FLEXIBLE COUPLING
	UNION
	QUICK DISCONNECT COUPLER
	CAPPED END OR PLUGGED END
	BLIND FLANGE
	REDUCER OR INCREASER
	STRAINER
	DRAIN
	AIRGAP

	CENTRIFUGAL OR TURBINE PUMP, OR FAN
	CHEMICAL FEED PUMP
	SUMP PUMP
	MIXER
	MAGNETIC FLOW METER
	SAMPLE TAP
<b>THREE LINE VALVES</b>	
GATE	
BUTTERFLY	
SILENT GLOBE CHECK	
CHECK	
BALL	
PLUG	
FLANGED JOINT	
SOIL PROBE EXPLORATIONS PERFORMED USING A 1.5-INCH DIAMETER SOLID STEM HYDRAULIC-HAMMERED PROBE.	
<ul style="list-style-type: none"> <li>1 GROUND SURFACE</li> <li>2 APPROX. TOP OF BEDROCK (REFUSAL)</li> <li>3 SOIL PROBE LOCATION</li> <li>4 SOIL PROBE NUMBER</li> <li>5 DEPTH OF WEATHERED BEDROCK</li> <li>6 DEPTH OF REFUSAL</li> </ul>	

Path: E:\Projects\11-Lewiston-1810020 Phase I\CA-BAB G-4.dwg File Name: AB G-4.dwg Plot Date: 11/20/2019 5:10 PM Dose

NO.	REVISION	BY	DATE	DESIGN

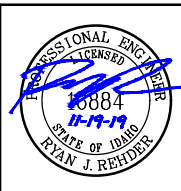

**RECORD DRAWING**

THESE RECORD DRAWINGS HAVE BEEN PREPARED BASED IN PART ON INFORMATION PROVIDED BY OTHERS

THIS DRAWING WAS PREPARED ONLY FOR THE PROJECT AND SITE SPECIFICALLY IDENTIFIED HEREON AND IS NOT TO BE USED ELSEWHERE



ENGINEERING AND ENVIRONMENTAL SOLUTIONS

111 MAIN ST. SUITE 175  
LEWISTON, IDAHO 83501  
208.780.3990

IDAHO OFFICES  
BOISE · LEWISTON · COEUR D'ALENE



**EAST ORCHARDS SEWER EXPANSION**



LEWISTON, IDAHO

LEGEND AND SYMBOLS

VERIFY SCALE	
BAR IS ONE INCH ON FULL SIZE DRAWING	0 1"
PROJECT :	181.0020
DATE :	11/19/2019
DRAWING NO.	G-4



Path: E:\Projects\1810020 Phase I\CA-BAB Lewiston Profiles.dwg File Name: AB Lewiston Profiles.dwg Plot Date: 11/20/2019 4:41 PM Draw

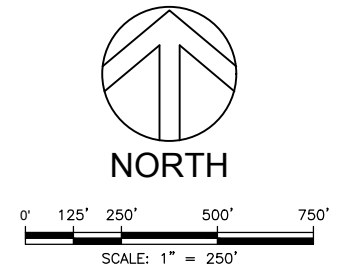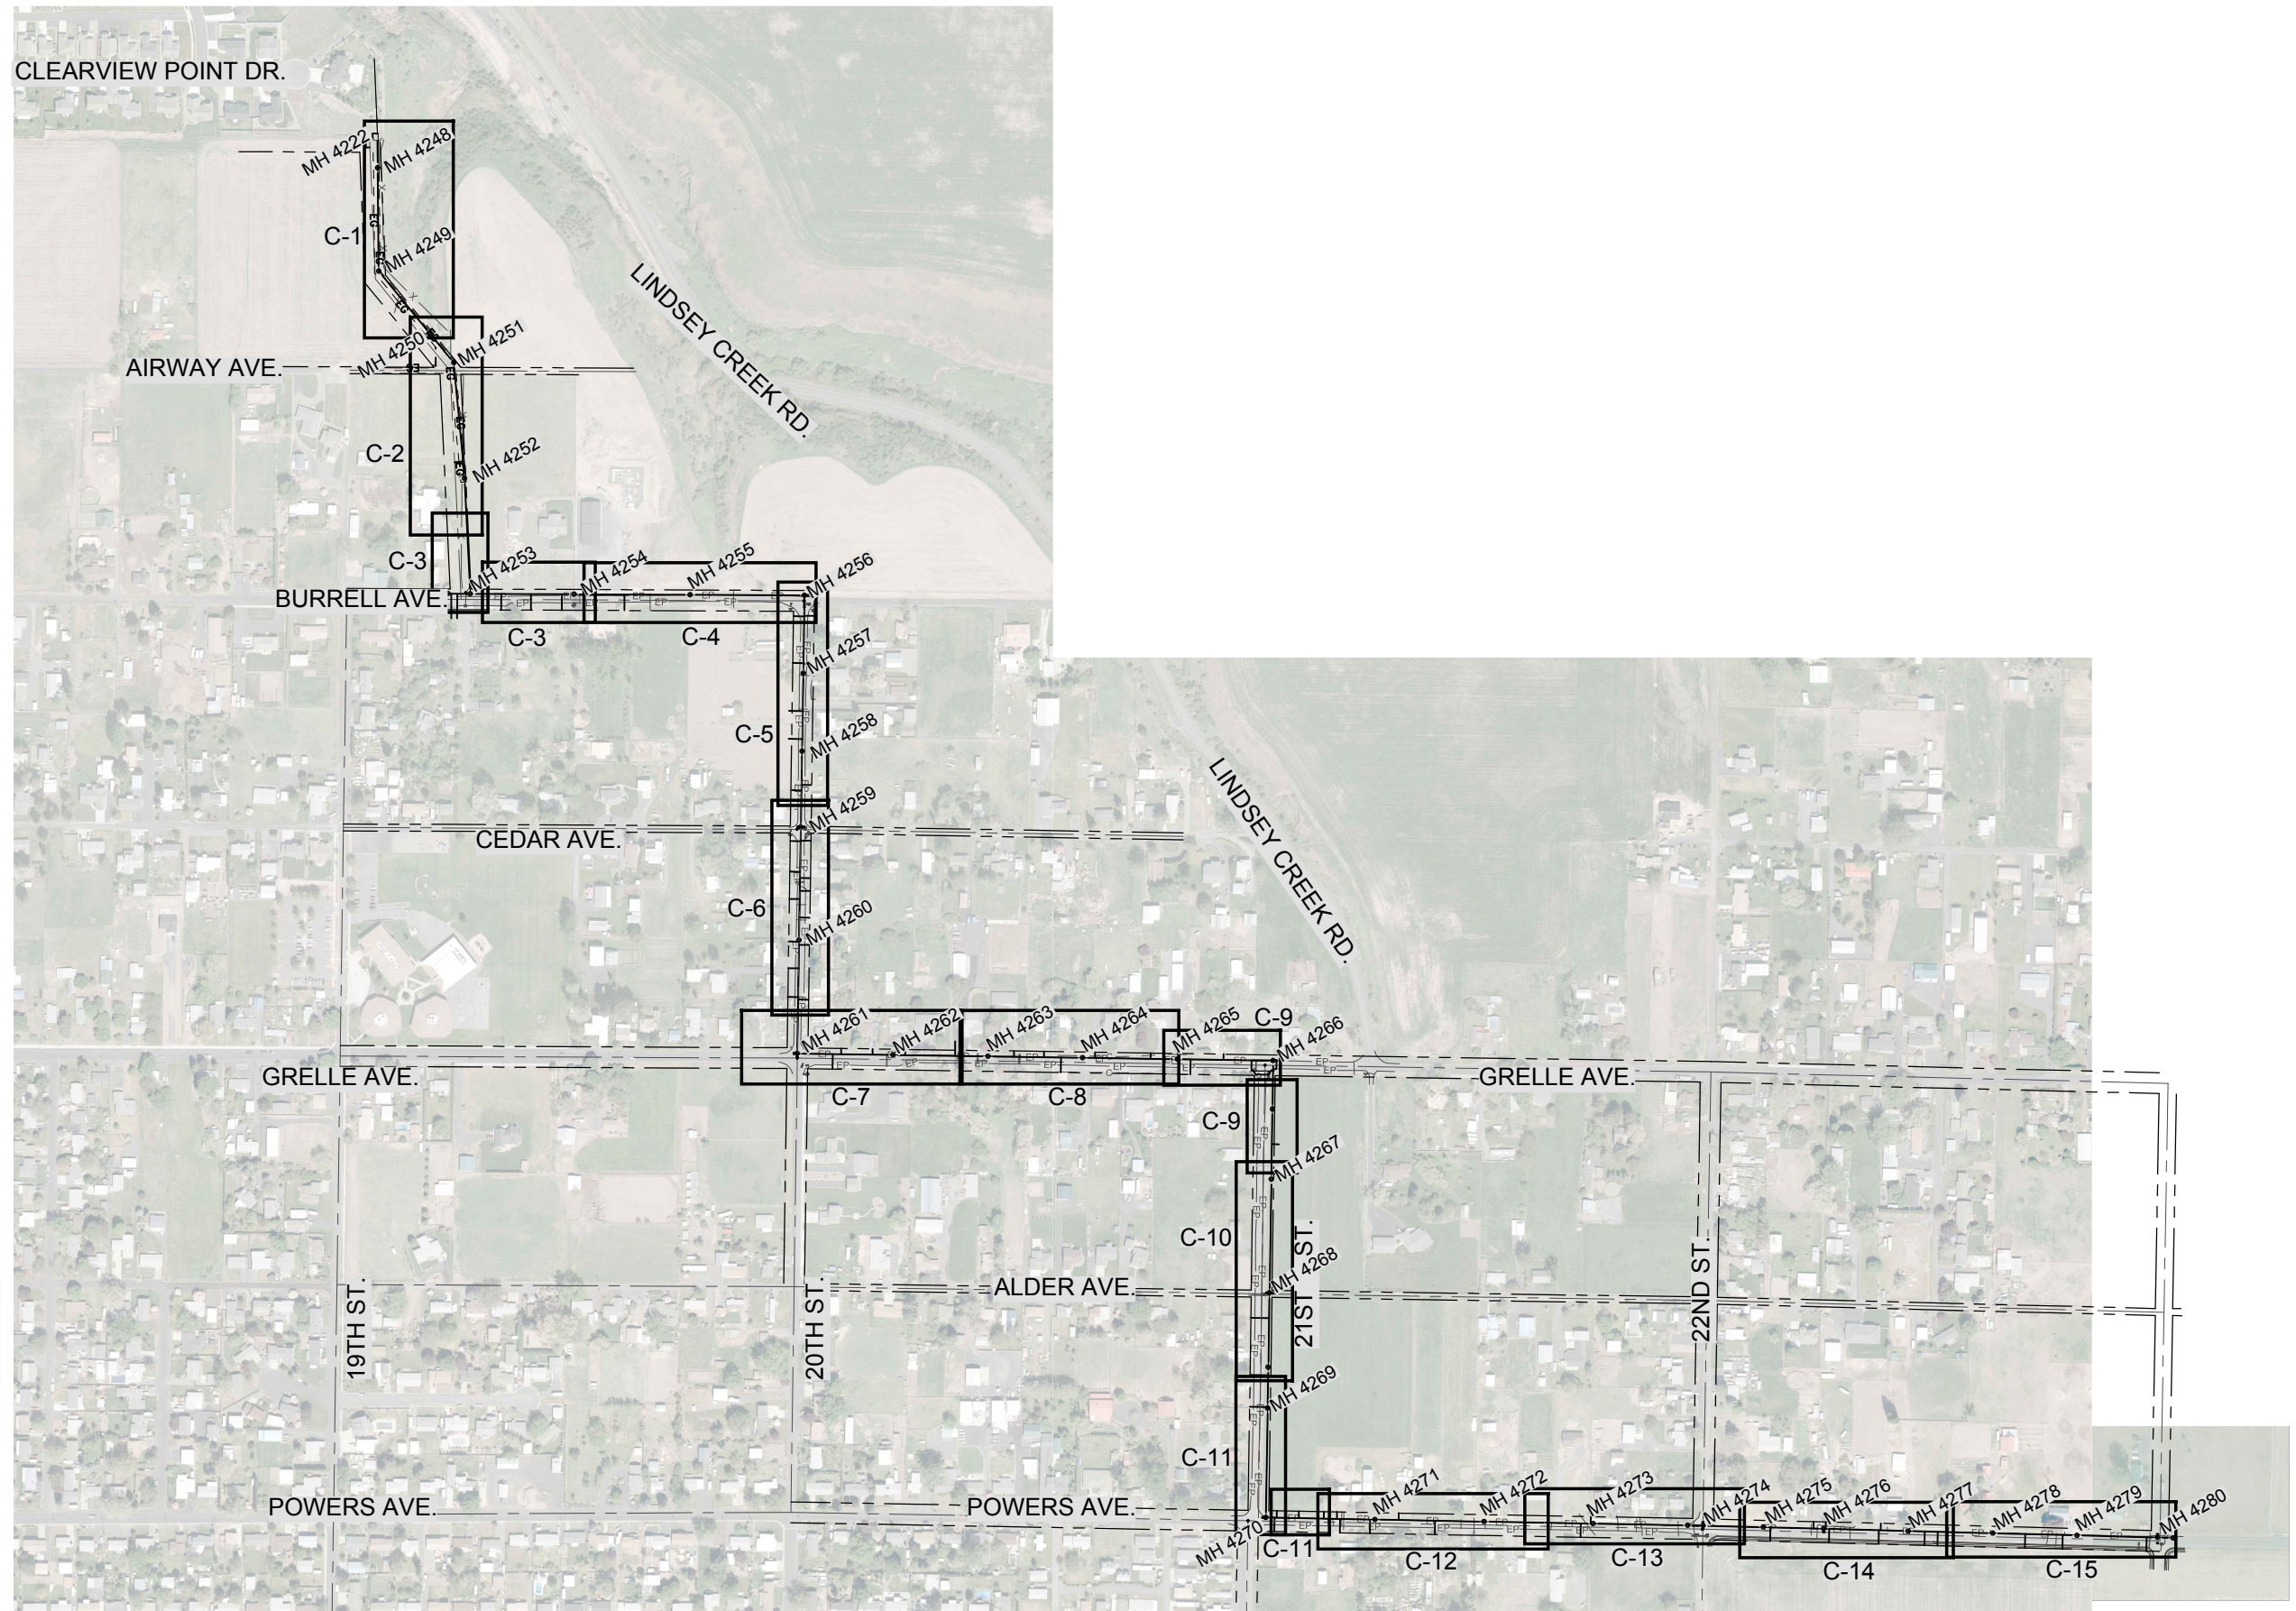

NO.	REVISION	BY	DATE	DESIGN
				LCH
				DRAWN OTW
				CHECKED LMD
				APPROVED



**RECORD DRAWING**  
 THESE RECORD DRAWINGS HAVE BEEN PREPARED BASED IN PART ON INFORMATION PROVIDED BY OTHERS  
 THIS DRAWING WAS PREPARED ONLY FOR THE PROJECT AND SITE SPECIFICALLY IDENTIFIED HEREON AND IS NOT TO BE USED ELSEWHERE




ENGINEERING AND ENVIRONMENTAL SOLUTIONS  
 111 MAIN ST. SUITE 175  
 LEWISTON, IDAHO 83501  
 208.780.3990  
 IDAHO OFFICES  
 BOISE · LEWISTON · COEUR D'ALENE

**EAST ORCHARDS SEWER EXPANSION**  
 LEWISTON, IDAHO


Key Map

VERIFY SCALE	
BAR IS ONE INCH ON FULL SIZE DRAWING	
PROJECT :	181.0020
DATE :	11/19/2019
DRAWING NO.	K-1



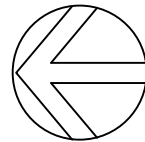

NORTH

 


GENERAL NOTES:

- GRAVITY SEWER PIPE MATERIAL TYPE SHALL BE MINIMUM PVC SDR-35. PIPE DIAMETER TO BE 12-INCHES UNLESS OTHERWISE SHOWN.
- CONTRACTOR TO FIELD VERIFY ALL DIMENSIONS, LOCATIONS, AND ELEVATIONS BEFORE STARTING WORK AND PRIOR TO ORDERING MATERIAL.
- CONTRACTOR TO COMPLY WITH IDAPA 58.01.08.542.07 WHEN WATER MAINS AND POTABLE WATER SERVICE LINES ARE ENCOUNTERED DURING SEWER MAIN AND SERVICE TRENCHING ACTIVITIES.
- PROPERTY LINES SHOWN ON PLAN SHEETS ARE FOR INFORMATIONAL PURPOSES ONLY AND WERE COMPILED FROM VARIOUS SOURCES. IT IS NOT THE INTENT OF THESE DRAWINGS TO BE USED FOR LOCATION OF PROPERTY LINES. MOUNTAIN WATERWORKS ASSUMES NO LIABILITY FOR PROPERTY LINES WHICH MAY NOT BE ACCURATELY SHOWN.
- ALL MANHOLES ARE TO BE CONSTRUCTED IN ACCORDANCE WITH WASTEWATER MANHOLE TYPE 1 DETAIL 7 ON SHT CD-4 UNLESS OTHERWISE SHOWN.
- GEOTECHNICAL BORINGS SHOWN IN APPROXIMATE LOCATIONS FOR INFORMATIONAL PURPOSES.

KEY NOTES:

- CONTRACTOR TO REPLACE EXISTING MH 4222 WITH NEW MANHOLE. INSTALL NEW RING AND COVER AT ELEVATION 1427.67 FT. GRADE TO MATCH THE SURROUNDING AREA.
- EXISTING PIPE IS 10-INCH SDR 35. CONTRACTOR TO STUB OUT PIPE FROM NEW MANHOLE TO CONNECT TO EXISTING PIPE USING ROMAC 501 COUPLING OR EQUAL.
- CONTRACTOR TO REMOVE SECTION OF EXISTING BARBED WIRE FENCE TO ALLOW ACCESS TO MANHOLE.
- ROCK BLASTING IS ALLOWED FROM MH 4222 TO 4253.

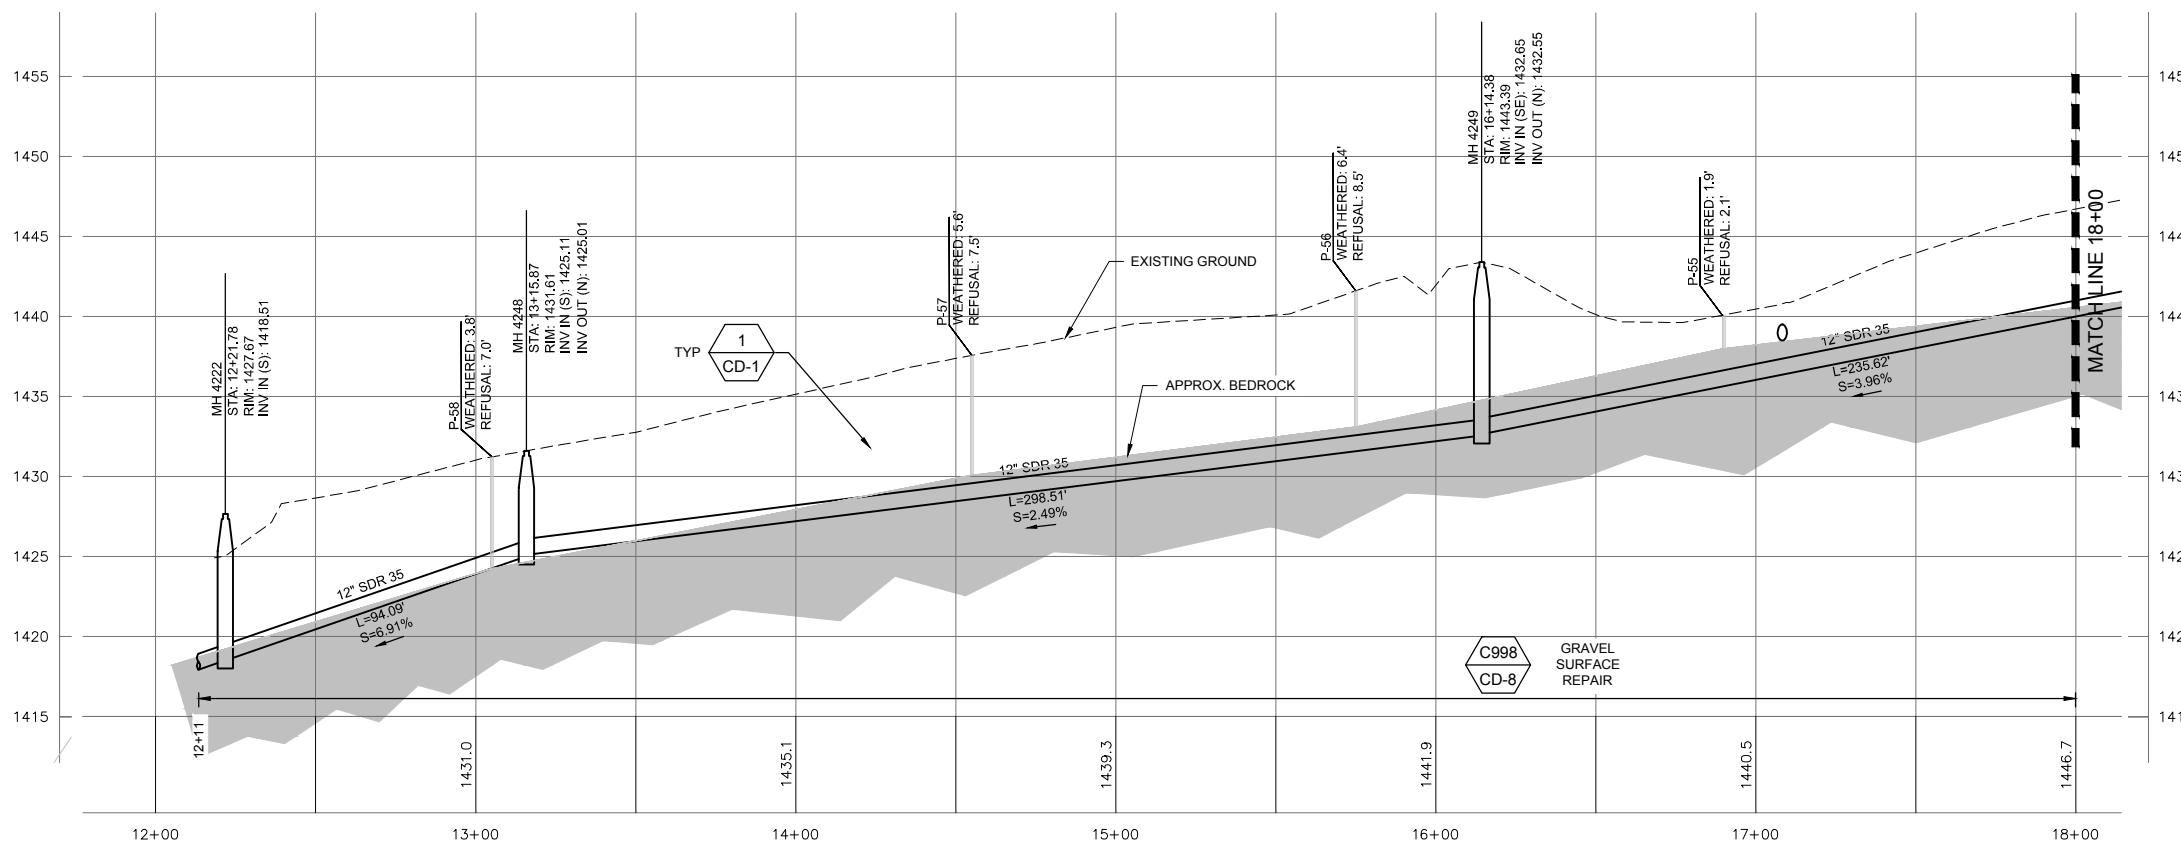

PROFILE STA. 12+00 - 18+00

HORIZ. SCALE: 1" = 30'  
VER. SCALE: 1" = 6'  
(VERIFY PER SHEET SIZE)

Path: E:\projects\1111111111\Phase I\CD\BIB\BIB\Leviston Profiles\_1\_16294\_7632.svs.dwg File Name: AB\Leviston Profiles\_1\_16294\_7632.svs.dwg Pld Date: 11/20/2019 5:01 PM Dice

NO.	REVISION	BY	DATE	DESIGN
				LCH
				DRAWN OTW
				CHECKED LMD
				APPROVED



RECORD DRAWING

THESE RECORD DRAWINGS HAVE BEEN PREPARED BASED IN PART ON INFORMATION PROVIDED BY OTHERS

THIS DRAWING WAS PREPARED ONLY FOR THE PROJECT AND SITE SPECIFICALLY IDENTIFIED HEREON AND IS NOT TO BE USED ELSEWHERE



ENGINEERING AND ENVIRONMENTAL SOLUTIONS

111 MAIN ST. SUITE 175  
LEWISTON, IDAHO 83501  
208.780.3990


IDAHO OFFICES  
BOISE · LEWISTON · COEUR D'ALENE

EAST ORCHARDS SEWER EXPANSION




LEWISTON, IDAHO

STA 12+00 - 18+00

VERIFY SCALE	
BAR IS ONE INCH ON FULL SIZE DRAWING	
PROJECT :	181.0020
DATE :	11/19/2019
DRAWING NO.	C-1

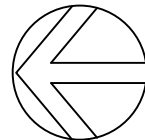

NORTH

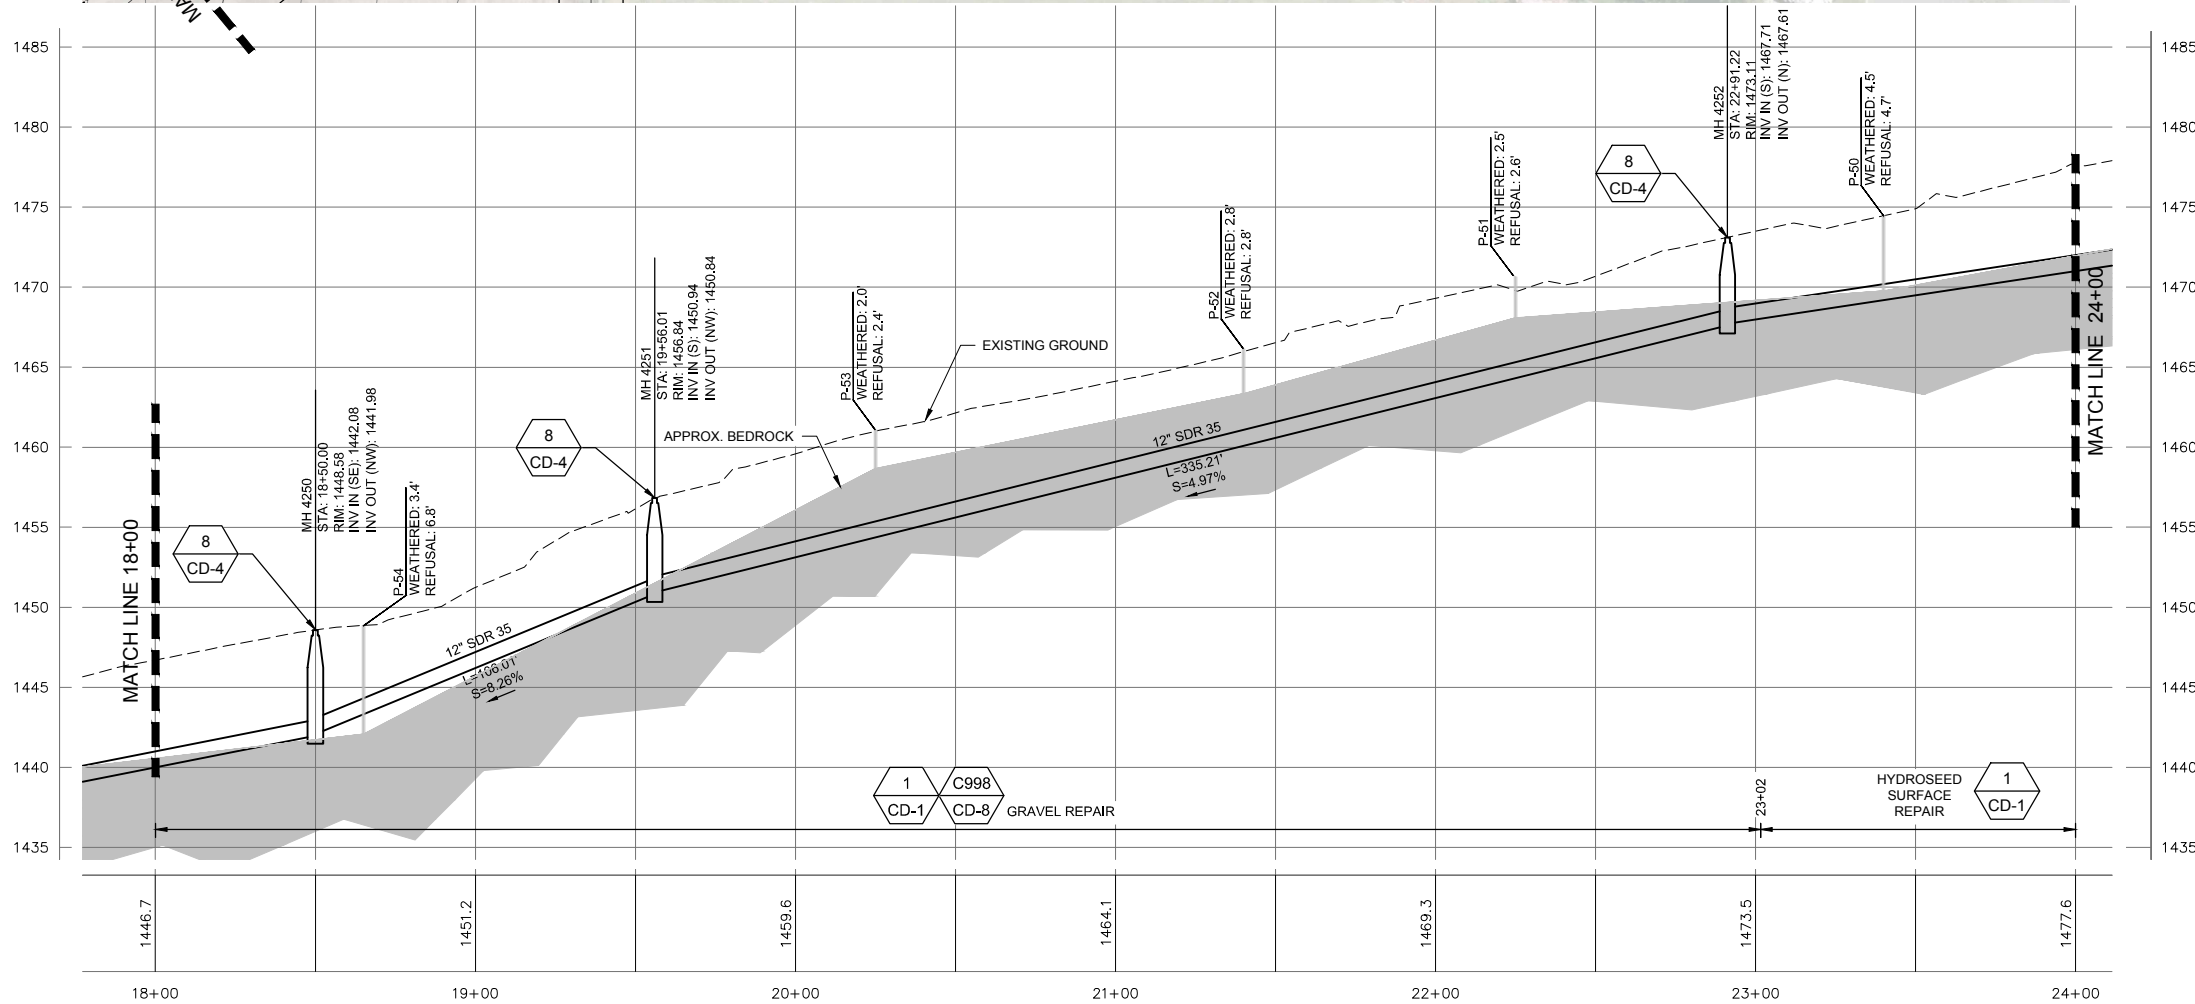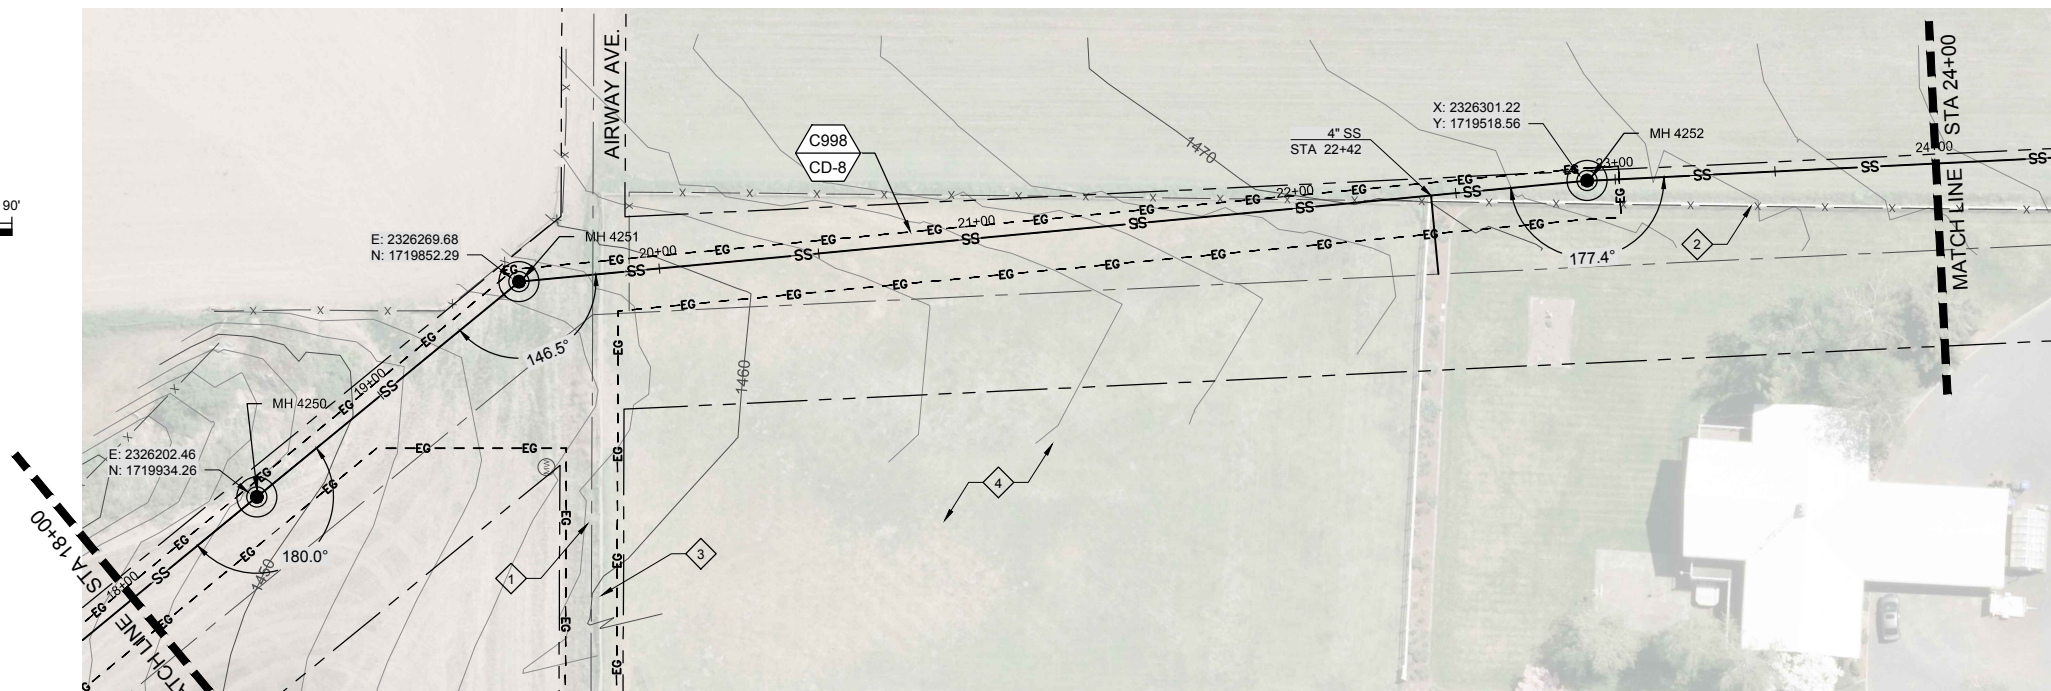 

PROFILE STA. 18+00 - 24+00

HORIZ. SCALE: 1" = 30'  
VER. SCALE: 1" = 6'  
(VERIFY PER SHEET SIZE)

GENERAL NOTES:

- GRAVITY SEWER PIPE MATERIAL TYPE SHALL BE MINIMUM PVC SDR-35. PIPE DIAMETER TO BE 12-INCHES UNLESS OTHERWISE SHOWN.
- CONTRACTOR TO FIELD VERIFY ALL DIMENSIONS, LOCATIONS, AND ELEVATIONS BEFORE STARTING WORK AND PRIOR TO ORDERING MATERIAL.
- CONTRACTOR TO COMPLY WITH IDAPA 58.01.08.542.07 WHEN WATER MAINS AND POTABLE WATER SERVICE LINES ARE ENCOUNTERED DURING SEWER MAIN AND SERVICE TRENCHING ACTIVITIES.
- PROPERTY LINES SHOWN ON PLAN SHEETS ARE FOR INFORMATIONAL PURPOSES ONLY AND WERE COMPILED FROM VARIOUS SOURCES. IT IS NOT THE INTENT OF THESE DRAWINGS TO BE USED FOR LOCATION OF PROPERTY LINES. MOUNTAIN WATERWORKS ASSUMES NO LIABILITY FOR PROPERTY LINES WHICH MAY NOT BE ACCURATELY SHOWN.
- ALL MANHOLES ARE TO BE CONSTRUCTED IN ACCORDANCE WITH WASTEWATER MANHOLE TYPE 1 DETAIL 7 ON SHT CD-4 UNLESS OTHERWISE SHOWN.
- GEOTECHNICAL BORINGS SHOWN IN APPROXIMATE LOCATIONS FOR INFORMATIONAL PURPOSES.

KEY NOTES:

- CONTRACTOR TO LEVEL THE GROUND SURFACE OF AIRWAY AVE. FROM THE END OF ASPHALT TO THE 19TH STREET RIGHT-OF-WAY, APPROXIMATELY 370-FEET. PROVIDE PIT RUN BASE AND GRAVEL OVERLAY IN ACCORDANCE WITH DETAIL C998 ON SHT CD-8
- EXISTING FENCE TO BE RELOCATED BY HOMEOWNER PRIOR TO CONSTRUCTION.
- EXISTING FENCE WITHIN RIGHT-OF-WAY TO BE RELOCATED PRIOR TO CONSTRUCTION.
- POTENTIAL STAGING AREA. CONTACT PROPERTY OWNER ROBERT PRASIL AT (208) 791-2605.
- ROCK BLASTING IS ALLOWED FROM MH 4222 TO MH 4253.

Path: E:\projects\11-Lewiston\_1810020 Phase I\CD\BIB\BIB Lewiston Profiles.dwg File Name: AB\_Lewiston Profiles.dwg Plot Date: 11/20/2019 5:02 PM Draw

NO.	REVISION	BY	DATE	DESIGN
				LCH
				DRAWN OTW
				CHECKED LMD
				APPROVED



RECORD DRAWING

THESE RECORD DRAWINGS HAVE BEEN PREPARED BASED IN PART ON INFORMATION PROVIDED BY OTHERS

THIS DRAWING WAS PREPARED ONLY FOR THE PROJECT AND SITE SPECIFICALLY IDENTIFIED HEREON AND IS NOT TO BE USED ELSEWHERE



ENGINEERING AND ENVIRONMENTAL SOLUTIONS

111 MAIN ST. SUITE 175  
LEWISTON, IDAHO 83501  
208.780.3990

IDAHO OFFICES  
BOISE · LEWISTON · COEUR D'ALENE

EAST ORCHARDS SEWER EXPANSION


LEWISTON, IDAHO

STA 18+00 - 24+00



VERIFY SCALE	
BAR IS ONE INCH ON FULL SIZE DRAWING	
PROJECT :	181.0020
DATE :	11/19/2019
DRAWING NO.	C-2





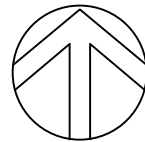

NORTH

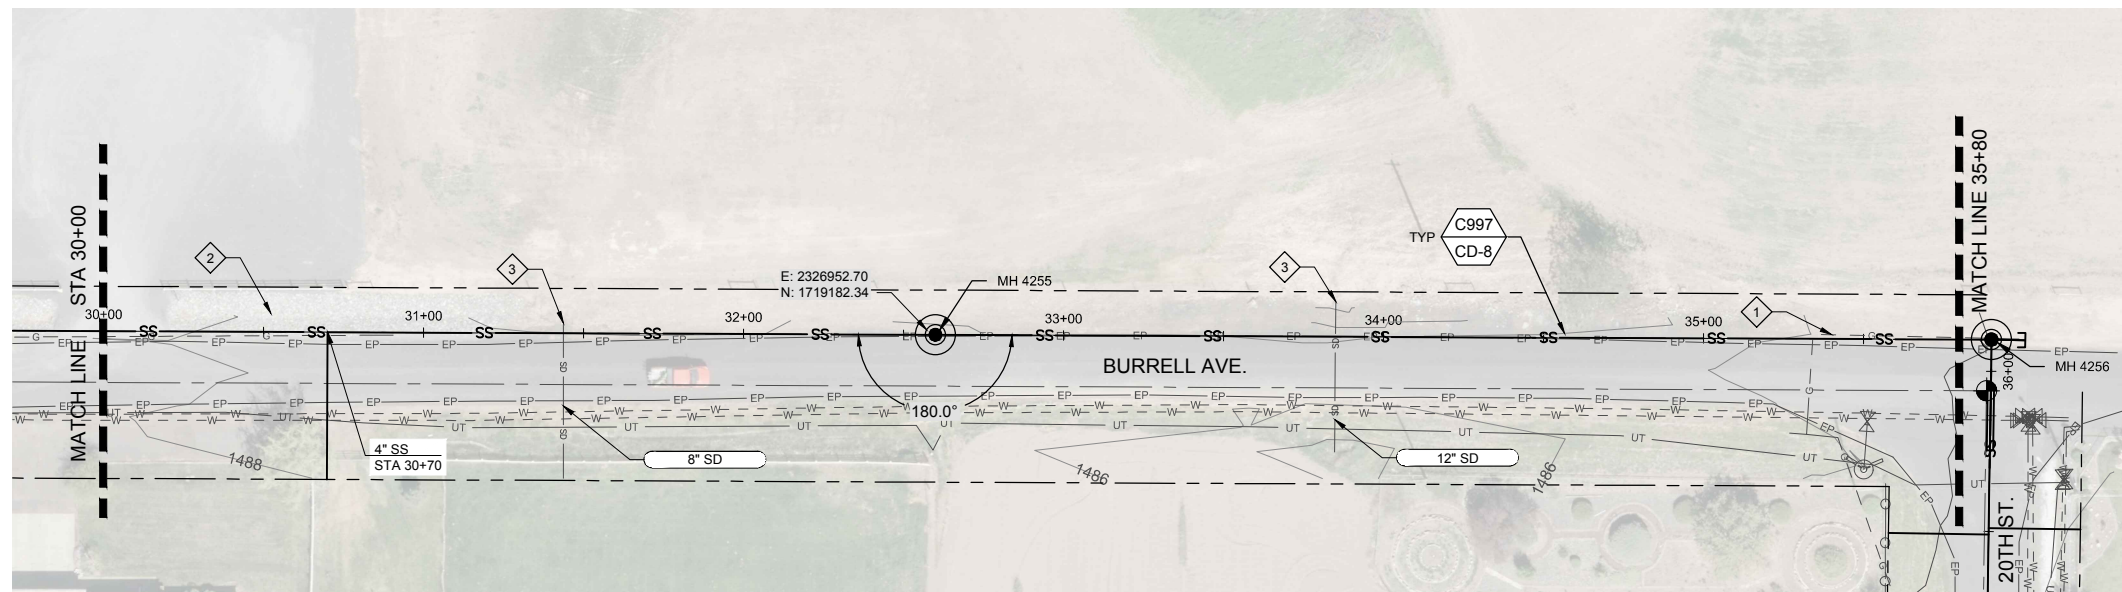 


GENERAL NOTES:

- GRAVITY SEWER PIPE MATERIAL TYPE SHALL BE MINIMUM PVC SDR-35. PIPE DIAMETER TO BE 12-INCHES UNLESS OTHERWISE SHOWN.
- CONTRACTOR TO FIELD VERIFY ALL DIMENSIONS, LOCATIONS, AND ELEVATIONS BEFORE STARTING WORK AND PRIOR TO ORDERING MATERIAL.
- CONTRACTOR TO COMPLY WITH IDAPA 58.01.08.542.07 WHEN WATER MAINS AND POTABLE WATER SERVICE LINES ARE ENCOUNTERED DURING SEWER MAIN AND SERVICE TRENCHING ACTIVITIES.
- PROPERTY LINES SHOWN ON PLAN SHEETS ARE FOR INFORMATIONAL PURPOSES ONLY AND WERE COMPILED FROM VARIOUS SOURCES. IT IS NOT THE INTENT OF THESE DRAWINGS TO BE USED FOR LOCATION OF PROPERTY LINES. MOUNTAIN WATERWORKS ASSUMES NO LIABILITY FOR PROPERTY LINES WHICH MAY NOT BE ACCURATELY SHOWN.
- ALL MANHOLES ARE TO BE CONSTRUCTED IN ACCORDANCE WITH WASTEWATER MANHOLE TYPE 1 DETAIL 7 ON SHT CD-4 UNLESS OTHERWISE SHOWN.
- GEOTECHNICAL BORINGS SHOWN IN APPROXIMATE LOCATIONS FOR INFORMATIONAL PURPOSES.

KEY NOTES:

- 1 GAS MAIN TO BE RELOCATED BY UTILITY COMPANY PRIOR TO CONSTRUCTION.
- 2 RESTORE EXISTING RIP-RAP TO PRECONSTRUCTION CONDITIONS.
- 3 REMOVE AND REPLACE EXISTING STORM DRAINS AS NEEDED TO INSTALL SEWER PIPE AT NO ADDITIONAL COST TO THE OWNER.

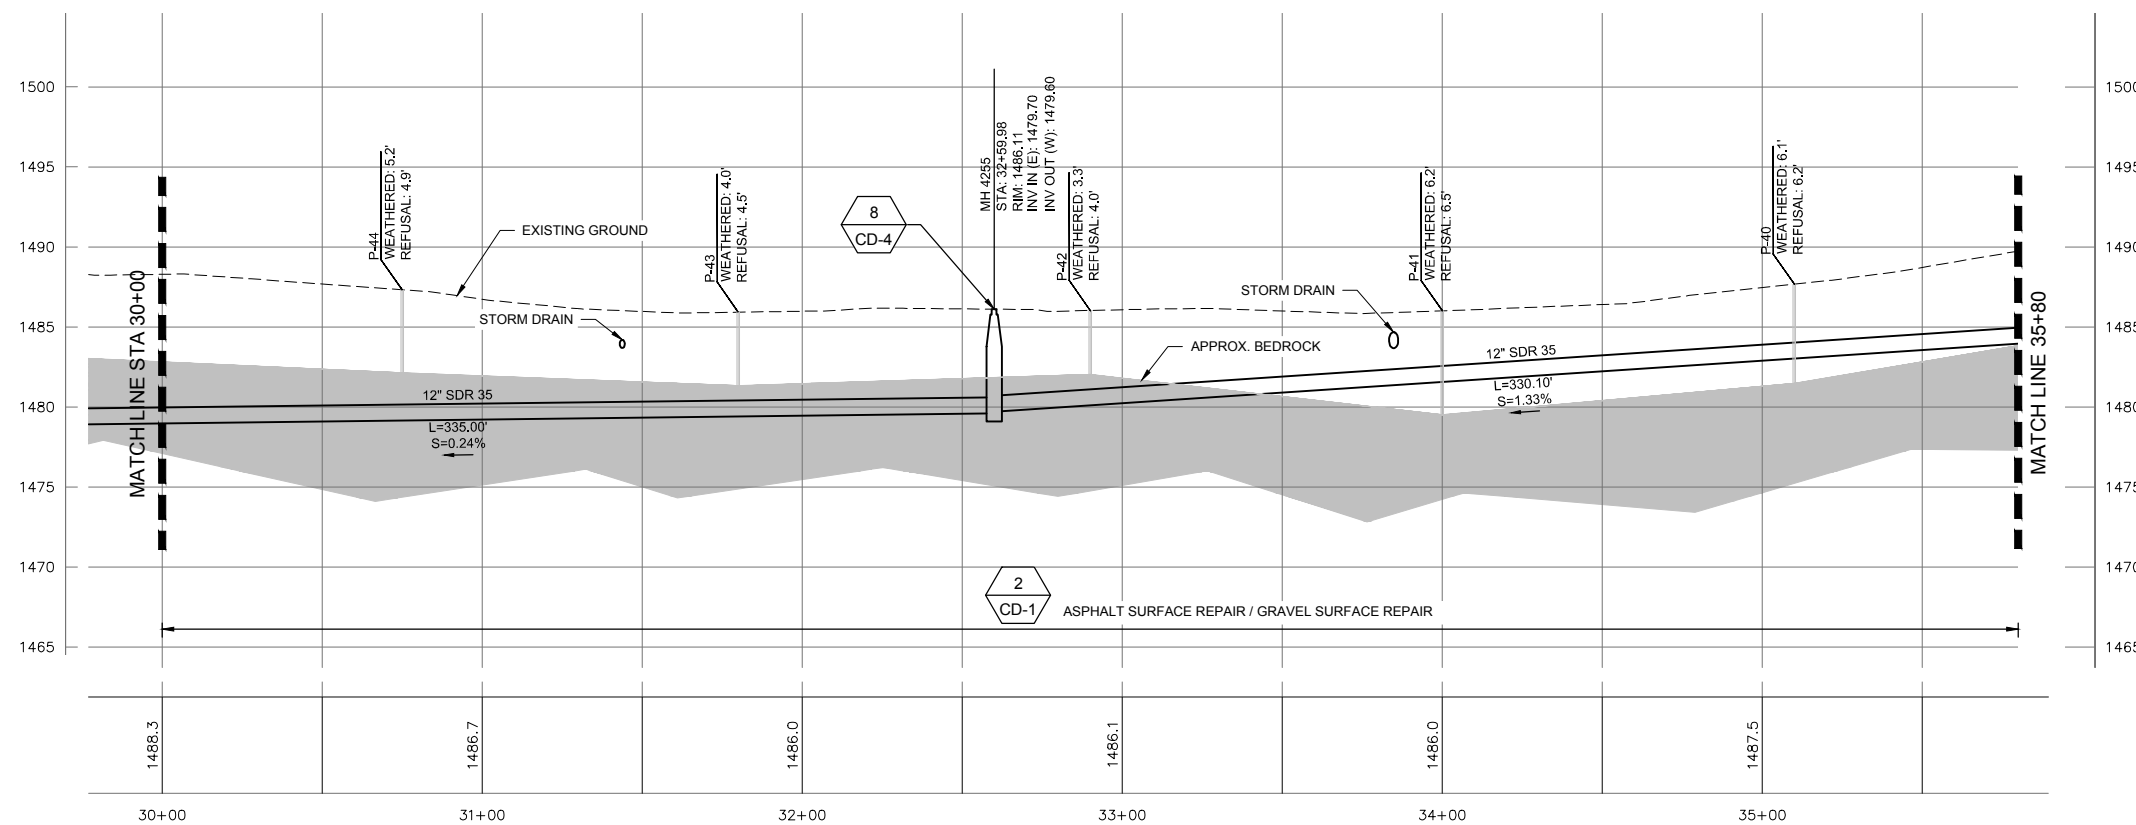

PROFILE STA. 30+00 - 35+80

HORIZ. SCALE: 1" = 30'  
VER. SCALE: 1" = 6'  
(VERIFY PER SHEET SIZE)

Path: E:\Projects\11-Lewiston\_1810020 Phase I\CA\B\B\B Lewiston Profiles.dwg File Name: AB Lewiston Profiles.dwg Plot Date: 11/20/2019 5:03 PM Draw

NO.	REVISION	BY	DATE	DESIGN
				LCH
				DRAWN OTW
				CHECKED LMD
				APPROVED



RECORD DRAWING

THESE RECORD DRAWINGS HAVE BEEN PREPARED BASED IN PART ON INFORMATION PROVIDED BY OTHERS

THIS DRAWING WAS PREPARED ONLY FOR THE PROJECT AND SITE SPECIFICALLY IDENTIFIED HEREON AND IS NOT TO BE USED ELSEWHERE



ENGINEERING AND ENVIRONMENTAL SOLUTIONS

111 MAIN ST. SUITE 175  
LEWISTON, IDAHO 83501  
208.780.3990

IDAHO OFFICES  
BOISE · LEWISTON · COEUR D'ALENE

EAST ORCHARDS SEWER EXPANSION

LEWISTON, IDAHO

STA 30+00 - 35+80

VERIFY SCALE	
BAR IS ONE INCH ON FULL SIZE DRAWING	1"
PROJECT :	181.0020
DATE :	11/19/2019
DRAWING NO.	C-4




**GENERAL NOTES:**






- GRAVITY SEWER PIPE MATERIAL TYPE SHALL BE MINIMUM PVC SDR-35. PIPE DIAMETER TO BE 12-INCHES UNLESS OTHERWISE SHOWN.
- CONTRACTOR TO FIELD VERIFY ALL DIMENSIONS, LOCATIONS, AND ELEVATIONS BEFORE STARTING WORK AND PRIOR TO ORDERING MATERIAL.
- CONTRACTOR TO COMPLY WITH IDAPA 58.01.08.542.07 WHEN WATER MAINS AND POTABLE WATER SERVICE LINES ARE ENCOUNTERED DURING SEWER MAIN AND SERVICE TRENCHING ACTIVITIES.
- PROPERTY LINES SHOWN ON PLAN SHEETS ARE FOR INFORMATIONAL PURPOSES ONLY AND WERE COMPILED FROM VARIOUS SOURCES. IT IS NOT THE INTENT OF THESE DRAWINGS TO BE USED FOR LOCATION OF PROPERTY LINES. MOUNTAIN WATERWORKS ASSUMES NO LIABILITY FOR PROPERTY LINES WHICH MAY NOT BE ACCURATELY SHOWN.
- ALL MANHOLES ARE TO BE CONSTRUCTED IN ACCORDANCE WITH WASTEWATER MANHOLE TYPE 1 DETAIL 7 ON SHT CD-4 UNLESS OTHERWISE SHOWN.
- GEOTECHNICAL BORINGS SHOWN IN APPROXIMATE LOCATIONS FOR INFORMATIONAL PURPOSES.

**KEY NOTES:**

- WATER MAIN UTILITY CROSSINGS (APPROX. DEPTHS).
- PROVIDE AND INSTALL PIPE STUB-OUT FOR FUTURE LATERAL CONNECTION INTO MANHOLE IN ACCORDANCE WITH C999 ON SHT CD-8.
- GAS MAIN TO BE RELOCATED BY UTILITY COMPANY PRIOR TO CONSTRUCTION.

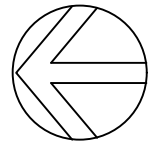


NORTH

 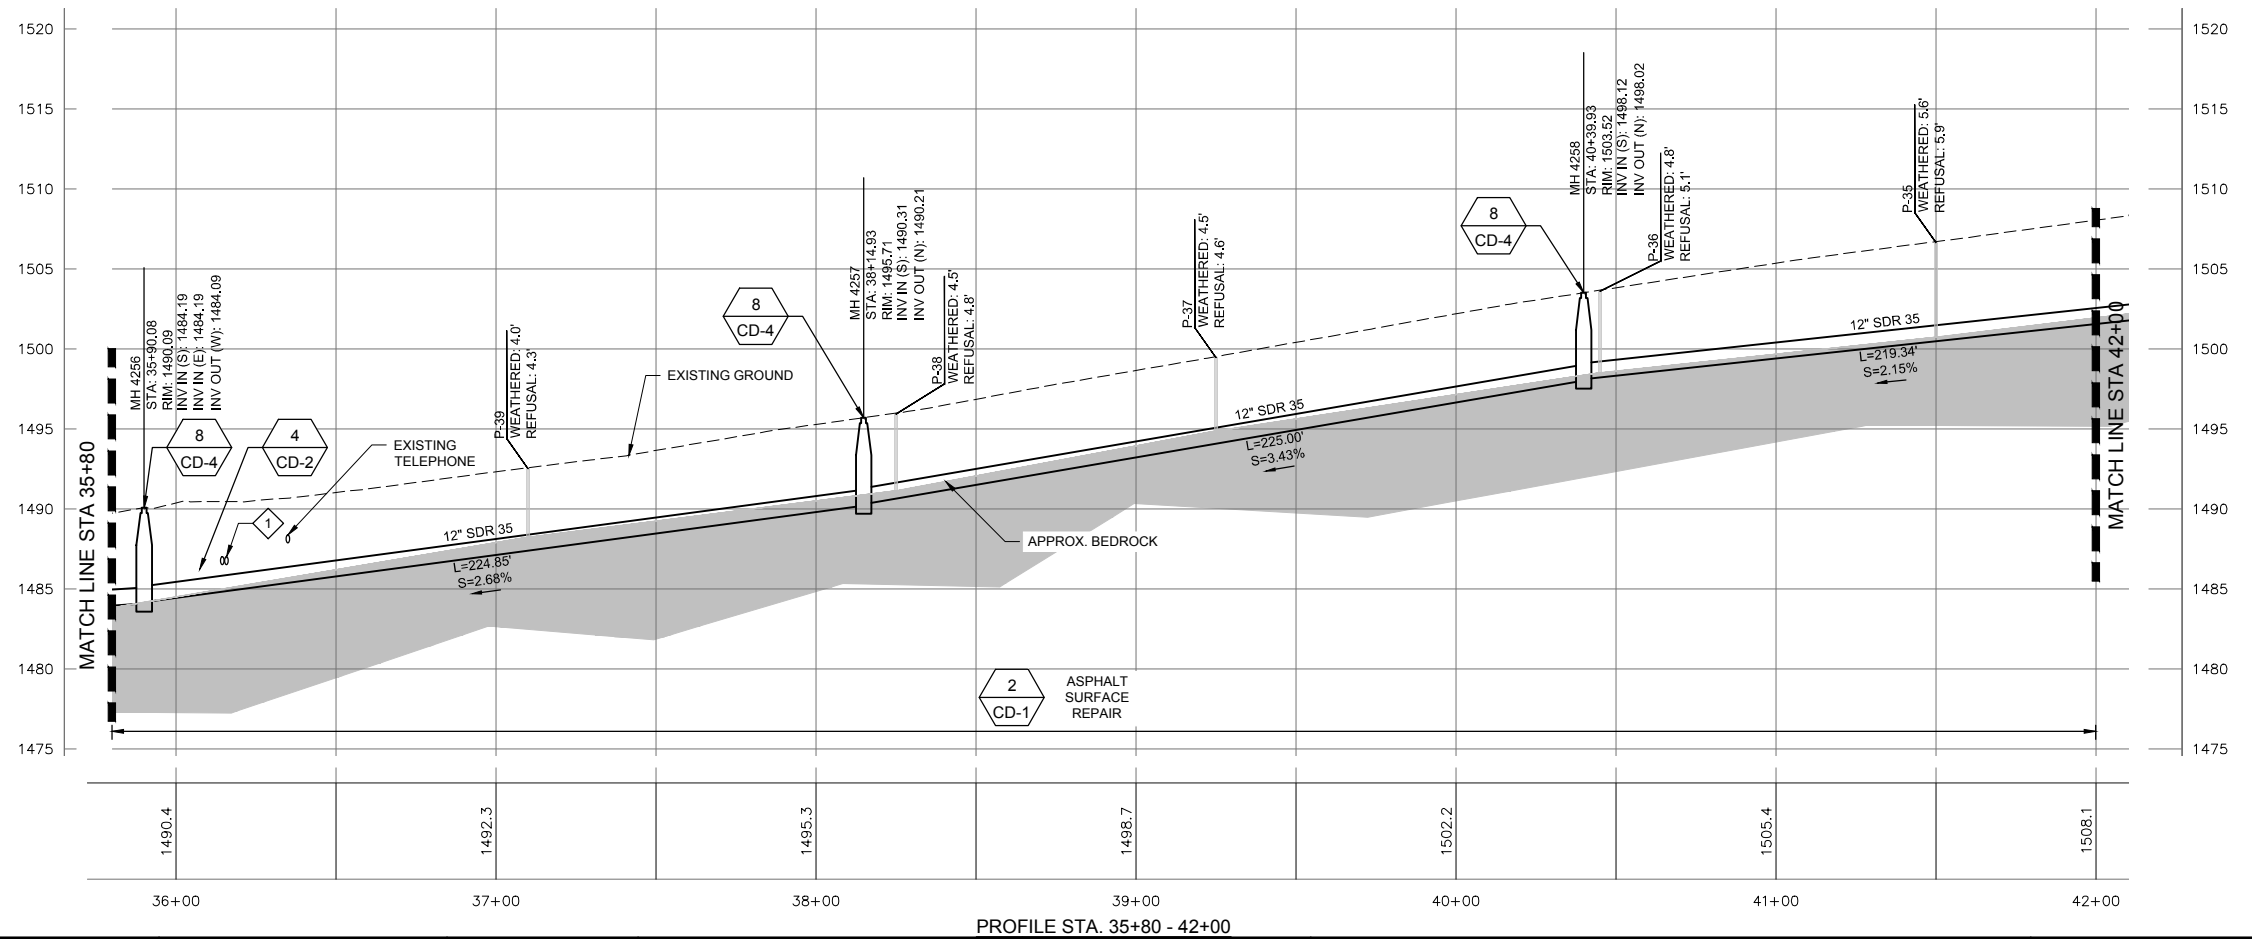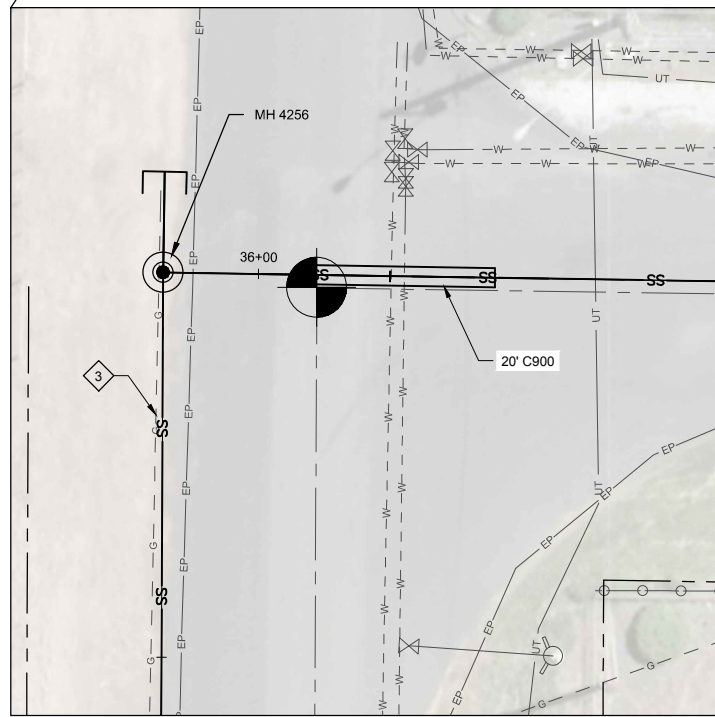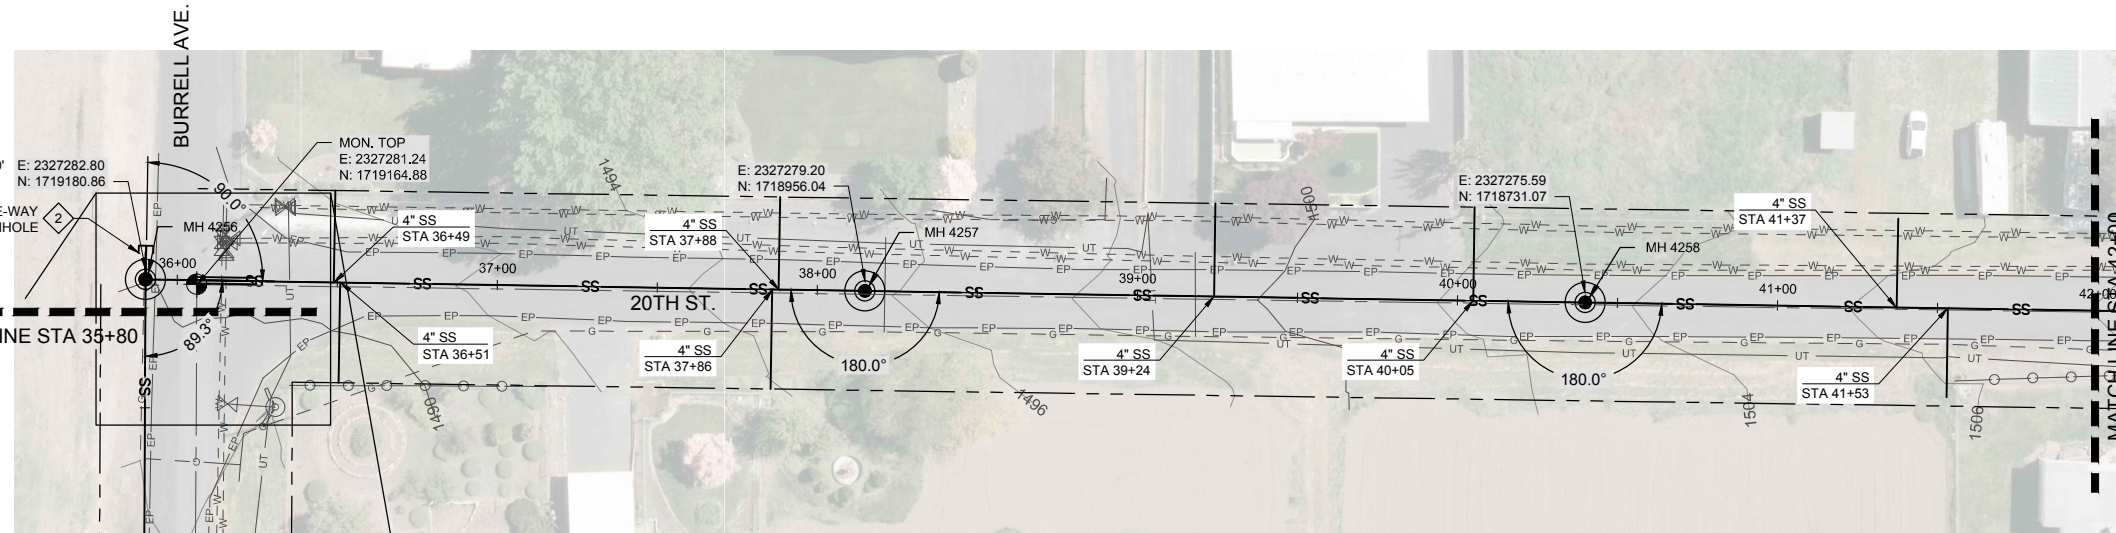 

HORIZ. SCALE: 1" = 30'  
VER. SCALE: 1" = 6'  
(VERIFY PER SHEET SIZE)

Path: E:\Projects\1810020 Phase I\CD\BIB\BIB Lewiston Profiles.dwg File Name: AB Lewiston Profiles.dwg Plot Date: 12/22/19 10:30 AM Drawn

NO.	REVISION	BY	DATE	DESIGN
				LCH
				DRAWN OTW
				CHECKED LMD
				APPROVED

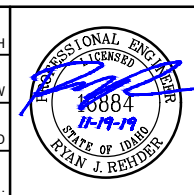

**RECORD DRAWING**  
THESE RECORD DRAWINGS HAVE BEEN PREPARED BASED IN PART ON INFORMATION PROVIDED BY OTHERS  
THIS DRAWING WAS PREPARED ONLY FOR THE PROJECT AND SITE SPECIFICALLY IDENTIFIED HEREON AND IS NOT TO BE USED ELSEWHERE



ENGINEERING AND ENVIRONMENTAL SOLUTIONS  
111 MAIN ST. SUITE 175  
LEWISTON, IDAHO 83501  
208.780.3990  
IDAHO OFFICES  
BOISE · LEWISTON · COEUR D'ALENE

PROFILE STA. 35+80 - 42+00

**EAST ORCHARDS SEWER EXPANSION**  
LEWISTON, IDAHO  
STA 35+80 - 42+00


VERIFY SCALE	BAR IS ONE INCH ON FULL SIZE DRAWING
PROJECT :	181.0020
DATE :	11/19/2019
DRAWING NO.	C-5











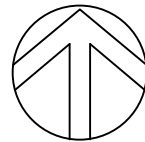

NORTH

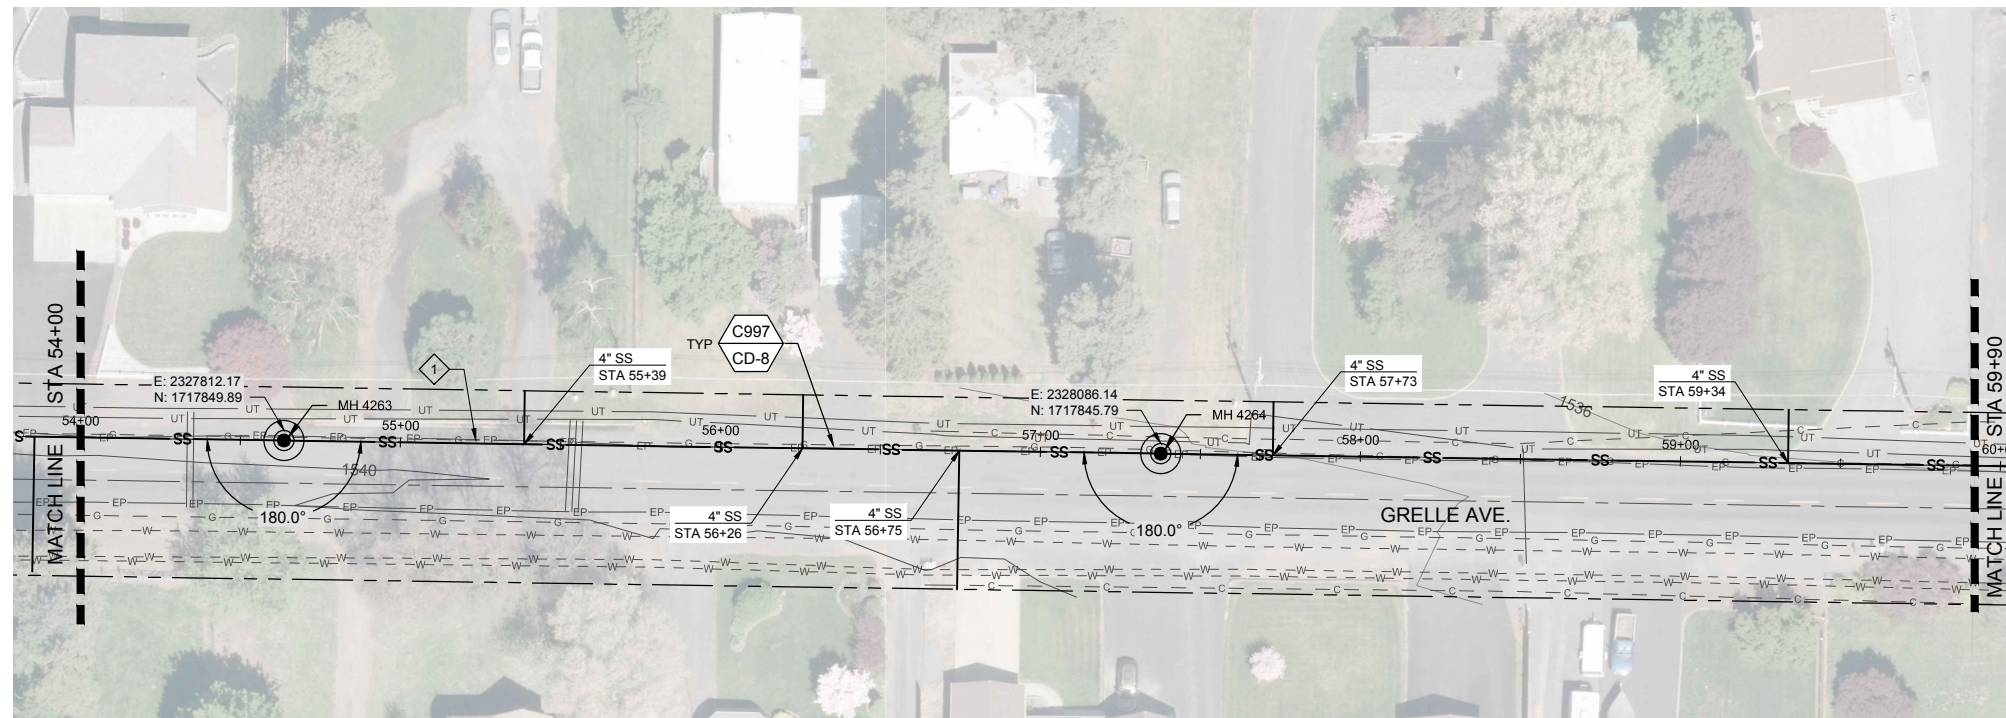 


**GENERAL NOTES:**

- GRAVITY SEWER PIPE MATERIAL TYPE SHALL BE MINIMUM PVC SDR-35. PIPE DIAMETER TO BE 12-INCHES UNLESS OTHERWISE SHOWN.
- CONTRACTOR TO FIELD VERIFY ALL DIMENSIONS, LOCATIONS, AND ELEVATIONS BEFORE STARTING WORK AND PRIOR TO ORDERING MATERIAL.
- CONTRACTOR TO COMPLY WITH IDAPA 58.01.08.542.07 WHEN WATER MAINS AND POTABLE WATER SERVICE LINES ARE ENCOUNTERED DURING SEWER MAIN AND SERVICE TRENCHING ACTIVITIES.
- PROPERTY LINES SHOWN ON PLAN SHEETS ARE FOR INFORMATIONAL PURPOSES ONLY AND WERE COMPILED FROM VARIOUS SOURCES. IT IS NOT THE INTENT OF THESE DRAWINGS TO BE USED FOR LOCATION OF PROPERTY LINES. MOUNTAIN WATERWORKS ASSUMES NO LIABILITY FOR PROPERTY LINES WHICH MAY NOT BE ACCURATELY SHOWN.
- ALL MANHOLES ARE TO BE CONSTRUCTED IN ACCORDANCE WITH WASTEWATER MANHOLE TYPE 1 DETAIL 7 ON SHT CD-4 UNLESS OTHERWISE SHOWN.
- GEOTECHNICAL BORINGS SHOWN IN APPROXIMATE LOCATIONS FOR INFORMATIONAL PURPOSES.

**KEY NOTES:**

- GAS MAIN TO BE RELOCATED BY UTILITY COMPANY PRIOR TO CONSTRUCTION.

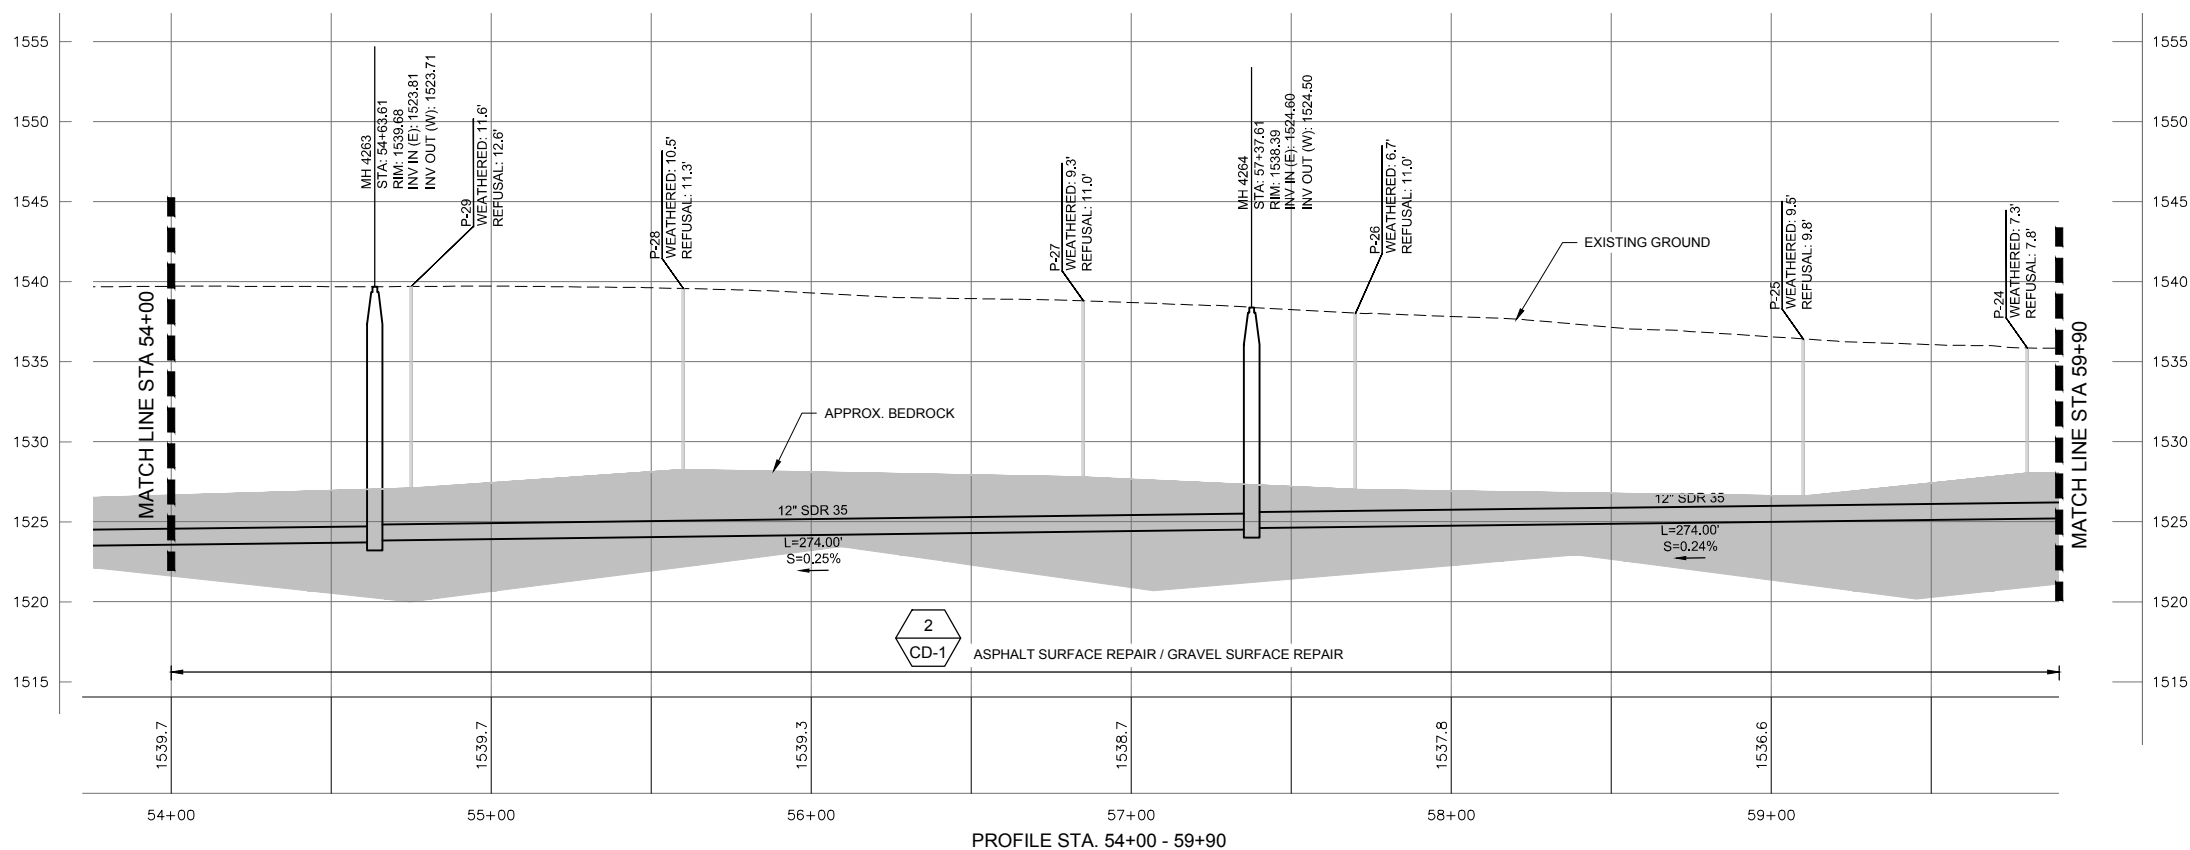

HORIZ. SCALE: 1" = 30'  
VER. SCALE: 1" = 6'  
(VERIFY PER SHEET SIZE)

Path: E:\Projects\11-Lewiston\_1810020 Phase I\CAD\BIB Lewiston Profiles.dwg File Name: AB Lewiston Profiles.dwg Plot Date: 11/20/2019 5:04 PM Draw

NO.	REVISION	BY	DATE	DESIGN
				LCH
				DRAWN OTW
				CHECKED LMD
				APPROVED



**RECORD DRAWING**

THESE RECORD DRAWINGS HAVE BEEN PREPARED BASED IN PART ON INFORMATION PROVIDED BY OTHERS

THIS DRAWING WAS PREPARED ONLY FOR THE PROJECT AND SITE SPECIFICALLY IDENTIFIED HEREON AND IS NOT TO BE USED ELSEWHERE



**ENGINEERING AND ENVIRONMENTAL SOLUTIONS**

111 MAIN ST. SUITE 175  
LEWISTON, IDAHO 83501  
208.780.3990

IDAHO OFFICES  
BOISE · LEWISTON · COEUR D'ALENE


**EAST ORCHARDS SEWER EXPANSION**

LEWISTON, IDAHO




STA 54+00 - 59+90

VERIFY SCALE	BAR IS ONE INCH ON FULL SIZE DRAWING
PROJECT :	181.0020
DATE :	11/19/2019
DRAWING NO.	C-8







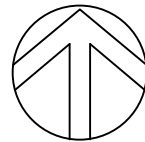

NORTH

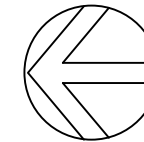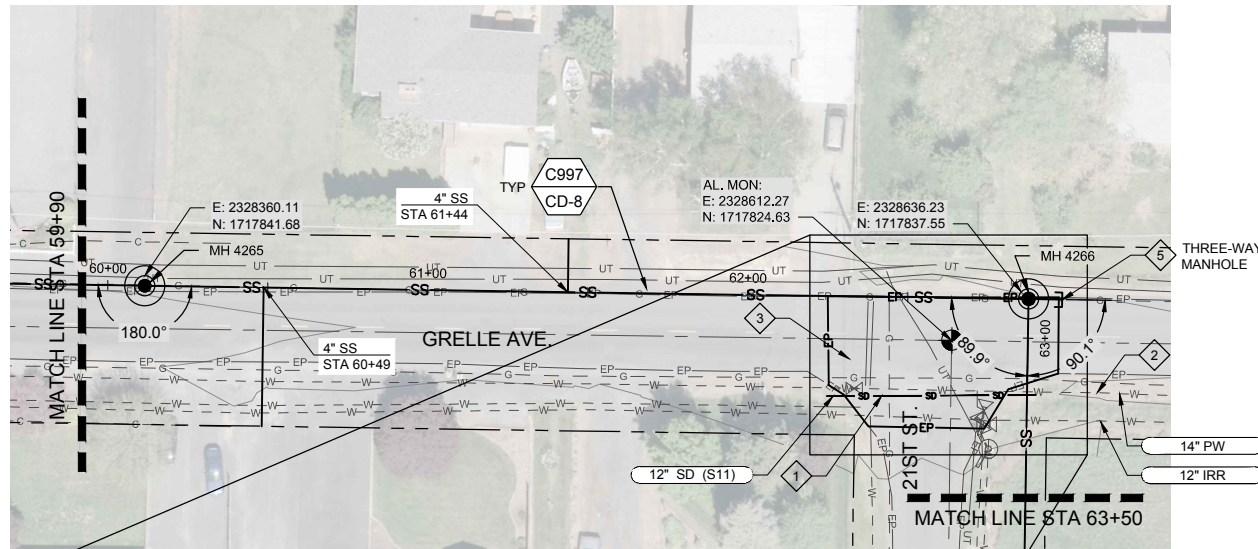 

NORTH

 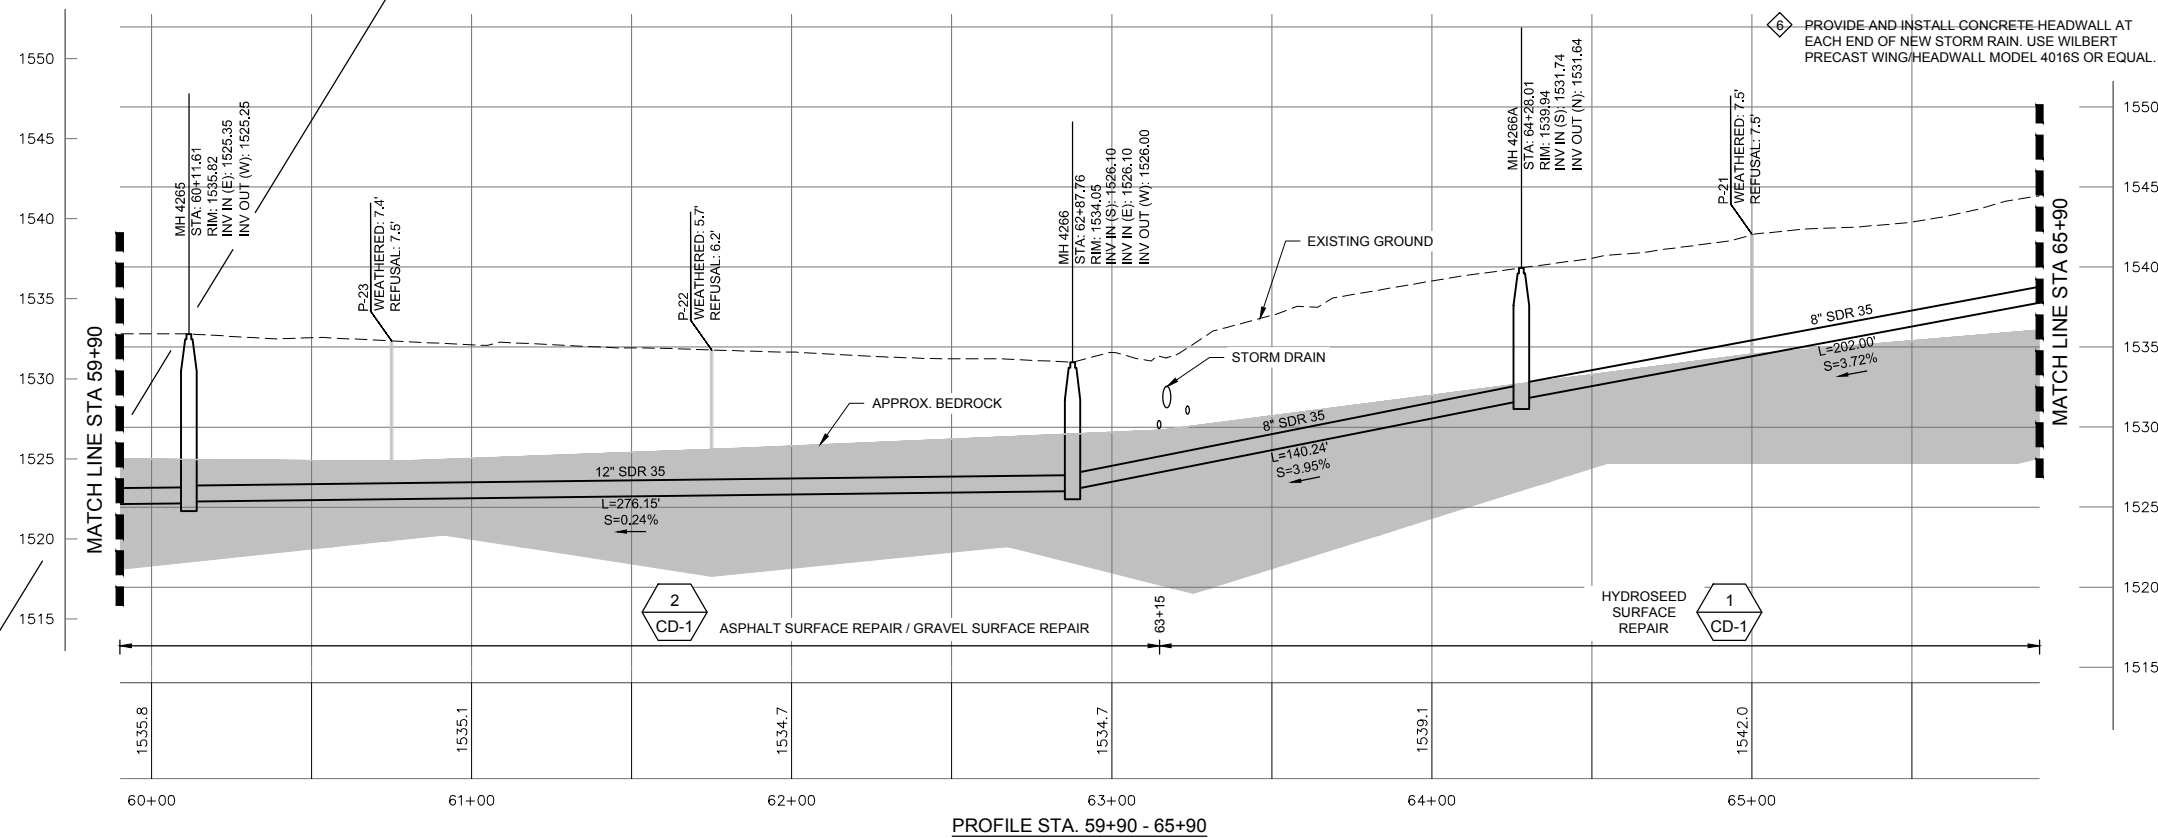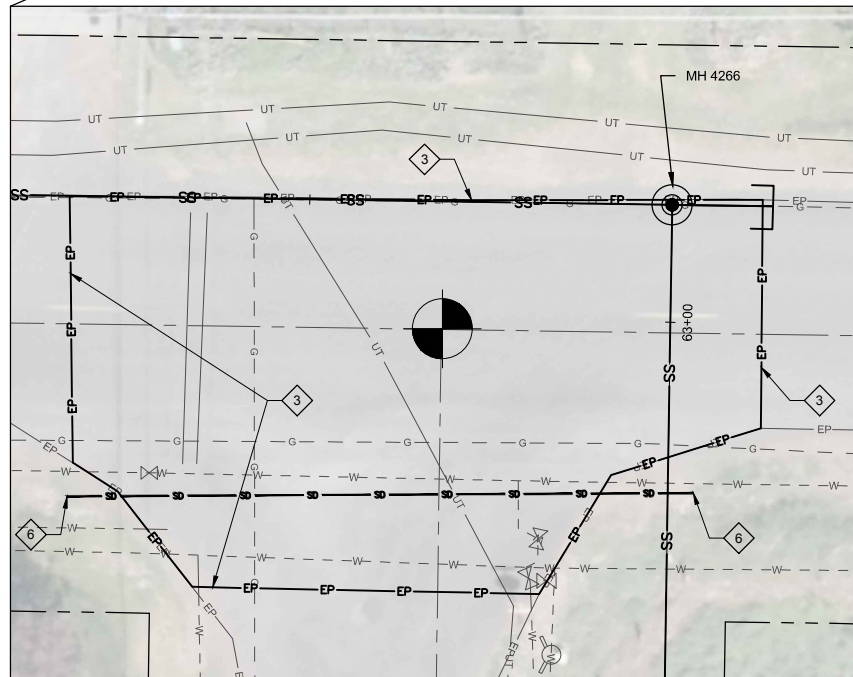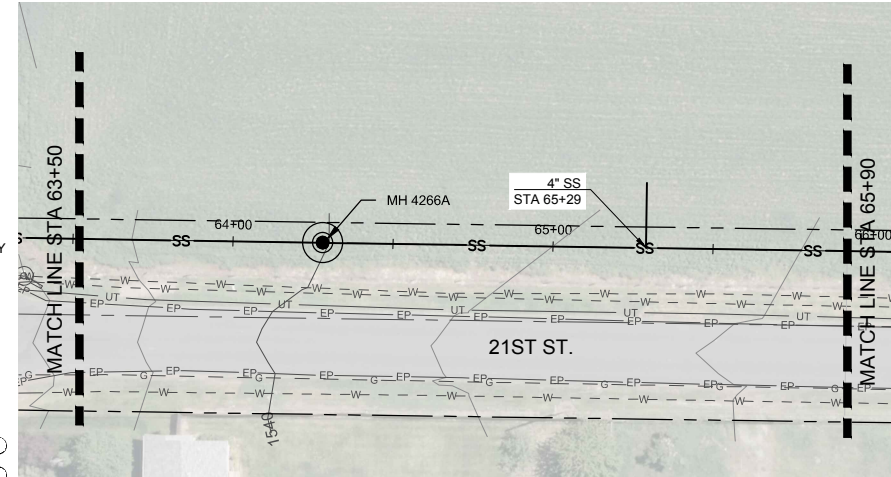

HORIZ. SCALE: 1" = 30'  
VER. SCALE: 1" = 6'  
(VERIFY PER SHEET SIZE)

Path: E:\projects\11-Lewiston\_1810020 Phase I\CAD\BIB\BIB Lewiston Profiles.dwg File Name: AB Lewiston Profiles.dwg Pld Date: 11/20/2019 5:04 PM Draw

GENERAL NOTES:

- GRAVITY SEWER PIPE MATERIAL TYPE SHALL BE MINIMUM PVC SDR-35. PIPE DIAMETER TO BE 12-INCHES UNLESS OTHERWISE SHOWN.
- CONTRACTOR TO FIELD VERIFY ALL DIMENSIONS, LOCATIONS, AND ELEVATIONS BEFORE STARTING WORK AND PRIOR TO ORDERING MATERIAL.
- CONTRACTOR TO COMPLY WITH IDAPA 58.01.08.542.07 WHEN WATER MAINS AND POTABLE WATER SERVICE LINES ARE ENCOUNTERED DURING SEWER MAIN AND SERVICE TRENCHING ACTIVITIES.
- PROPERTY LINES SHOWN ON PLAN SHEETS ARE FOR INFORMATIONAL PURPOSES ONLY AND WERE COMPILED FROM VARIOUS SOURCES. IT IS NOT THE INTENT OF THESE DRAWINGS TO BE USED FOR LOCATION OF PROPERTY LINES. MOUNTAIN WATERWORKS ASSUMES NO LIABILITY FOR PROPERTY LINES WHICH MAY NOT BE ACCURATELY SHOWN.
- ALL MANHOLES ARE TO BE CONSTRUCTED IN ACCORDANCE WITH WASTEWATER MANHOLE TYPE 1 DETAIL 7 ON SHT CD-4 UNLESS OTHERWISE SHOWN.
- GEOTECHNICAL BORINGS SHOWN IN APPROXIMATE LOCATIONS FOR INFORMATIONAL PURPOSES.

KEY NOTES:

- CONTRACTOR TO REPLACE STORM DRAIN AS PART OF THE PROJECT. MATCH SIZE, SLOPE, AND INVERT ELEVATION OF EXISTING STORM DRAIN.
- CONVERSATIONS WITH LOID INDICATES THAT THE EXISTING WATER LINE IS 14-INCH ASBESTOS CEMENT. A LIMITED POTHOLING INVESTIGATION INDICATES THAT THE PIPE WAS PLACED DIRECTLY ON BEDROCK. THIS LINE HAS LIMITED VALVING CAPABILITIES. CONTRACTOR TO COORDINATE WITH LOID TO PROTECT PIPE PRIOR TO EXCAVATION.
- REMOVE EXISTING ASPHALT AND REPAVE ENTIRE INTERSECTION WITHIN LIMITS SHOWN. APPROXIMATE AREA AS SHOWN IS 2,565 SQUARE FEET.
- GAS MAIN TO BE RELOCATED BY UTILITY COMPANY PRIOR TO CONSTRUCTION.
- PROVIDE PIPE STUB-OUTS FOR FUTURE LATERAL CONNECTIONS INTO MANHOLE IN ACCORDANCE WITH C999 ON SHT CD-8.
- PROVIDE AND INSTALL CONCRETE HEADWALL AT EACH END OF NEW STORM RAIN. USE WILBERT PRECAST WING/HEADWALL MODEL 4016S OR EQUIV.

NO.	REVISION	BY	DATE	DESIGN
				LCH
				DRAWN OTW
				CHECKED LMD
				APPROVED



RECORD DRAWING

THESE RECORD DRAWINGS HAVE BEEN PREPARED BASED IN PART ON INFORMATION PROVIDED BY OTHERS

THIS DRAWING WAS PREPARED ONLY FOR THE PROJECT AND SITE SPECIFICALLY IDENTIFIED HEREON AND IS NOT TO BE USED ELSEWHERE



ENGINEERING AND ENVIRONMENTAL SOLUTIONS

111 MAIN ST. SUITE 175  
LEWISTON, IDAHO 83501  
208.780.3990


IDAHO OFFICES  
BOISE · LEWISTON · COEUR D'ALENE

EAST ORCHARDS SEWER EXPANSION



LEWISTON, IDAHO

STA 59+90 - 65+90

VERIFY SCALE	
BAR IS ONE INCH ON FULL SIZE DRAWING	
PROJECT :	181.0020
DATE :	11/19/2019
DRAWING NO.	C-9

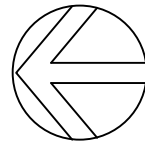

NORTH

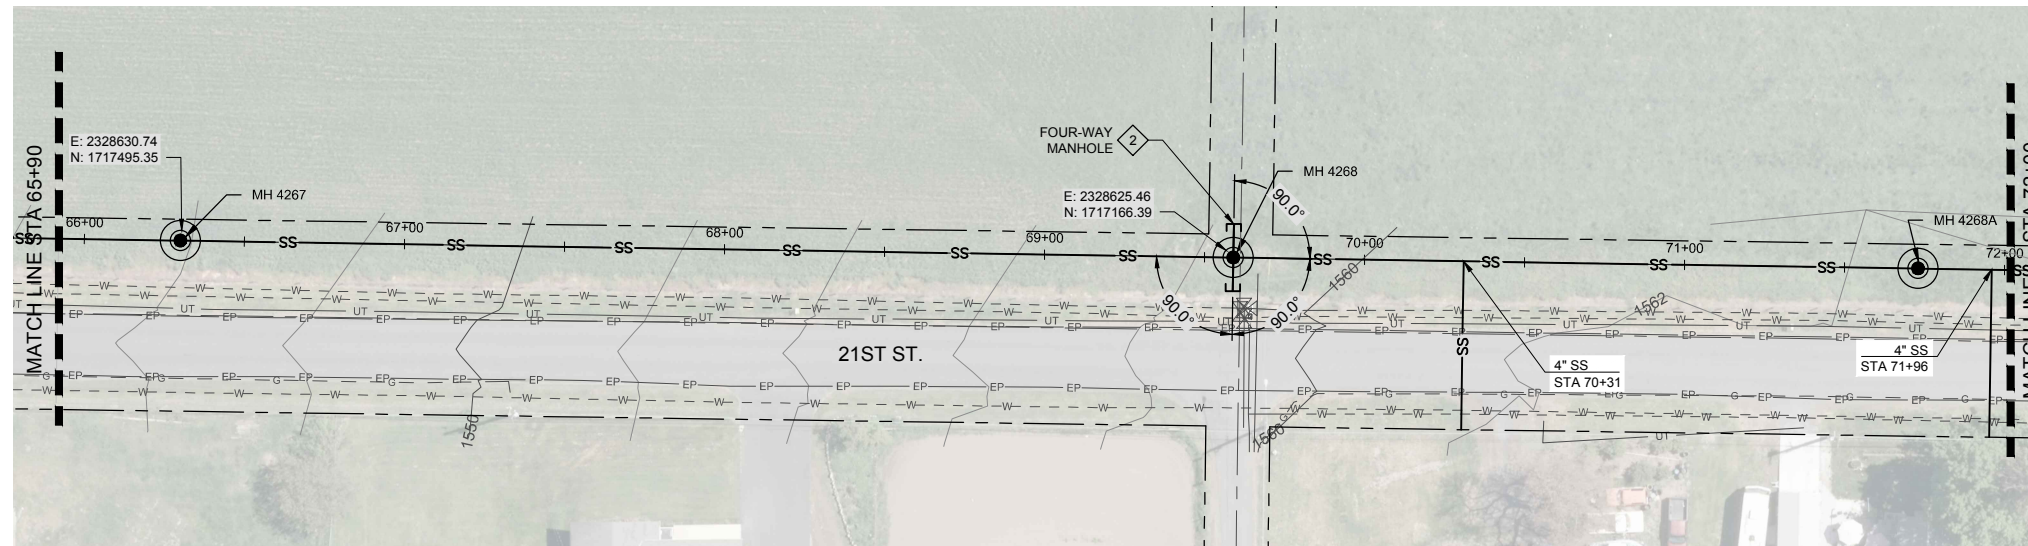 


GENERAL NOTES:

- GRAVITY SEWER PIPE MATERIAL TYPE SHALL BE MINIMUM PVC SDR-35. PIPE DIAMETER TO BE 12-INCHES UNLESS OTHERWISE SHOWN.
- CONTRACTOR TO FIELD VERIFY ALL DIMENSIONS, LOCATIONS, AND ELEVATIONS BEFORE STARTING WORK AND PRIOR TO ORDERING MATERIAL.
- CONTRACTOR TO COMPLY WITH IDAPA 58.01.08.542.07 WHEN WATER MAINS AND POTABLE WATER SERVICE LINES ARE ENCOUNTERED DURING SEWER MAIN AND SERVICE TRENCHING ACTIVITIES.
- PROPERTY LINES SHOWN ON PLAN SHEETS ARE FOR INFORMATIONAL PURPOSES ONLY AND WERE COMPILED FROM VARIOUS SOURCES. IT IS NOT THE INTENT OF THESE DRAWINGS TO BE USED FOR LOCATION OF PROPERTY LINES. MOUNTAIN WATERWORKS ASSUMES NO LIABILITY FOR PROPERTY LINES WHICH MAY NOT BE ACCURATELY SHOWN.
- ALL MANHOLES ARE TO BE CONSTRUCTED IN ACCORDANCE WITH WASTEWATER MANHOLE TYPE 1 DETAIL 7 ON SHT CD-4 UNLESS OTHERWISE SHOWN.
- GEOTECHNICAL BORINGS SHOWN IN APPROXIMATE LOCATIONS FOR INFORMATIONAL PURPOSES.

KEY NOTES:

- ◇ PROVIDE PIPE STUB-OUTS FOR FUTURE LATERAL CONNECTIONS INTO MANHOLE IN ACCORDANCE WITH C999 ON SHT CD-8.

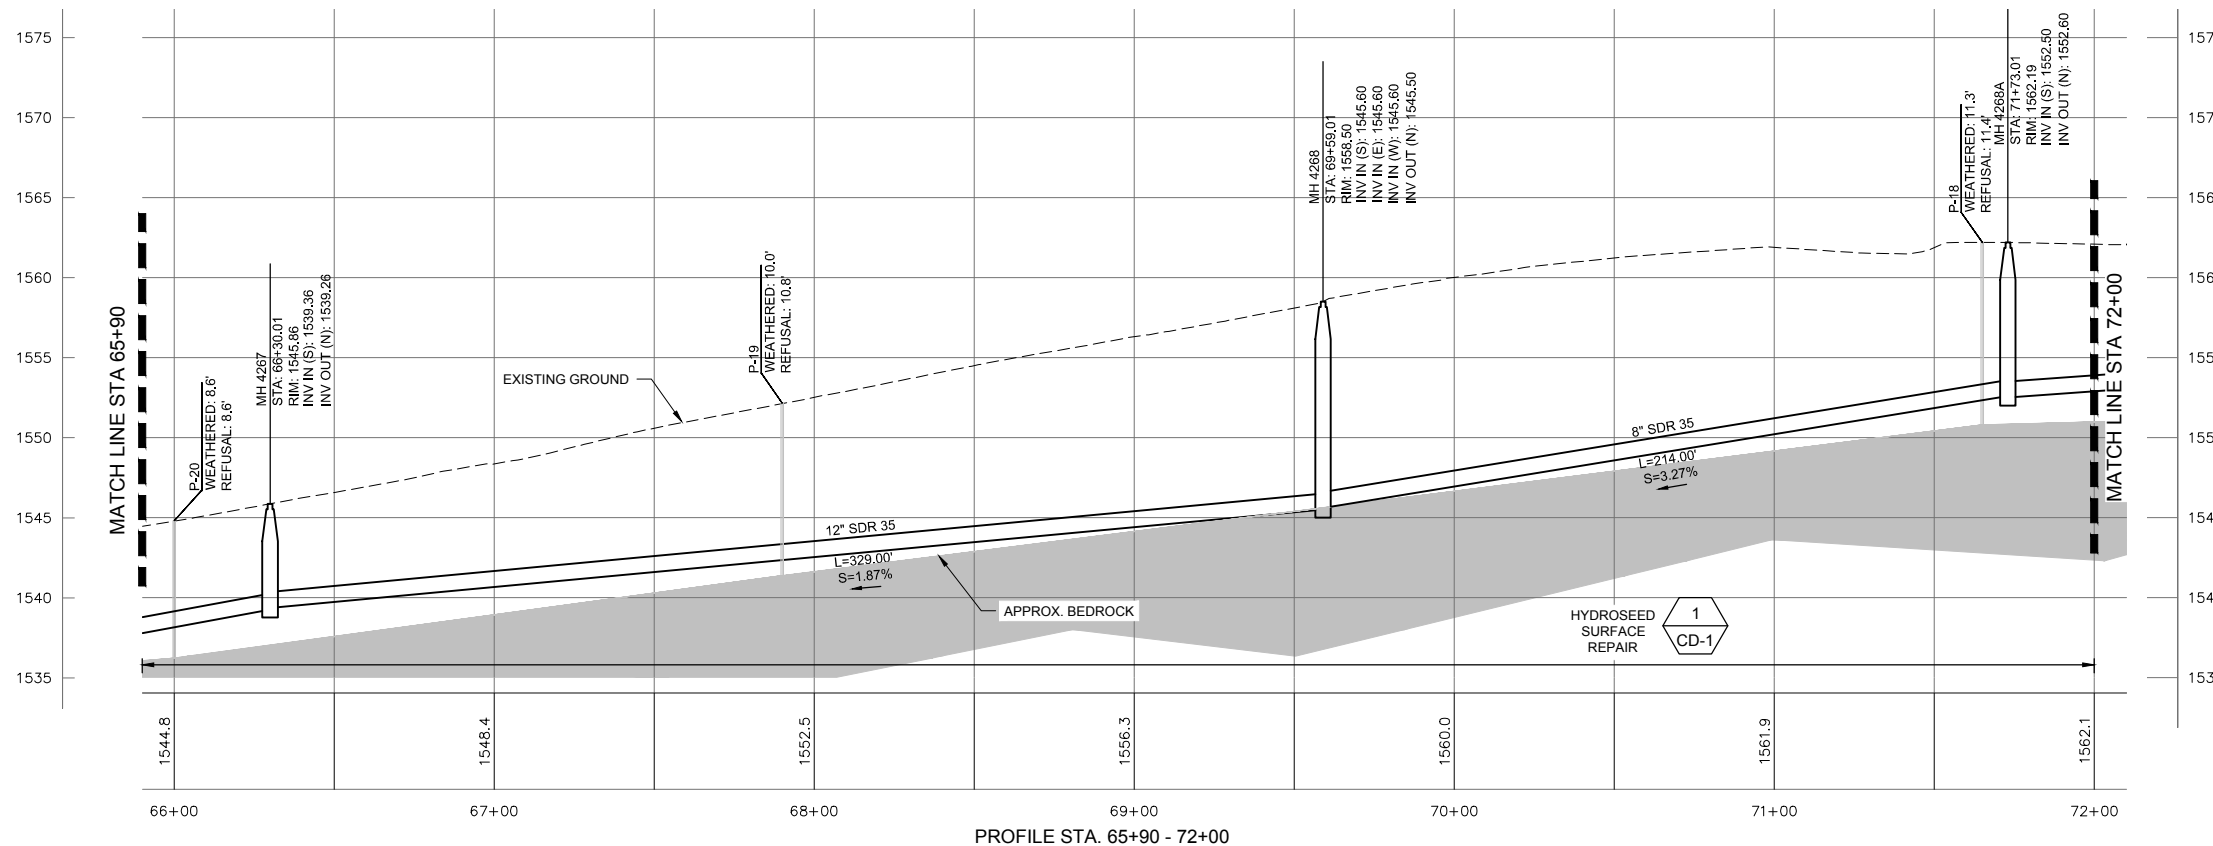

HORIZ. SCALE: 1" = 30'  
VER. SCALE: 1" = 6'  
(VERIFY PER SHEET SIZE)

Path: E:\projects\1111\1111\Phase 1\CD\BIB\BIB\_Lewisston\_Profiles.dwg File Name: AB\_Lewisston\_Profiles.dwg Plot Date: 11/20/2019 5:05 PM Draw

NO.	REVISION	BY	DATE	DESIGN
				LCH
				DRAWN OTW
				CHECKED LMD
				APPROVED



RECORD DRAWING

THESE RECORD DRAWINGS HAVE BEEN PREPARED BASED IN PART ON INFORMATION PROVIDED BY OTHERS

THIS DRAWING WAS PREPARED ONLY FOR THE PROJECT AND SITE SPECIFICALLY IDENTIFIED HEREON AND IS NOT TO BE USED ELSEWHERE



ENGINEERING AND ENVIRONMENTAL SOLUTIONS

111 MAIN ST. SUITE 175  
LEWISTON, IDAHO 83501  
208.780.3990

IDAHO OFFICES  
BOISE · LEWISTON · COEUR D'ALENE


EAST ORCHARDS SEWER EXPANSION

LEWISTON, IDAHO




STA 65+90 - 72+00

VERIFY SCALE	
BAR IS ONE INCH ON FULL SIZE DRAWING	
PROJECT :	181.0020
DATE :	11/19/2019
DRAWING NO.	C-10




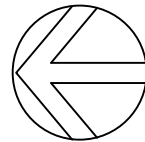

NORTH

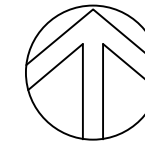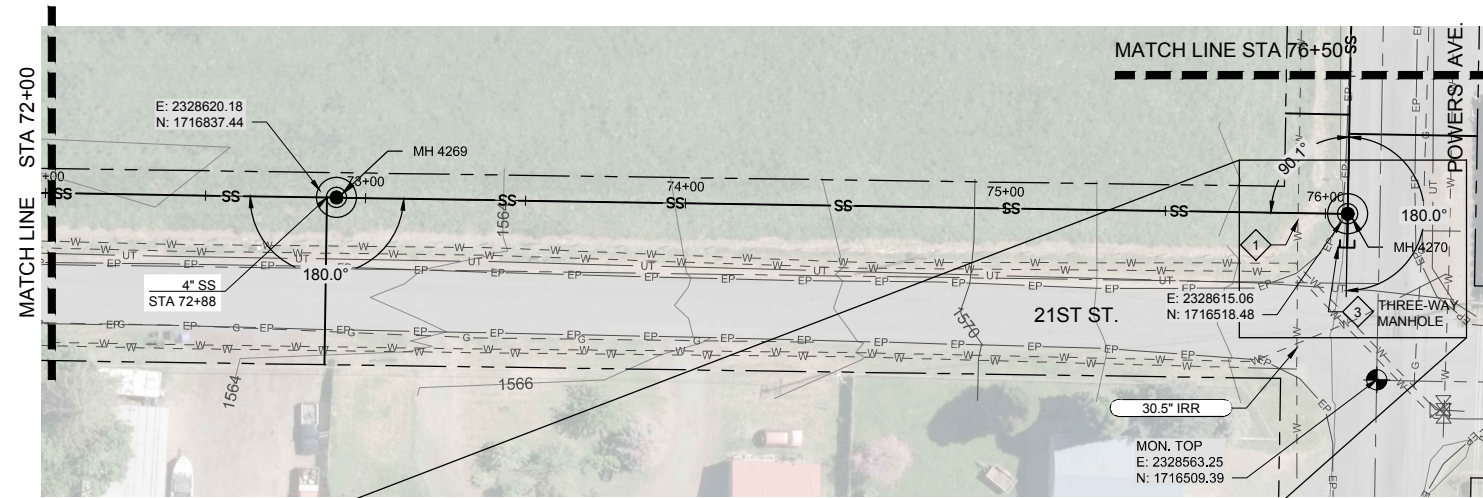 

NORTH



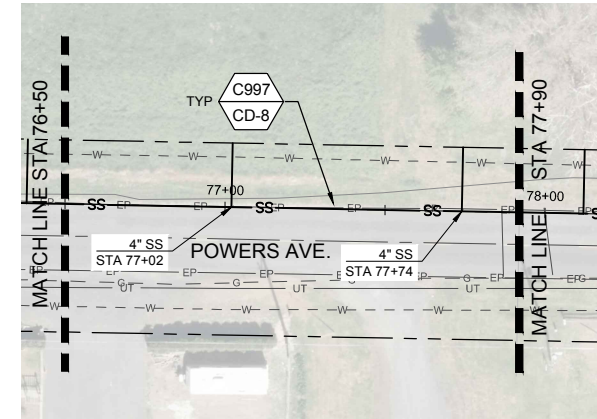


GENERAL NOTES:

- GRAVITY SEWER PIPE MATERIAL TYPE SHALL BE MINIMUM PVC SDR-35. PIPE DIAMETER TO BE 12-INCHES UNLESS OTHERWISE SHOWN.
- CONTRACTOR TO FIELD VERIFY ALL DIMENSIONS, LOCATIONS, AND ELEVATIONS BEFORE STARTING WORK AND PRIOR TO ORDERING MATERIAL.
- CONTRACTOR TO COMPLY WITH IDAPA 58.01.08.542.07 WHEN WATER MAINS AND POTABLE WATER SERVICE LINES ARE ENCOUNTERED DURING SEWER MAIN AND SERVICE TRENCHING ACTIVITIES.
- PROPERTY LINES SHOWN ON PLAN SHEETS ARE FOR INFORMATIONAL PURPOSES ONLY AND WERE COMPILED FROM VARIOUS SOURCES. IT IS NOT THE INTENT OF THESE DRAWINGS TO BE USED FOR LOCATION OF PROPERTY LINES. MOUNTAIN WATERWORKS ASSUMES NO LIABILITY FOR PROPERTY LINES WHICH MAY NOT BE ACCURATELY SHOWN.
- ALL MANHOLES ARE TO BE CONSTRUCTED IN ACCORDANCE WITH WASTEWATER MANHOLE TYPE 1 DETAIL 7 ON SHT CD-4 UNLESS OTHERWISE SHOWN.
- GEOTECHNICAL BORINGS SHOWN IN APPROXIMATE LOCATIONS FOR INFORMATIONAL PURPOSES.

KEY NOTES:

 - EXISTING WATER LINE IS NON-POTABLE 30.5-INCH EPOXY COATED STEEL. CONTRACTOR TO COORDINATE WITH LOID BEFORE PERFORMING WORK WITHIN APPROXIMATELY 5-FEET OF WATER LINE CROSSING. CONTACT CHRIS WOODY, 208.790.2287.
- IF THE EPOXY COATING IS DAMAGED NOTIFY LOID AND MAKE THE APPROPRIATE REPAIRS. CONTRACTOR SHALL REQUEST AN INSPECTION FROM LOID PRIOR TO BACKFILL. IF THE 30.5-INCH PIPE IS DAMAGED IN ANY WAY THE CONTRACTOR SHALL PAY FOR THE NECESSARY REPAIRS, AS DETERMINED BY THE ENGINEER.
- WATER MAIN CROSSING.
- PROVIDE PIPE STUB-OUTS FOR FUTURE LATERAL CONNECTIONS INTO MANHOLE IN ACCORDANCE WITH C999 ON SHT CD-8.

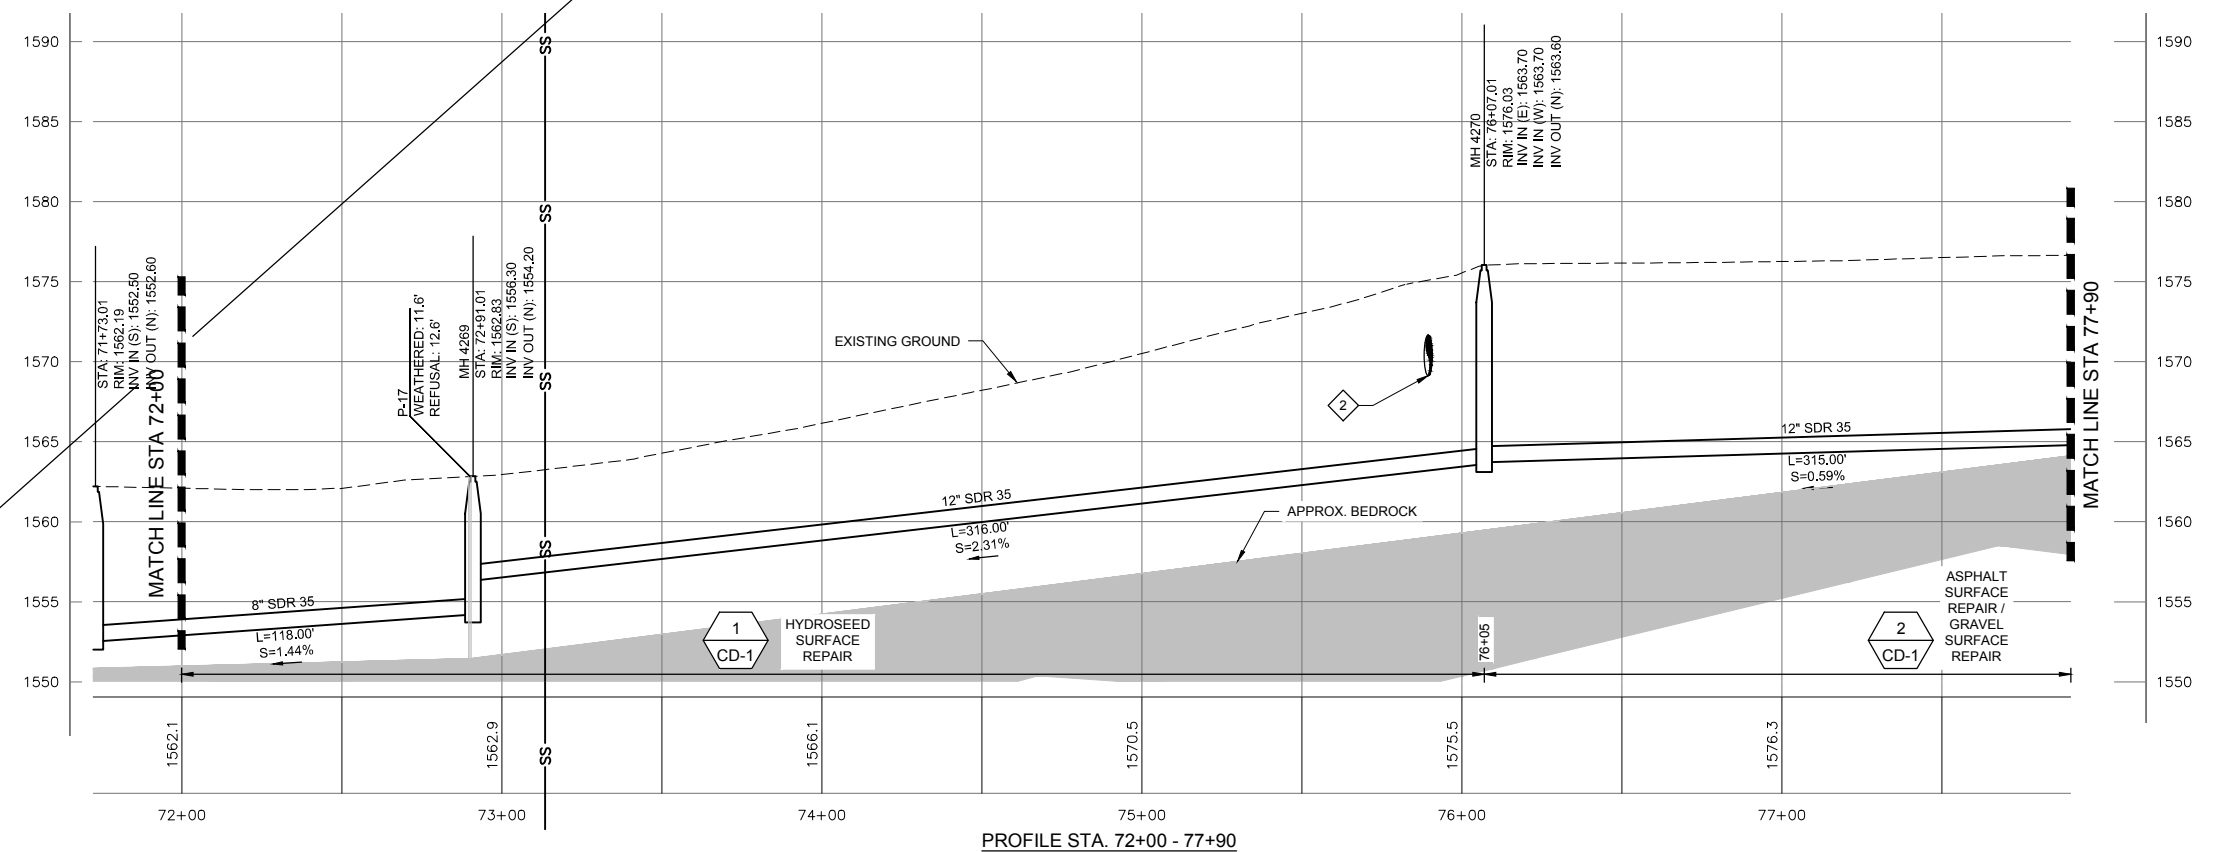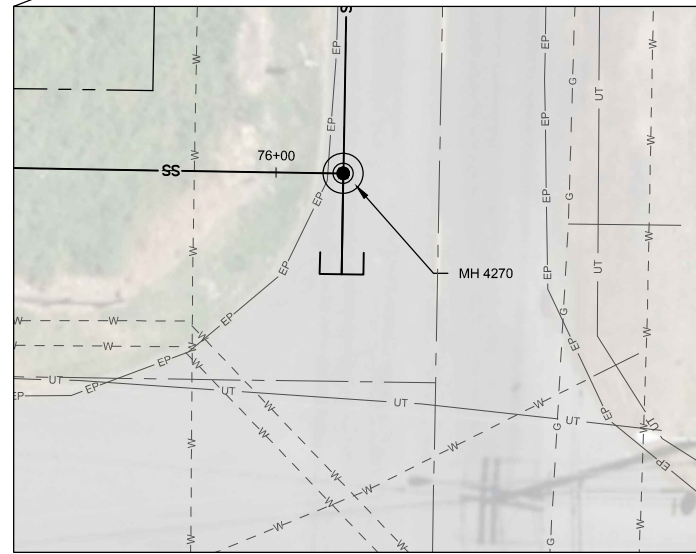

HORIZ. SCALE: 1" = 30'  
VER. SCALE: 1" = 6'  
(VERIFY PER SHEET SIZE)

NO.	REVISION	BY	DATE	DESIGN
				LCH
				DRAWN OTW
				CHECKED LMD
				APPROVED



RECORD DRAWING

THESE RECORD DRAWINGS HAVE BEEN PREPARED BASED IN PART ON INFORMATION PROVIDED BY OTHERS

THIS DRAWING WAS PREPARED ONLY FOR THE PROJECT AND SITE SPECIFICALLY IDENTIFIED HEREON AND IS NOT TO BE USED ELSEWHERE



ENGINEERING AND ENVIRONMENTAL SOLUTIONS

111 MAIN ST. SUITE 175  
LEWISTON, IDAHO 83501  
208.780.3990


IDAHO OFFICES  
BOISE · LEWISTON · COEUR D'ALENE

EAST ORCHARDS SEWER EXPANSION  
LEWISTON, IDAHO



STA 72+00 - 77+90

VERIFY SCALE	
BAR IS ONE INCH ON FULL SIZE DRAWING	
PROJECT :	181.0020
DATE :	11/19/2019
DRAWING NO.	
C-11	



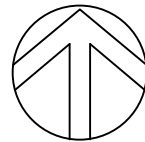


NORTH

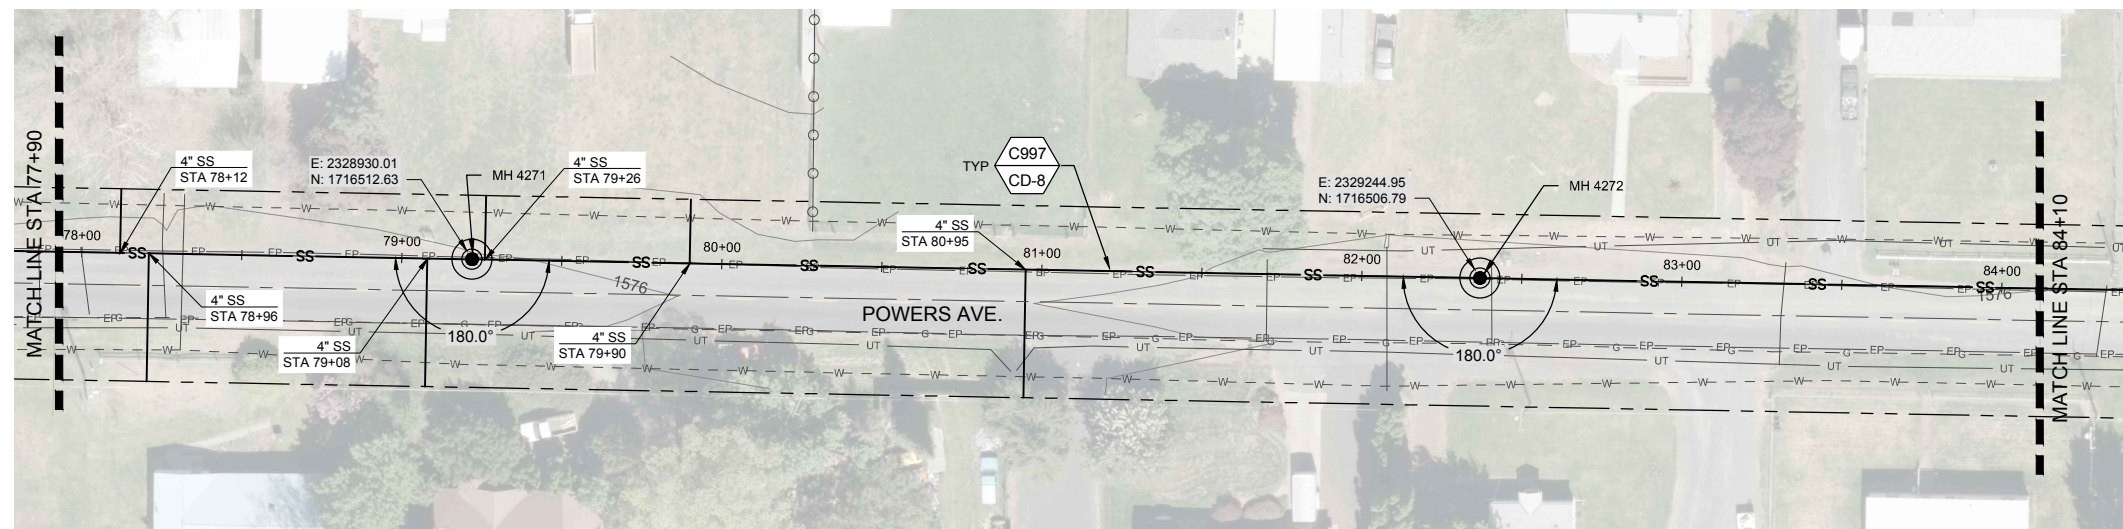 

GENERAL NOTES:

- GRAVITY SEWER PIPE MATERIAL TYPE SHALL BE MINIMUM PVC SDR-35. PIPE DIAMETER TO BE 12-INCHES UNLESS OTHERWISE SHOWN.
- CONTRACTOR TO FIELD VERIFY ALL DIMENSIONS, LOCATIONS, AND ELEVATIONS BEFORE STARTING WORK AND PRIOR TO ORDERING MATERIAL.
- CONTRACTOR TO COMPLY WITH IDAPA 58.01.08.542.07 WHEN WATER MAINS AND POTABLE WATER SERVICE LINES ARE ENCOUNTERED DURING SEWER MAIN AND SERVICE TRENCHING ACTIVITIES.
- PROPERTY LINES SHOWN ON PLAN SHEETS ARE FOR INFORMATIONAL PURPOSES ONLY AND WERE COMPILED FROM VARIOUS SOURCES. IT IS NOT THE INTENT OF THESE DRAWINGS TO BE USED FOR LOCATION OF PROPERTY LINES. MOUNTAIN WATERWORKS ASSUMES NO LIABILITY FOR PROPERTY LINES WHICH MAY NOT BE ACCURATELY SHOWN.
- ALL MANHOLES ARE TO BE CONSTRUCTED IN ACCORDANCE WITH WASTEWATER MANHOLE TYPE 1 DETAIL 7 ON SHT CD-4 UNLESS OTHERWISE SHOWN.
- GEOTECHNICAL BORINGS SHOWN IN APPROXIMATE LOCATIONS FOR INFORMATIONAL PURPOSES.

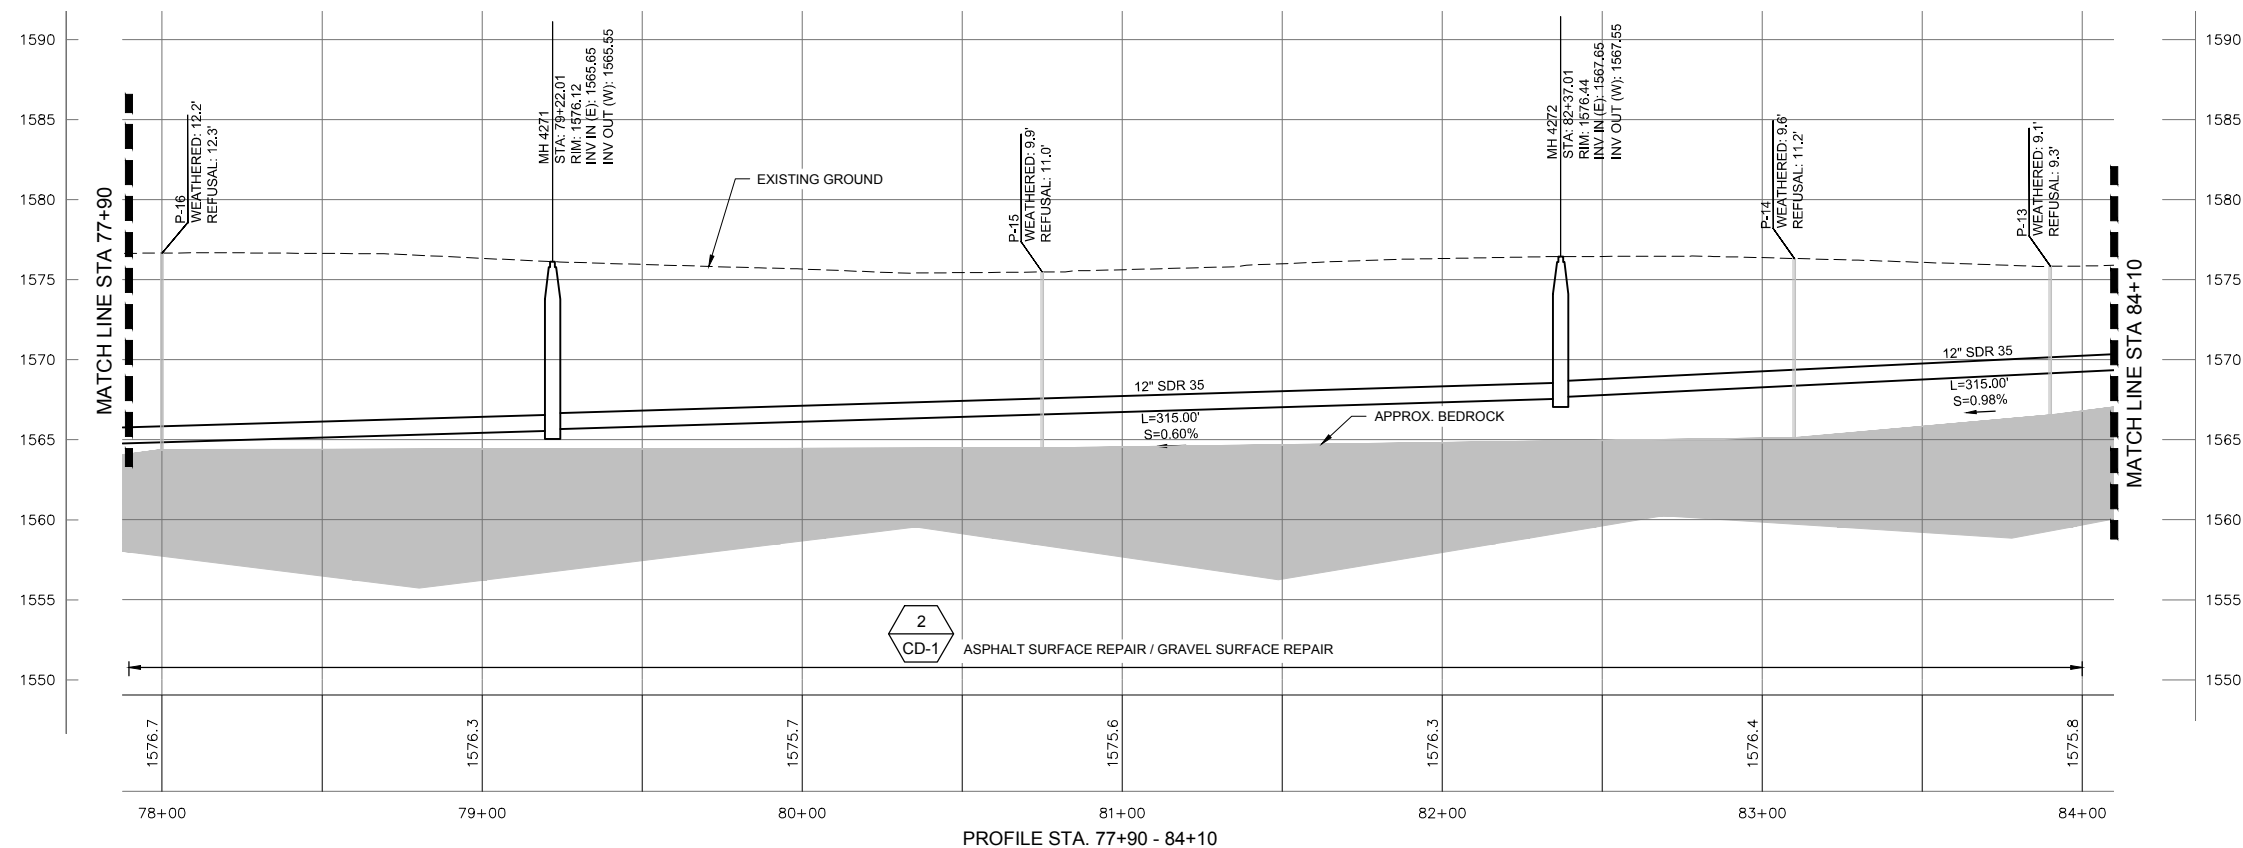

HORIZ. SCALE: 1" = 30'  
VER. SCALE: 1" = 6'  
(VERIFY PER SHEET SIZE)

Path: E:\projects\11-Lewiston\_1810020 Phase I\CD\BIB\B\ Lewiston Profiles.dwg File Name: AB\_Lewiston Profiles.dwg Plot Date: 12/22/19 10:28 AM Draw

NO.	REVISION	BY	DATE	DESIGN
				LCH
				DRAWN OTW
				CHECKED LMD
				APPROVED



RECORD DRAWING

THESE RECORD DRAWINGS HAVE BEEN PREPARED BASED IN PART ON INFORMATION PROVIDED BY OTHERS

THIS DRAWING WAS PREPARED ONLY FOR THE PROJECT AND SITE SPECIFICALLY IDENTIFIED HEREON AND IS NOT TO BE USED ELSEWHERE



ENGINEERING AND ENVIRONMENTAL SOLUTIONS

111 MAIN ST. SUITE 175  
LEWISTON, IDAHO 83501  
208.780.3990

IDAHO OFFICES  
BOISE · LEWISTON · COEUR D'ALENE

EAST ORCHARDS SEWER EXPANSION


LEWISTON, IDAHO

STA 77+90 - 84+10



VERIFY SCALE	
BAR IS ONE INCH ON FULL SIZE DRAWING	
PROJECT :	181.0020
DATE :	11/19/2019
DRAWING NO.	
C-12	





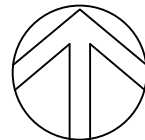

NORTH

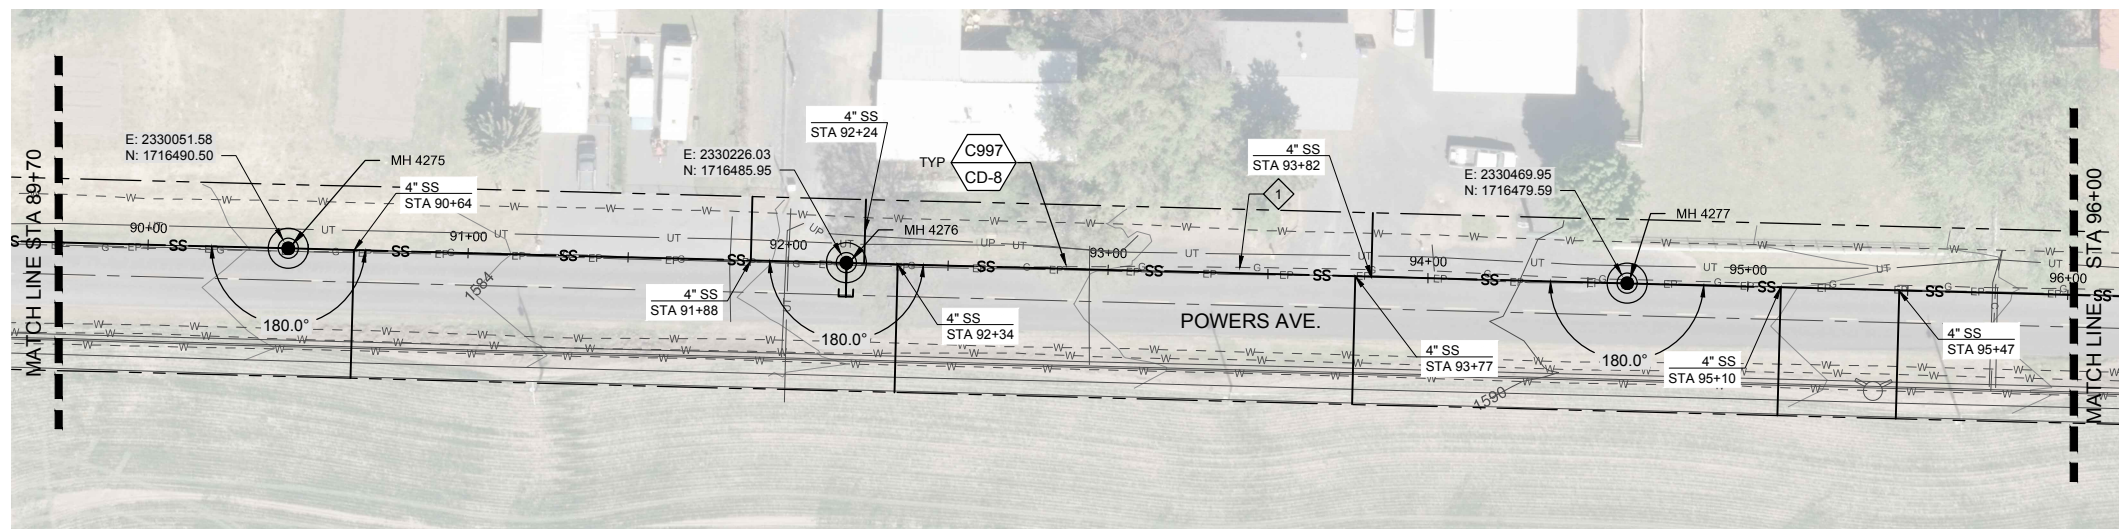 


**GENERAL NOTES:**

- GRAVITY SEWER PIPE MATERIAL TYPE SHALL BE MINIMUM PVC SDR-35. PIPE DIAMETER TO BE 12-INCHES UNLESS OTHERWISE SHOWN.
- CONTRACTOR TO FIELD VERIFY ALL DIMENSIONS, LOCATIONS, AND ELEVATIONS BEFORE STARTING WORK AND PRIOR TO ORDERING MATERIAL.
- CONTRACTOR TO COMPLY WITH IDAPA 58.01.08.542.07 WHEN WATER MAINS AND POTABLE WATER SERVICE LINES ARE ENCOUNTERED DURING SEWER MAIN AND SERVICE TRENCHING ACTIVITIES.
- PROPERTY LINES SHOWN ON PLAN SHEETS ARE FOR INFORMATIONAL PURPOSES ONLY AND WERE COMPILED FROM VARIOUS SOURCES. IT IS NOT THE INTENT OF THESE DRAWINGS TO BE USED FOR LOCATION OF PROPERTY LINES. MOUNTAIN WATERWORKS ASSUMES NO LIABILITY FOR PROPERTY LINES WHICH MAY NOT BE ACCURATELY SHOWN.
- ALL MANHOLES ARE TO BE CONSTRUCTED IN ACCORDANCE WITH WASTEWATER MANHOLE TYPE 1 DETAIL 7 ON SHT CD-4 UNLESS OTHERWISE SHOWN.
- GEOTECHNICAL BORINGS SHOWN IN APPROXIMATE LOCATIONS FOR INFORMATIONAL PURPOSES.

**KEY NOTES:**

- ① GAS MAIN TO BE RELOCATED BY UTILITY COMPANY PRIOR TO CONSTRUCTION.
- ② GRAVITY SEWER PIPE MATERIAL TYPE SHALL BE MINIMUM PVC SDR 35. PIPE DIAMETER TO BE 8-INCHES.

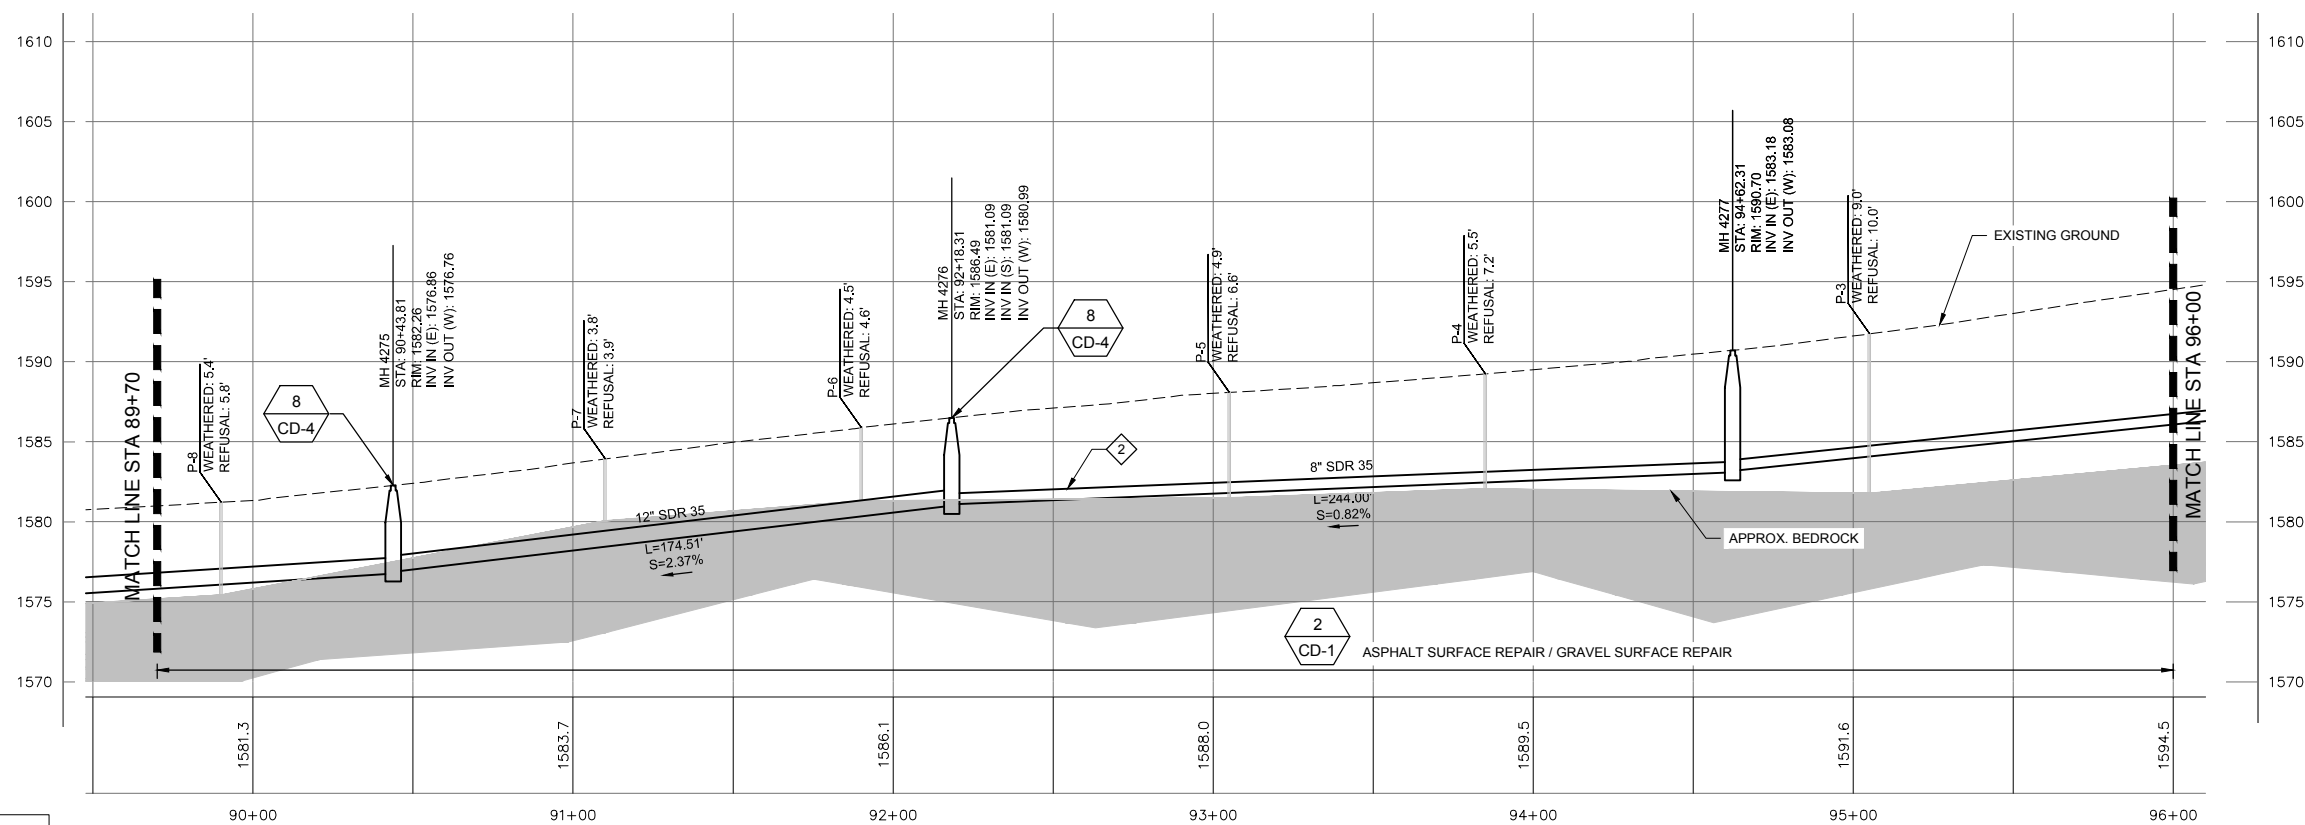

HORIZ. SCALE: 1" = 30'  
VER. SCALE: 1" = 6'  
(VERIFY PER SHEET SIZE)

PROFILE STA. 89+70 - 96+00

Path: E:\projects\1111111111\Phase 1\CD\BIB\BIB Lewiston Profiles.dwg File Name: AB Lewiston Profiles.dwg Plot Date: 11/20/2019 5:07 PM Draw

NO.	REVISION	BY	DATE	DESIGN
				LCH
				DRAWN OTW
				CHECKED LMD
				APPROVED



**RECORD DRAWING**

THESE RECORD DRAWINGS HAVE BEEN PREPARED BASED IN PART ON INFORMATION PROVIDED BY OTHERS

THIS DRAWING WAS PREPARED ONLY FOR THE PROJECT AND SITE SPECIFICALLY IDENTIFIED HEREON AND IS NOT TO BE USED ELSEWHERE



**ENGINEERING AND ENVIRONMENTAL SOLUTIONS**

111 MAIN ST. SUITE 175  
LEWISTON, IDAHO 83501  
208.780.3990


IDAHO OFFICES  
BOISE · LEWISTON · COEUR D'ALENE

**EAST ORCHARDS SEWER EXPANSION**



LEWISTON, IDAHO

STA 89+70 - 96+00

VERIFY SCALE	BAR IS ONE INCH ON FULL SIZE DRAWING
PROJECT :	181.0020
DATE :	11/19/2019
DRAWING NO.	C-14

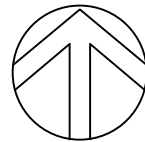

NORTH

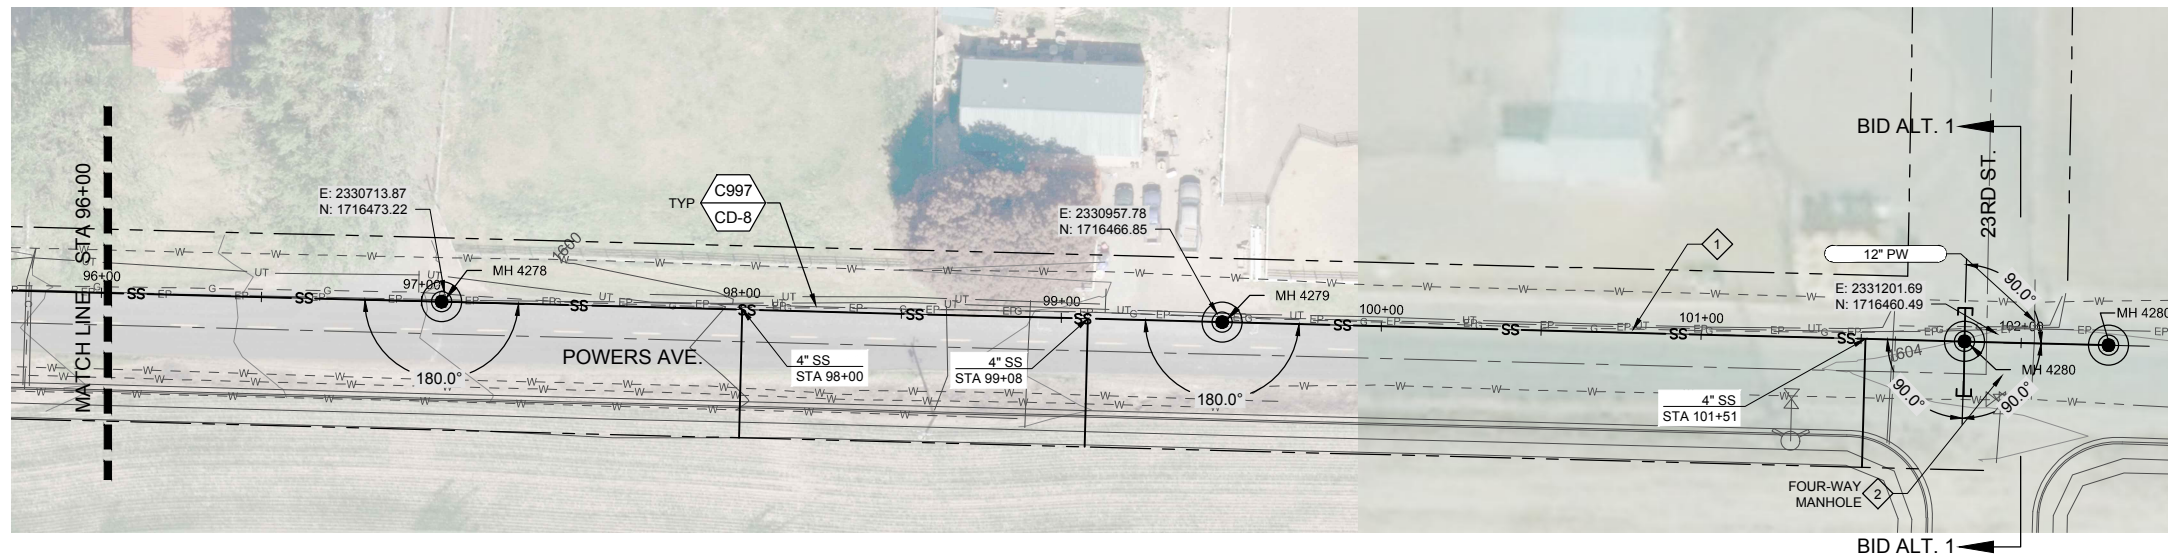 


**GENERAL NOTES:**

- GRAVITY SEWER PIPE MATERIAL TYPE SHALL BE MINIMUM PVC SDR-35. PIPE DIAMETER TO BE 12-INCHES UNLESS OTHERWISE SHOWN.
- CONTRACTOR TO FIELD VERIFY ALL DIMENSIONS, LOCATIONS, AND ELEVATIONS BEFORE STARTING WORK AND PRIOR TO ORDERING MATERIAL.
- CONTRACTOR TO COMPLY WITH IDAPA 58.01.08.542.07 WHEN WATER MAINS AND POTABLE WATER SERVICE LINES ARE ENCOUNTERED DURING SEWER MAIN AND SERVICE TRENCHING ACTIVITIES.
- PROPERTY LINES SHOWN ON PLAN SHEETS ARE FOR INFORMATIONAL PURPOSES ONLY AND WERE COMPILED FROM VARIOUS SOURCES. IT IS NOT THE INTENT OF THESE DRAWINGS TO BE USED FOR LOCATION OF PROPERTY LINES. MOUNTAIN WATERWORKS ASSUMES NO LIABILITY FOR PROPERTY LINES WHICH MAY NOT BE ACCURATELY SHOWN.
- ALL MANHOLES ARE TO BE CONSTRUCTED IN ACCORDANCE WITH WASTEWATER MANHOLE TYPE 1 DETAIL 7 ON SHT CD-4 UNLESS OTHERWISE SHOWN.
- GEOTECHNICAL BORINGS SHOWN IN APPROXIMATE LOCATIONS FOR INFORMATIONAL PURPOSES.

**KEY NOTES:**

- GAS MAIN TO BE RELOCATED BY UTILITY COMPANY PRIOR TO CONSTRUCTION.
- PROVIDE AND INSTALL PIPE STUB-OUT FOR FUTURE LATERAL CONNECTION INTO MANHOLE IN ACCORDANCE WITH C999 ON SHT CD-8.
- GRAVITY SEWER PIPE MATERIAL TYPE SHALL BE MINIMUM PVC SDR 35. PIPE DIAMETER TO BE 8-INCHES.

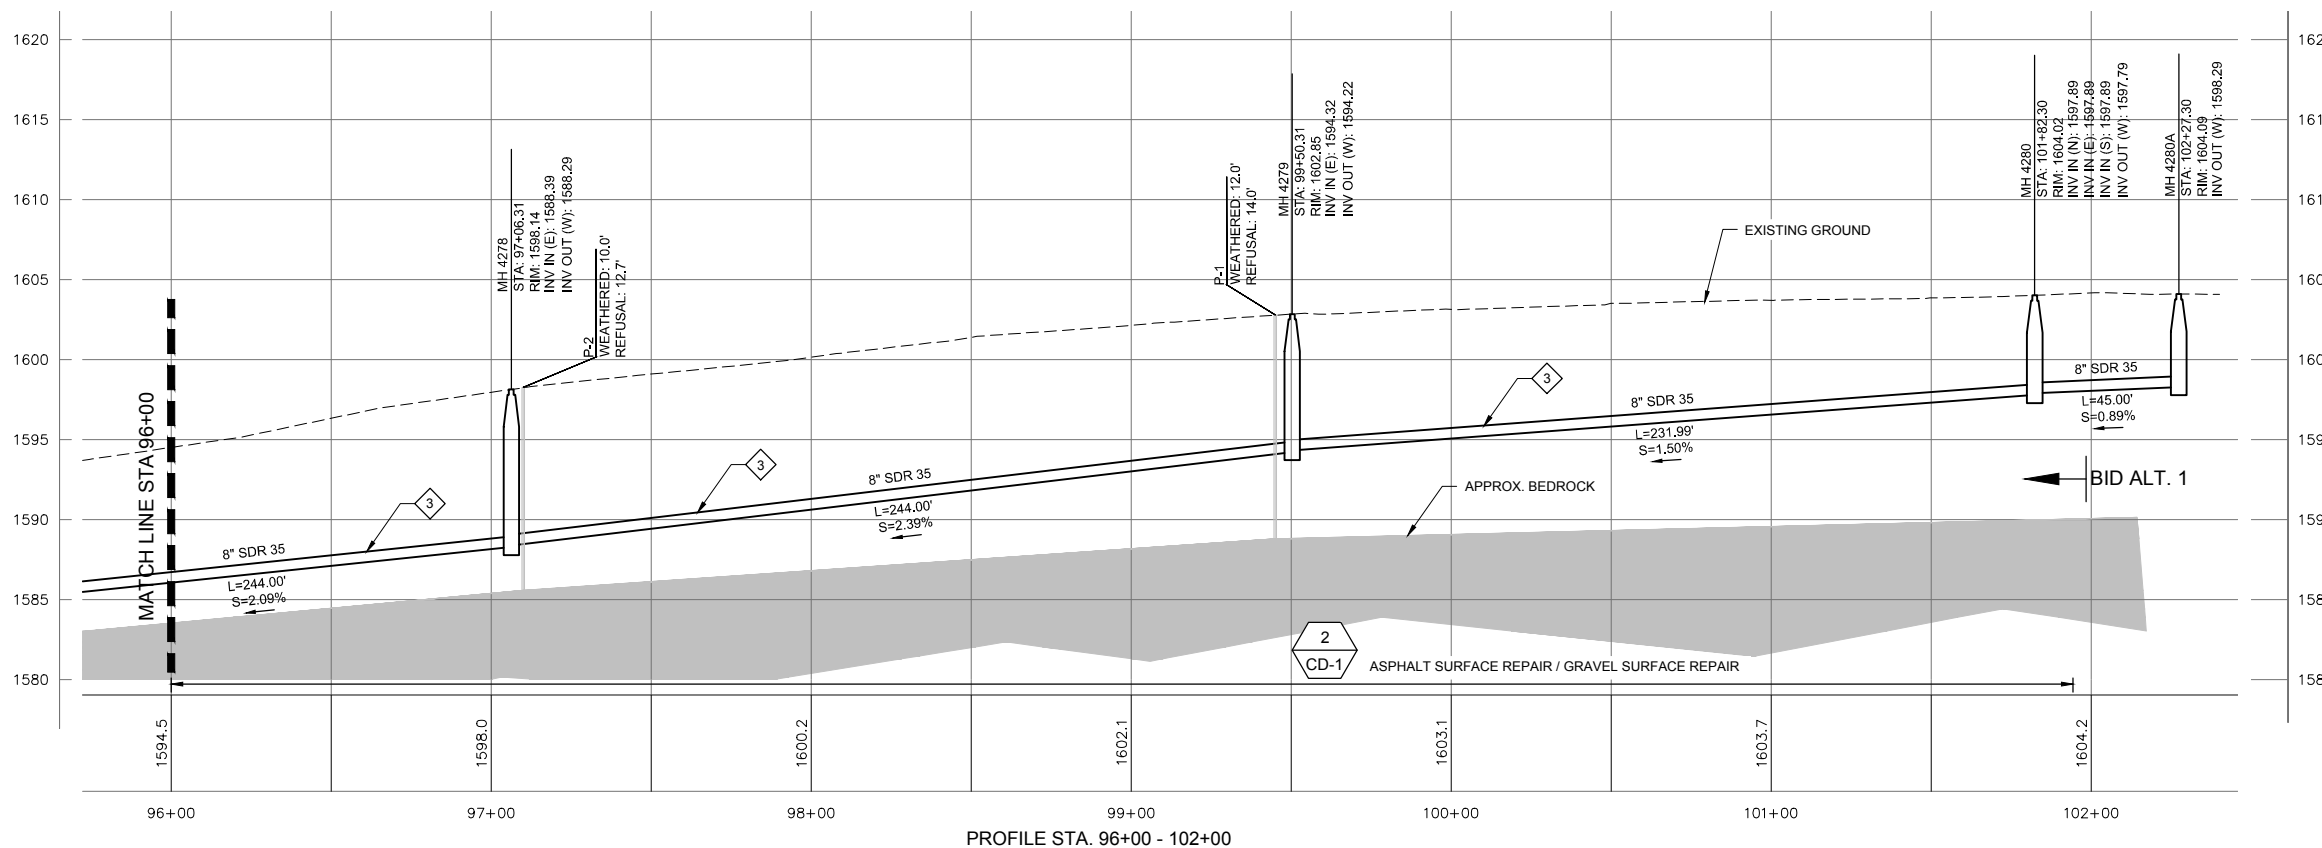

HORIZ. SCALE: 1" = 30'  
VER. SCALE: 1" = 10'  
(VERIFY PER SHEET SIZE)

Path: E:\Projects\1810020 Phase I\CD\BIB\BIB Lewiston Profiles.dwg File Name: AB Lewiston Profiles.dwg Plot Date: 12/22/2019 10:22 AM Drawn

NO.	REVISION	BY	DATE	DESIGN
				LCH
				DRAWN OTW
				CHECKED LMD
				APPROVED



**RECORD DRAWING**

THESE RECORD DRAWINGS HAVE BEEN PREPARED BASED IN PART ON INFORMATION PROVIDED BY OTHERS

THIS DRAWING WAS PREPARED ONLY FOR THE PROJECT AND SITE SPECIFICALLY IDENTIFIED HEREON AND IS NOT TO BE USED ELSEWHERE



**ENGINEERING AND ENVIRONMENTAL SOLUTIONS**

111 MAIN ST. SUITE 175  
LEWISTON, IDAHO 83501  
208.780.3990

IDAHO OFFICES  
BOISE · LEWISTON · COEUR D'ALENE

**EAST ORCHARDS SEWER EXPANSION**


LEWISTON, IDAHO

STA 96+00 - 101+92.34

VERIFY SCALE	
BAR IS ONE INCH ON FULL SIZE DRAWING	1"
PROJECT :	181.0020
DATE :	11/19/2019
DRAWING NO.	C-15



Path: E:\Projects\111 Lewiston - 1810020 Phase I\CD\1 Lewiston\_City\_Details.dwg File Name: Lewiston\_City\_Details.dwg Plot Date: 2/14/2018 2:13 PM Duse

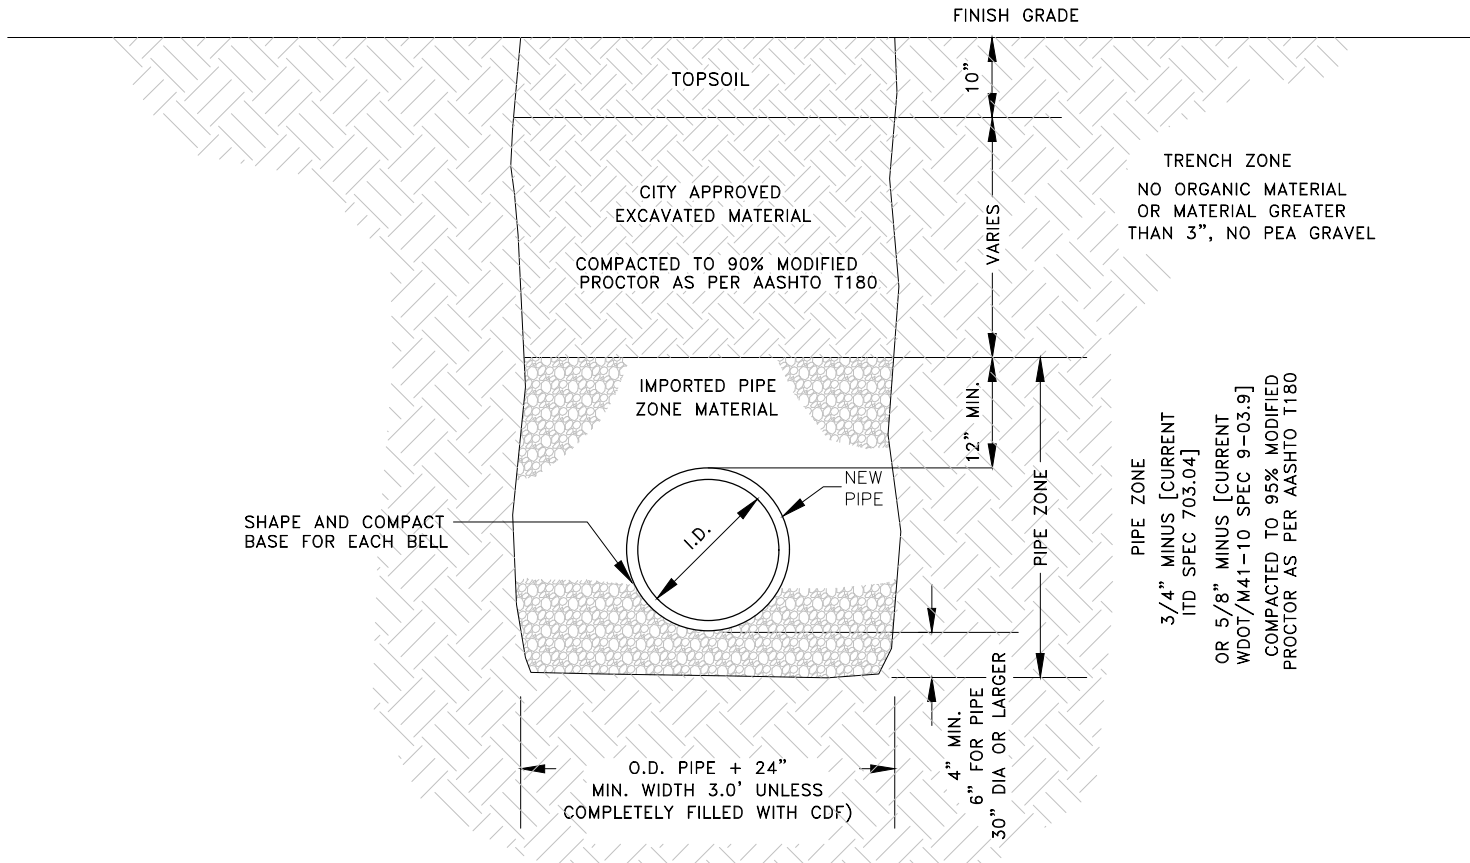


STABILIZATION MATERIAL REQUIRED IF FOUNDATION IS FOUND TO BE UNSUITABLE AS DETERMINED BY CITY ENGINEER.

CLASS 'A' BACKFILL SHALL BE USED IN AREAS NOT CURRENTLY BENEATH ASPHALT PAVEMENT.

**NOTES:**

1. CONTRACTOR SHALL COMPLY WITH THE MOST CURRENT OSHA REQUIREMENTS FOR EXCAVATIONS.
2. CLASS 'A' BACKFILL SHALL COMPLY WITH THE REQUIREMENTS OF THE CITY'S STANDARD CONSTRUCTION SPECIFICATIONS.
3. TRENCH MATERIAL SHALL BE PLACED IN MAX. 6" LIFTS.
4. ANY ALTERATIONS TO THIS STANDARD MUST HAVE WRITTEN APPROVAL BY CITY ENGINEER.

1 BACKFILL - CLASS 'A'  
- NOT TO SCALE

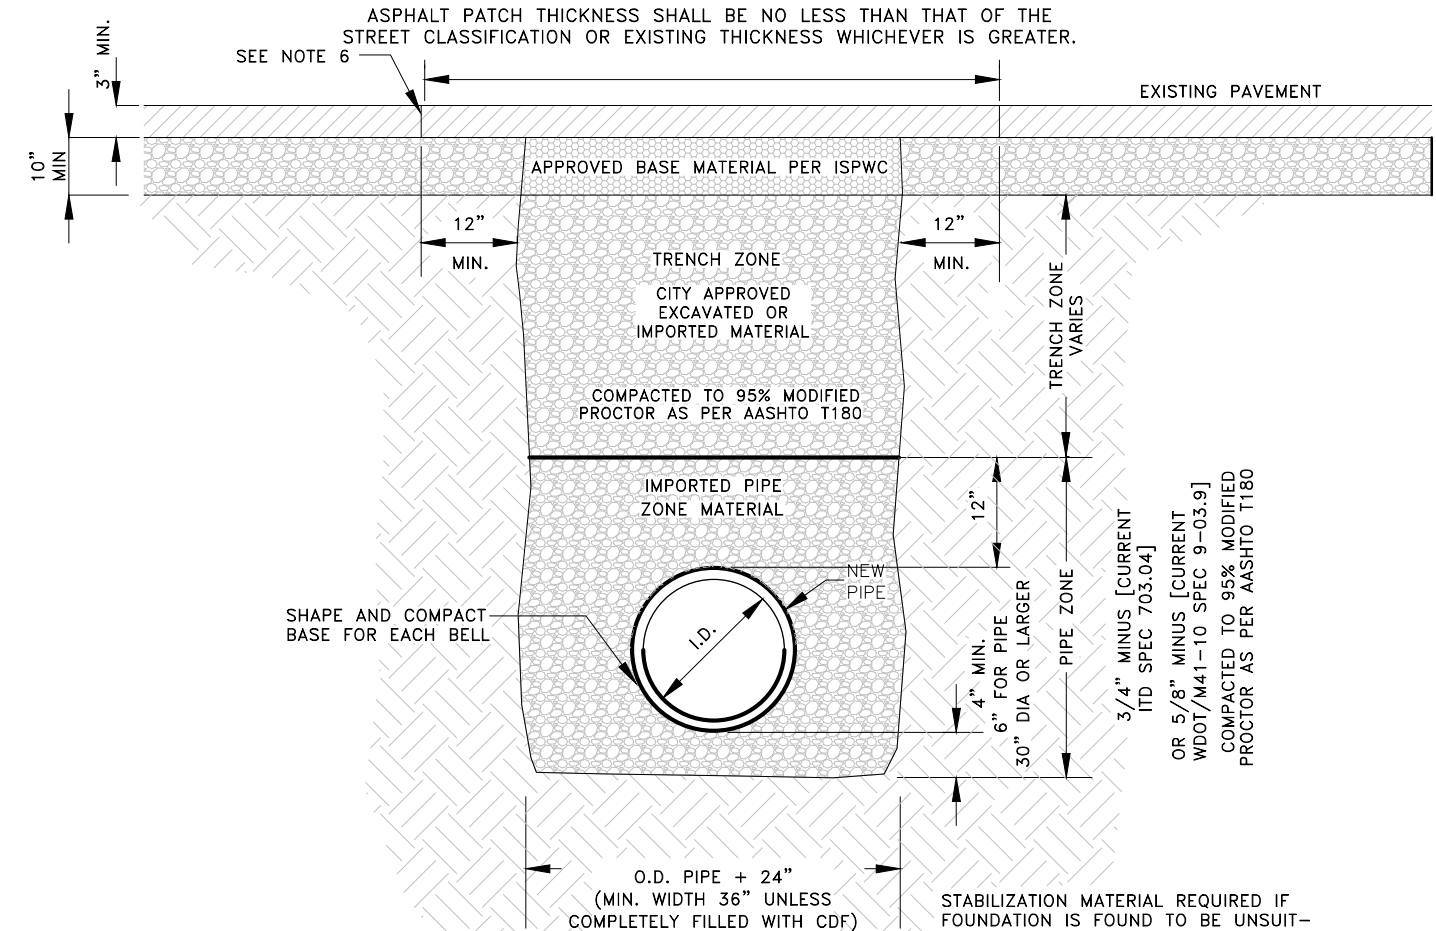


**NOTES:**

1. CONTRACTOR SHALL COMPLY WITH THE MOST CURRENT OSHA REQUIREMENTS FOR EXCAVATIONS.
2. ALL TRENCHES EXCAVATED WITHIN EXISTING PAVED STREETS SHALL BE BACKFILLED AND SURFACED THE SAME DAY WITH AN APPROVED BASE MATERIAL - TO BE REPLACED WITH THE CITY'S STANDARD HOT MIX ASPHALT SURFACING AS SOON AS SCHEDULING ALLOWS; UNLESS SPECIFICALLY APPROVED OTHERWISE BY THE CITY ENGINEER.
3. THE NEW ASPHALT PATCH SHALL MATCH THE EXISTING PAVEMENT GRADE. ACROSS THE WIDTH OF THE TRENCH THE NEW SURFACE SHALL BE FLUSH OR UP TO 1/4" ABOVE THE EXISTING PAVEMENT GRADE.
4. EXISTING PAVEMENT SHALL BE SAWCUT FULL DEPTH AND IN CONTINUOUS, STRAIGHT LINES. BROKEN EDGES WILL NOT BE ALLOWED. PAVEMENT CUTS SHALL BE 'TACKED' IMMEDIATELY PRIOR TO INSTALLATION OF THE HOT MIX PATCH.
5. AFTER BACKFILLING TRENCH REMOVE ALL BROKEN OR LOOSE ASPHALT OR CONCRETE BEYOND THE INITIAL TRENCH.
6. PATCH CANNOT OVERLAP ANOTHER PARALLEL PATCH AND CANNOT LEAVE EXISTING ASPHALT LESS THAN 36" WIDE.
7. JOINTS TO BE TACKED AND SANDED WITH EMULSIFIED TACK.
8. ANY ALTERATIONS TO THIS STANDARD MUST HAVE WRITTEN APPROVAL BY CITY ENGINEER.

CLASS 'F' EXISTING STREETS BACKFILL SHALL BE USED IN AREAS WHERE ASPHALT PAVEMENT CONCRETE CURB, SIDEWALK, DRIVEWAY, GRAVEL SURFACING WILL BE REPLACED.

2 BACKFILL - CLASS 'F'  
- NOT TO SCALE

NO.	REVISION	BY	DATE	DESIGN

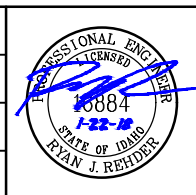


ENGINEERING AND ENVIRONMENTAL SOLUTIONS  
111 MAIN ST. SUITE 175  
LEWISTON, IDAHO 83501  
208.780.3990  
IDAHO OFFICES  
BOISE · LEWISTON · COEUR D'ALENE

**EAST ORCHARDS SEWER EXPANSION**  
LEWISTON, IDAHO

CIVIL DETAILS

VERIFY SCALE	BAR IS ONE INCH ON FULL SIZE DRAWING
PROJECT :	181.0020.00
DATE :	1/22/2018
DRAWING NO.	CD-1



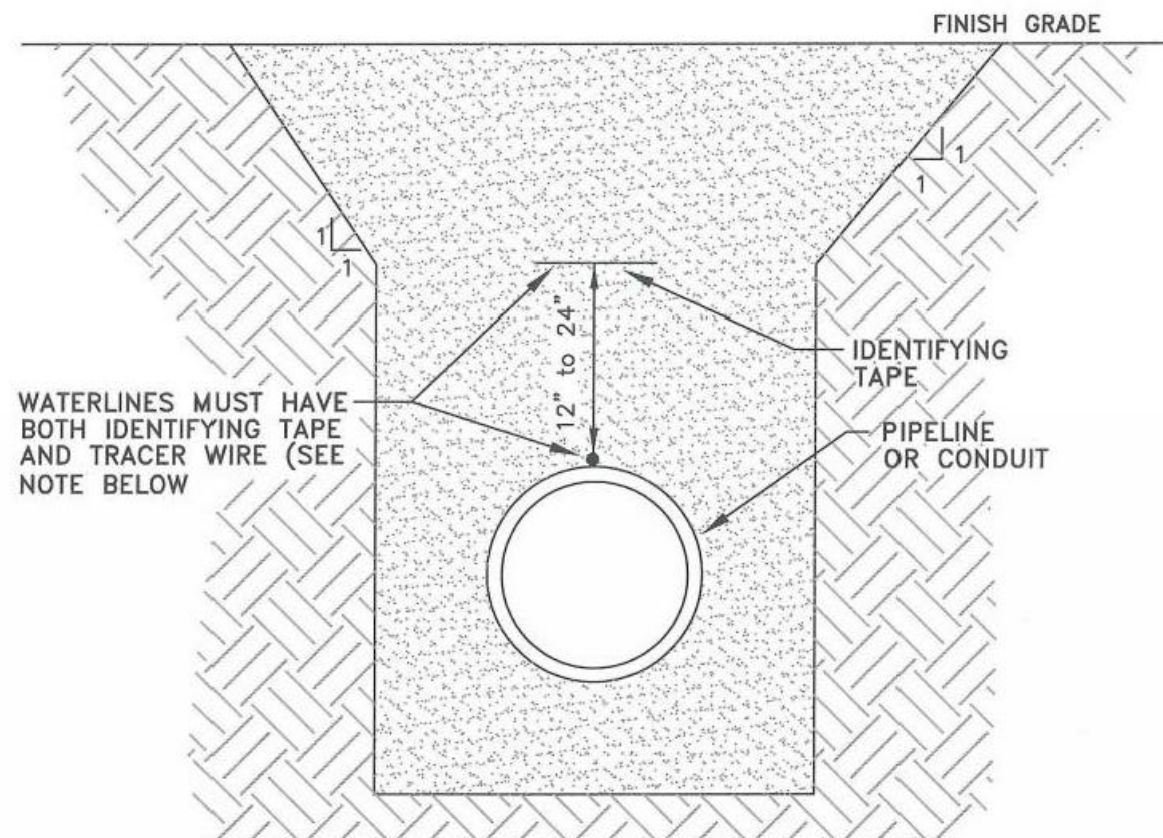

WATERLINES MUST HAVE BOTH IDENTIFYING TAPE AND TRACER WIRE (SEE NOTE BELOW)


TYPE	COLOR	SIZE	DETECTABLE	IMPRINT
WATER	BLUE	3"	NO	CAUTION BURIED WATER LINE BELOW

NO. 12 AWG. COPPER TRACER WIRE INSULATED WITH 30 MIL OF HIGH DENSITY POLYETHYLENE (HDPE) CLASSIFIED AS HIGH MOLECULAR WEIGHT POLYETHYLENE (HMWPE) IN 500 FT REELS. WIRE SHALL BE ATTACHED TO WATERLINE AT INTERVALS NOT TO EXCEED 15 FT SEPARATION.

ALL SPLICES SHALL BE 3M DIRECT BURY SPLICE KIT DBR/Y-6 AND CONTRACTOR SHALL CONDUCT A CONDUCTIVITY TEST ON ALL LOCATING WIRE SPLICES.

TYPE	COLOR	SIZE	DETECTABLE	IMPRINT
STORM SEWER	GREEN	3"	NO	CAUTION BURIED STORM SEWER LINE BELOW
SANITARY SEWER	GREEN	3"	NO	CAUTION BURIED SEWER LINE BELOW
GAS	YELLOW	3"	NO	CAUTION BURIED GAS LINE BELOW
CABLE	ORANGE	3"	NO	CAUTION BURIED CABLE LINE BELOW
ELECTRICAL	RED	3"	NO	CAUTION BURIED ELECTRIC LINE BELOW

3 IDENTIFYING TAPE DETAIL  
NOT TO SCALE

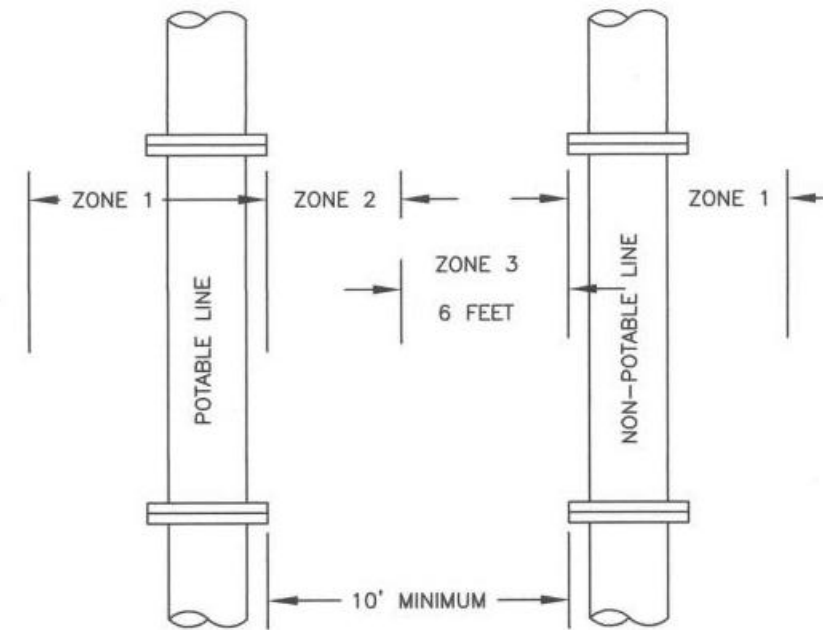

**HORIZONTAL REQUIREMENTS:**  
**ZONE 1: MORE THAN 10 FEET APART**  
 NO SPECIAL REQUIREMENTS  
**ZONE 2: FROM 6 TO 10 FEET APART**  
 A. No special requirements for service lines.  
 B. Potable and non-potable mains separated by at least 6 feet at outside walls and  
 i. Potable mains higher in elevation than the non-potable mains and  
 ii. Non-potable mains constructed to with potable water class pipe and pressure tested for water tightness.  
**ZONE 3: CLOSER THAN 6 FEET APART**  
 NOT ALLOWED

**VERTICAL REQUIREMENTS:**

**ZONE 1: POTABLE LINE 18" OVER NON-POTABLE LINE**

Potable water and non-potable mains and service lines must be separated by at least 18 inches and

One full, uncut length of non-potable pipe must be centered on the crossing so that the joints are as far as possible from the crossing.

**ZONE 2: POTABLE LINE < 18" OVER NON-POTABLE LINE**

One full, uncut length of non-potable pipe must be centered on the crossing so that the joints are as far as possible from the non-potable line and either a or b

a) Non-potable line must be constructed to potable water pipe standards and pressure tested for water tightness for a horizontal distance of ten feet on both sides of the crossing.

b) Non-potable or potable line must be cased in a larger diameter carrier pipe for a horizontal distance of ten feet on both sides of the crossing, with no joints.

**ZONE 3: POTABLE WATER < 18" UNDER NON-POTABLE LINE**


Same requirements as Zone 2 except the non-potable line must also be supported above the crossing to prevent settling.

**ZONE 4: POTABLE WATER 18" UNDER NON-POTABLE LINE**

Same requirements as Zone 1 except the non-potable line must also be supported above the crossing to prevent settling.

**GENERAL NOTES:**

- Sewage force mains shall have at least ten feet of horizontal separation and eighteen inches of clearance from potable water mains. Zone 2 and 3 placements are prohibited.
- Separation requirements also apply to potable and non-potable service lines controlled by the system owner and extending the main line to the property line, service meter, or cleanout.

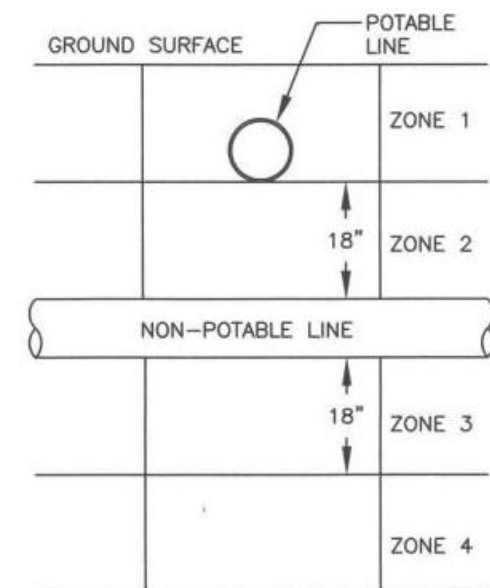

4 POTABLE & NON-POTABLE WATERLINE SEPARATION  
NOT TO SCALE

Path: E:\Projects\111 Lewiston - 1810020 Phase I\CD2\111 Lewiston - City Date.dwg File Name: Lewiston\_City Date.dwg Plot Date: 2/14/2018 2:13 PM Duce

NO.	REVISION	BY	DATE	DESIGN
				DRAWN
				MWW
				CHECKED
				APPROVED



ENGINEERING AND ENVIRONMENTAL SOLUTIONS

111 MAIN ST. SUITE 175  
LEWISTON, IDAHO 83501  
208.780.3990

IDAHO OFFICES  
BOISE · LEWISTON · COEUR D'ALENE



EAST ORCHARDS SEWER EXPANSION  
LEWISTON, IDAHO

CIVIL DETAILS

VERIFY SCALE	
BAR IS ONE INCH ON FULL SIZE DRAWING	1"
PROJECT :	181.0020.00
DATE :	1/22/2018
DRAWING NO.	CD-2





PROPERTY OWNER IS RESPONSIBLE FOR THE WASTEWATER LATERAL INCLUDING THE TAP TO THE MAIN.

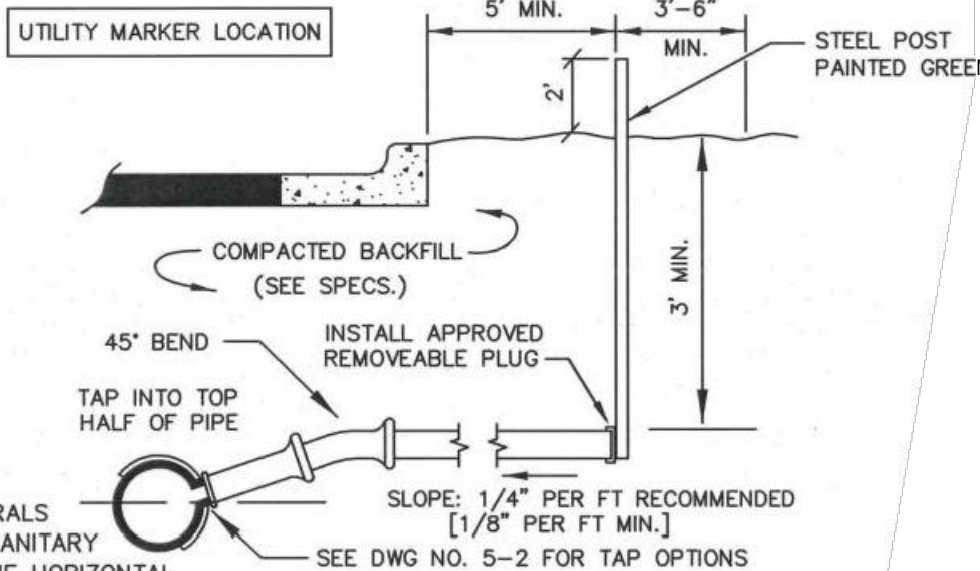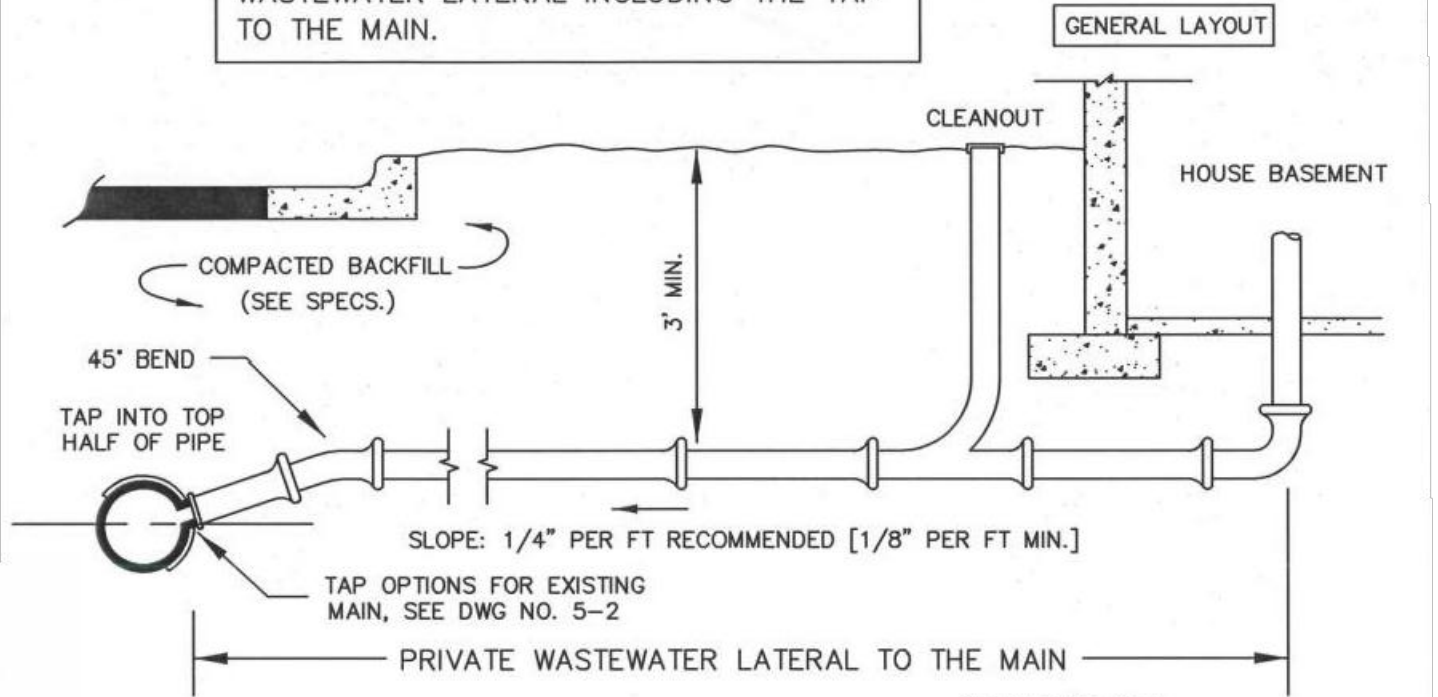

- NOTE:**
1. WASTEWATER SERVICE LATERALS SHALL BE CONNECTED TO SANITARY MAIN AT A POINT ABOVE THE HORIZONTAL CENTERLINE OF THE PIPE BUT NOT DIRECTLY TO THE TOP OF THE MAIN.
  2. ALL CONNECTIONS AND WASTEWATER LINES CONNECTING WITH THE PUBLIC SYSTEM SHALL BE WATERTIGHT AND NO LESS THAN 4" IN DIAMETER FOR ALL NEW CONNECTIONS EXCEPT FOR 2" DIAMETER PRESSURE CONNECTIONS TO GRAVITY MAINS.
  3. FLOOR DRAINS SUBJECT TO BACK PRESSURE OR BASEMENT DRAINS LESS THAN 1' ABOVE THE NEAREST ADJACENT SEWER MANHOLE SHALL BE EQUIPPED WITH AN APPROVED BACKWATER VALVE (SEE CITY SEC. 36-43).

5 WASTEWATER PRIVATE SERVICE CONNECTION  
NOT TO SCALE

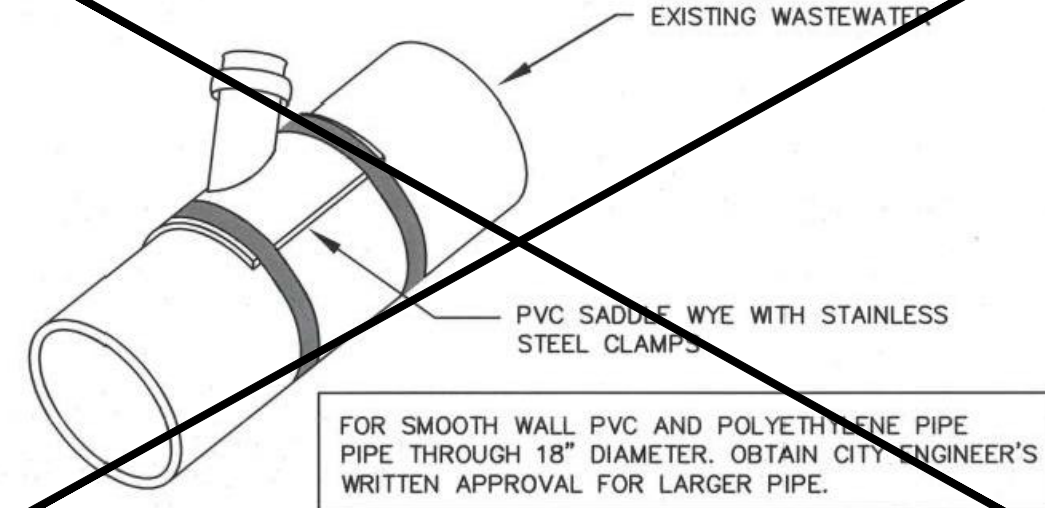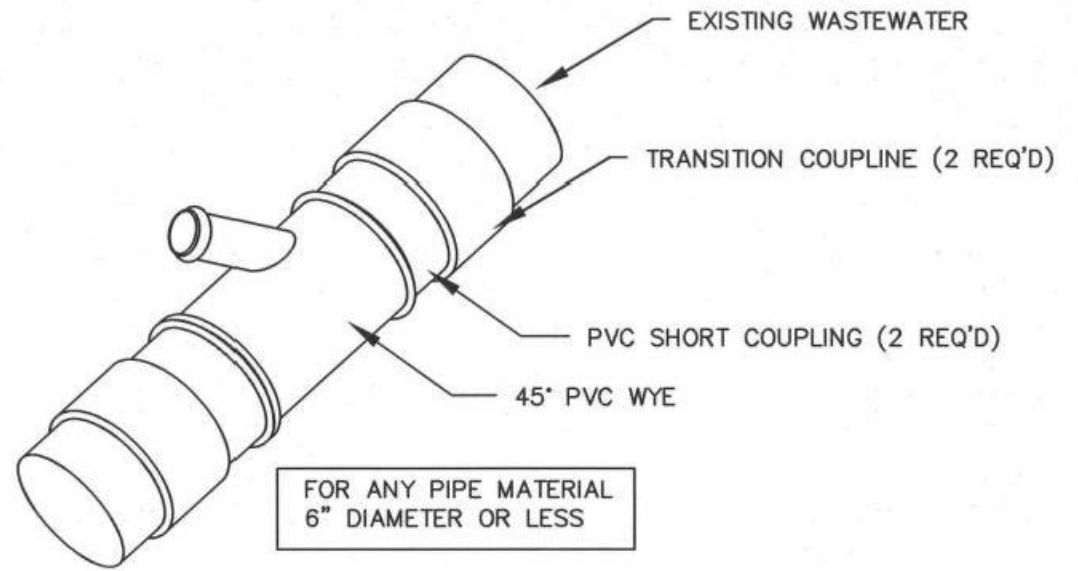


- NOTES**
1. WASTEWATER SERVICE LATERALS SHALL BE CONNECTED TO SANITARY MAIN AT A POINT ABOVE THE HORIZONTAL CENTERLINE OF THE PIPE BUT NOT DIRECTLY TO THE TOP OF THE MAIN.
  2. FOR SANITARY MAIN PIPE OF 6" DIAMETER AND LARGER USE ROMAC STYLE 'CB' WASTEWATER SADDLE.

6 WASTEWATER SERVICE TAP OPTIONS DETAIL  
NOT TO SCALE

Path: E:\Projects\111 Lewiston - 1810020 Phase I\CD\111 Lewiston - 1810020 City Det.dwg Plot Date: 2/14/2018 2:14 PM Duse

NO.	REVISION	BY	DATE	DESIGN

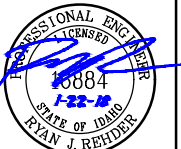

ENGINEERING AND ENVIRONMENTAL SOLUTIONS  
111 MAIN ST. SUITE 175  
LEWISTON, IDAHO 83501  
208.780.3990  
IDAHO OFFICES  
BOISE · LEWISTON · COEUR D'ALENE


**EAST ORCHARDS SEWER EXPANSION**  
LEWISTON, IDAHO  
CIVIL DETAILS

VERIFY SCALE	BAR IS ONE INCH ON FULL SIZE DRAWING
PROJECT:	181.0020.00
DATE:	1/22/2018
DRAWING NO.	CD-3



SEE CONCRETE MANHOLE COLLAR DETAIL, DWG NO. 5-6

SEE MH FRAME & COVER, DWG NO. 5-7  
VERIFY "SEWER" UTILITY LABEL LETTERING ON COVER.

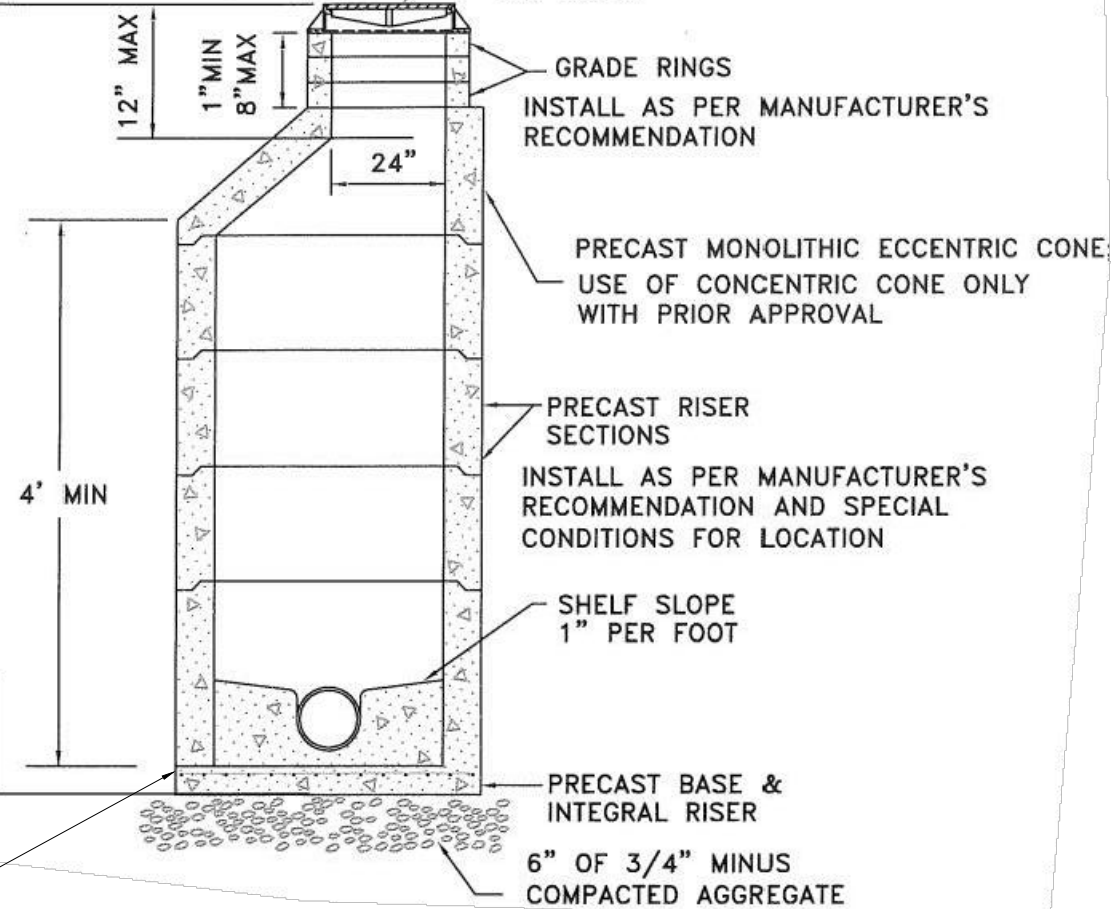


- NOTES:
1. ALL UNITS TO MEET OR EXCEED THE REQUIREMENTS OF ASTM C478/AASHTO M199. JOINTS SHALL BE RUBBER GASKET CONFORMING TO ASTM C443 AND SHALL BE GROUTED FROM THE INSIDE. LIFT HOLES SHALL BE GROUTED FROM THE OUTSIDE AND INSIDE OF THE MANHOLE.
  2. PRECAST BASES SHALL BE FURNISHED WITH CUTOUTS OR KNOCKOUTS. KNOCKOUTS SHALL HAVE A WALL THICKNESS OF 2" MINIMUM.
  3. CONNECTION TO MANHOLE SHALL BE MADE USING RESILIENT CONNECTOR CONFORMING TO ASTM C-923 SUCH AS KOR-N-SEAL, A-LOK OR APPROVED EQUAL.
  4. RISERS, UNIT SECTIONS AND THE FRAME SHALL NOT BE MORE THAN ONE INCH OUT OF ALIGNMENT WITH INSIDE EDGE OF MANHOLE.
  5. PRESSURE TESTING IS REQUIRED FOR ALL INSTALLATIONS.
  6. SEE DWG NO 5-6 FOR CONCRETE MANHOLE COLLAR.
  7. MAXIMUM SPACING BETWEEN MANHOLES IS 400 FEET.
  8. PROVIDE ANTI-FLOATATION FOOT BASE FOR ALL MANHOLES WITH RIM TO INVERT ELEVATION DISTANCES GREATER THAN TEN(10)FEET.

7 WASTEWATER TYPE 1 MANHOLE  
NOT TO SCALE

SEE CONCRETE MANHOLE COLLAR DETAIL, DWG NO. 5-6

SEE MH FRAME & COVER, DWG NO. 5-7  
VERIFY "SEWER" UTILITY LABEL LETTERING ON COVER.

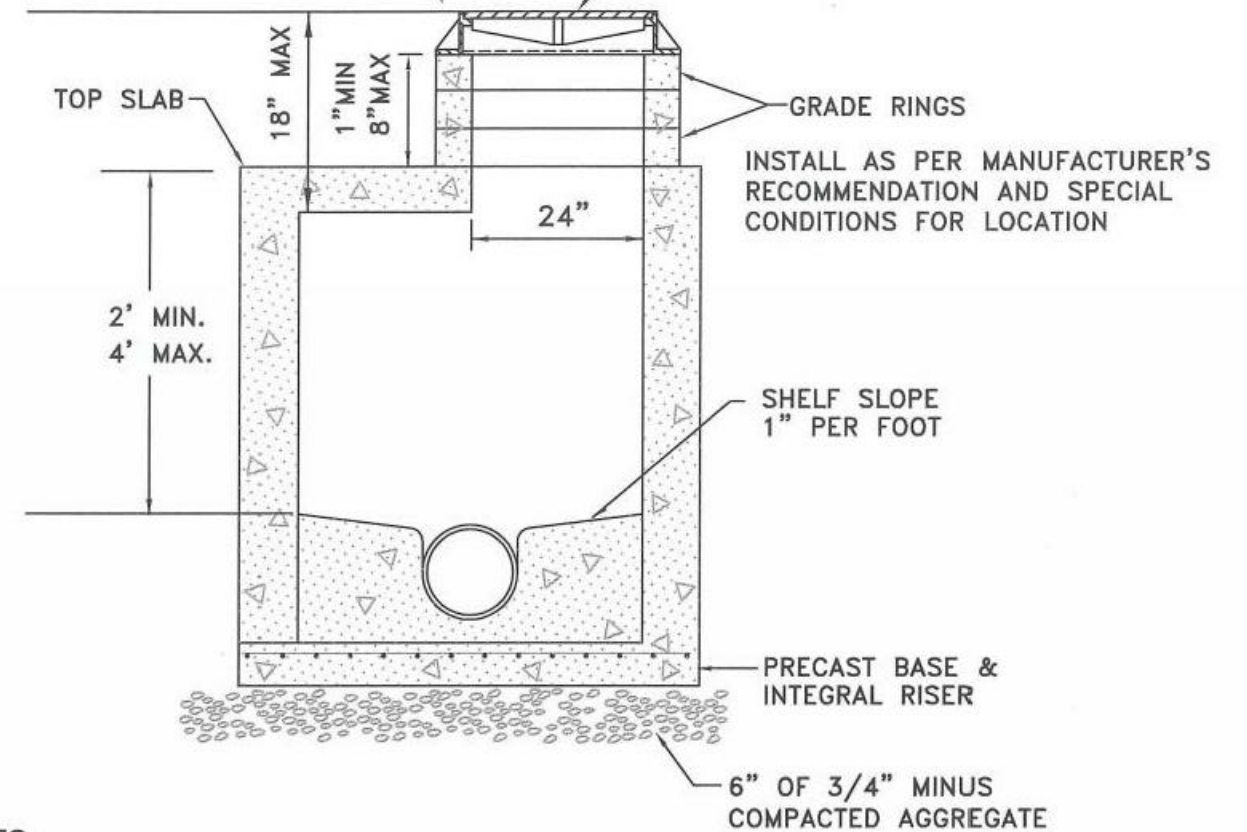


NOTES:

1. INSTALLATION OF FLAT TOP SLABS MUST HAVE WRITTEN APPROVAL FROM CITY ENGINEER.
2. ALL UNITS TO MEET OR EXCEED THE REQUIREMENTS OF ASTM C478/AASHTO M199. JOINTS SHALL BE RUBBER GASKET CONFORMING TO ASTM C443 AND SHALL BE GROUTED FROM THE INSIDE. LIFT HOLES BE GROUTED FROM THE OUTSIDE AND INSIDE OF THE MANHOLE.
3. PRECAST BASES SHALL BE FURNISHED WITH CUTOUTS OR KNOCKOUTS. KNOCKOUTS SHALL HAVE A WALL THICKNESS OF 2" MINIMUM.
4. CONNECTION TO MANHOLE SHALL BE MADE USING RESILIENT CONNECTOR CONFORMING TO ASTM C-923 SUCH AS KOR-N-SEAL, A-LOK OR APPROVED EQUAL.
5. RISERS, UNIT SECTIONS AND THE FRAME SHALL NOT BE MORE THAN ONE INCH OUT OF ALIGNMENT WITH THE MANHOLE BASE; PIPES SHALL BE FLUSH WITH INSIDE EDGE OF MANHOLE.
6. PRESSURE TESTING IS REQUIRED FOR ALL INSTALLATIONS.
7. SEE DWG NO 5-6 FOR CONCRETE MANHOLE COLLAR.

8 WASTEWATER TYPE 1A MANHOLE (SHALLOW MANHOLE)  
NOT TO SCALE

Path: E:\Projects\1810020 Phase I\CD\DWG\LEWISTON\_City\_Details.dwg File Name: Lewiston\_City\_Details.dwg Plot Date: 2/14/2018 2:14 PM D:\user

NO.	REVISION	BY	DATE	DESIGN
				DRAWN
				MWW
				CHECKED
				APPROVED


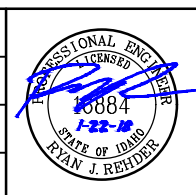


ENGINEERING AND ENVIRONMENTAL SOLUTIONS  
111 MAIN ST. SUITE 175  
LEWISTON, IDAHO 83501  
208.780.3990  
IDAHO OFFICES  
BOISE · LEWISTON · COEUR D'ALENE

EAST ORCHARDS SEWER EXPANSION  
LEWISTON, IDAHO  
CIVIL DETAILS

VERIFY SCALE	BAR IS ONE INCH ON FULL SIZE DRAWING
PROJECT :	181.0020.00
DATE :	1/22/2018
DRAWING NO.	CD-4



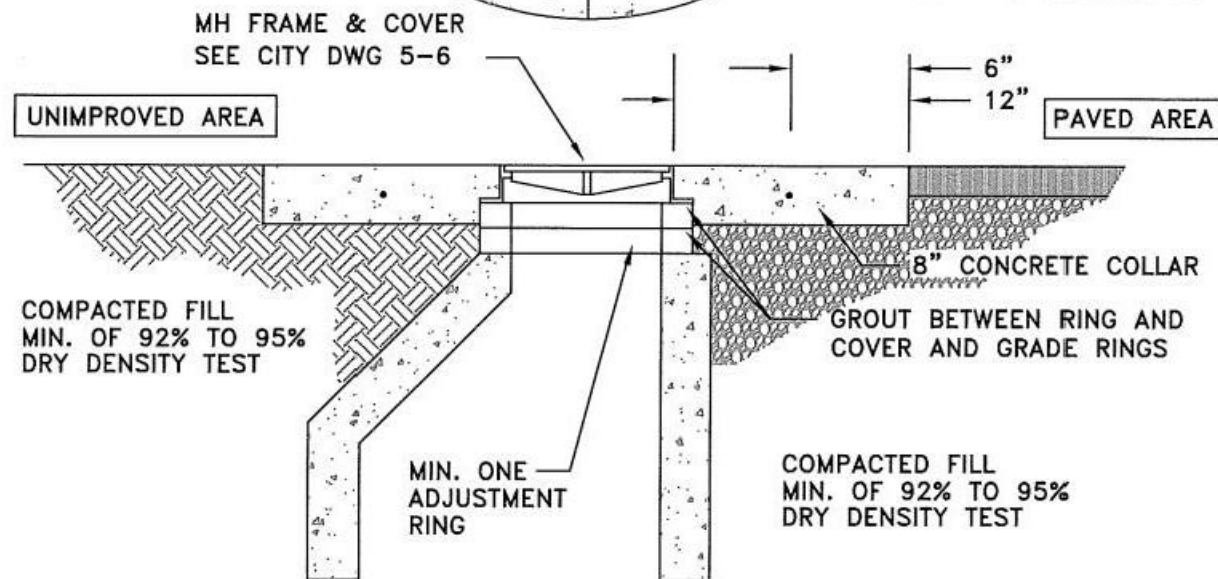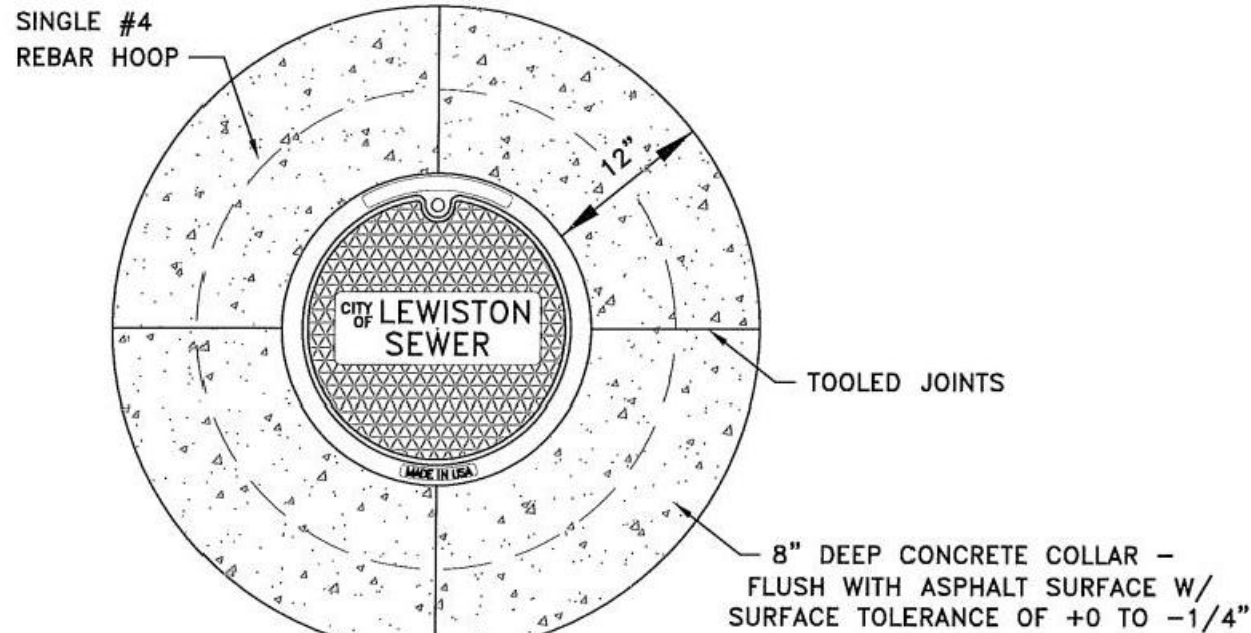


**NOTES:**


1. A CIRCULAR-SHAPED CONCRETE COLLAR IS REQUIRED ON ALL INSTALLATIONS; IN BOTH PAVED OR UNIMPROVED AREAS. INSTALL A 8" THICK CONCRETE COLLAR THAT SHALL BE FLUSH WITH THE ASPHALT SURFACE WITH A SURFACE TOLERANCE OF +0 TO -1/4".
2. CONCRETE SHALL BE 3,000 PSI MIN. AT 28 DAYS, WATER/CEMENT RATIO SHALL BE 0.5, 3" MAX. SLUMP AND 3% TO 6% ENTRAINED AIR WITH ONE #4 REBAR HOOP. FIBER-REINFORCED CONCRETE (ADDED PER MANUFACTURER'S RECOMMENDATIONS) MAY BE USED IN LIEU OF #4 REBAR.
3. ALL EDGES WILL BE SEALED WITH CSSI OR APPROVED EQUAL; ALL TOP EDGES WILL BE TACKED AND SAND SEALED.
4. UTILITY FRAMES AND LIDS ARE PREFERRED OUTSIDE OF WHEEL PATH, WHERE POSSIBLE.

SIMILAR TO CITY STD NO. 6-4


9 WASTEWATER CONCRETE MANHOLE COLLAR  
NOT TO SCALE

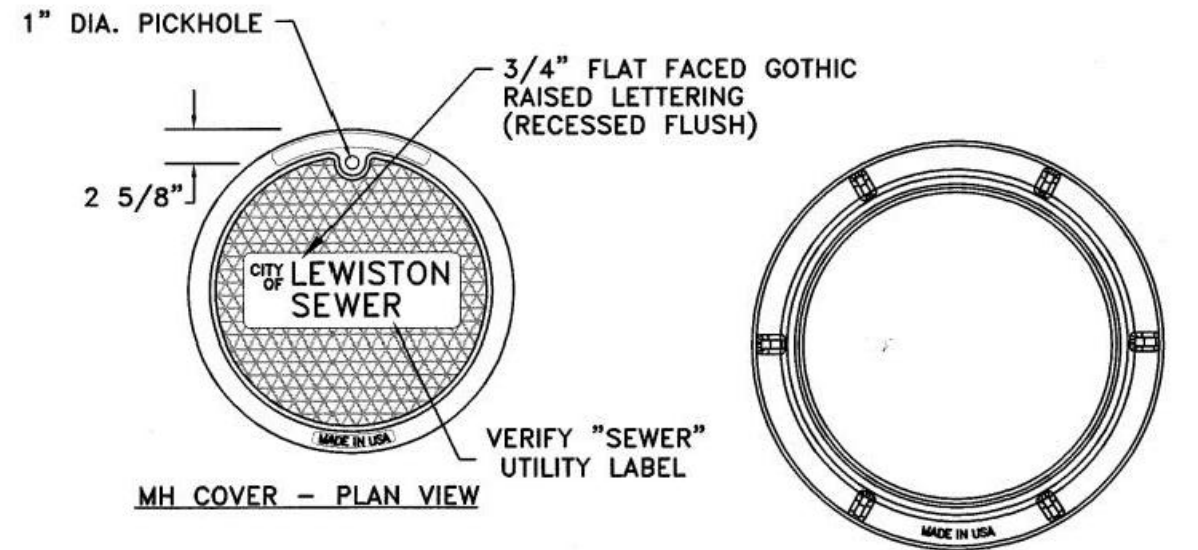


MH COVER - PLAN VIEW

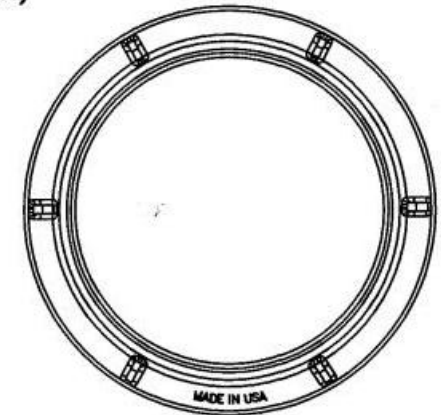

MH FRAME - PLAN VIEW

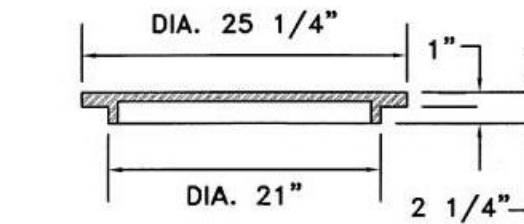

MH COVER - SECTION VIEW

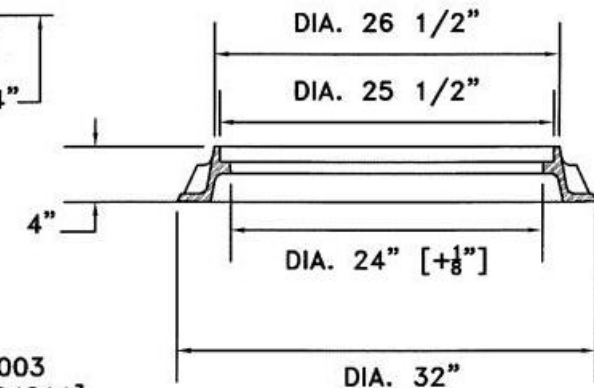

MH FRAME - SECTION VIEW

**NOTES:**

1. MANHOLE FRAME [D&L FOUNDRY A-2003 OR EAST JORDON IRON WORKS #00184811] AND COVER [EJIW #00184849 OR D&L A-2010-01] OR BY OTHER MANUFACTURER WILL BE ACCEPTABLE ONLY WITH WRITTEN APPROVAL FROM PUBLIC WORKS DEPT.; VERIFY "SEWER" UTILITY LABEL LETTERING ON COVER.
2. COVER MATERIAL SPECIFICATION GRAY IRON (ASTM A48 CL35B)
3. IN AREAS OF HIGH STORMWATER INFILTRATION, LIDS SHALL HAVE GASKETED AND BOLTED.

10 WASTEWATER MANHOLE FRAME AND COVER  
NOT TO SCALE

Path: E:\Projects\1810020 Phase I\CD\DWG\LEWISTON\_City\_Details.dwg File Name: Lewiston\_City\_Details.dwg Plot Date: 2/14/2018 2:14 PM Duse

NO.	REVISION	BY	DATE	DESIGN
				DRAWN
				MWW
				CHECKED
				APPROVED



ENGINEERING AND ENVIRONMENTAL SOLUTIONS  
111 MAIN ST. SUITE 175  
LEWISTON, IDAHO 83501  
208.780.3990  
IDAHO OFFICES  
BOISE · LEWISTON · COEUR D'ALENE


EAST ORCHARDS SEWER EXPANSION  
LEWISTON, IDAHO

CIVIL DETAILS

VERIFY SCALE	
BAR IS ONE INCH ON FULL SIZE DRAWING	1"
PROJECT :	181.0020.00
DATE :	1/22/2018
DRAWING NO.	CD-5



Path: E:\Projects\1810020 Phase I\CD\DWG\LEWISTON\_City\_Details.dwg File Name: Lewiston\_City\_Details.dwg Plot Date: 2/14/2018 2:14 PM Duse

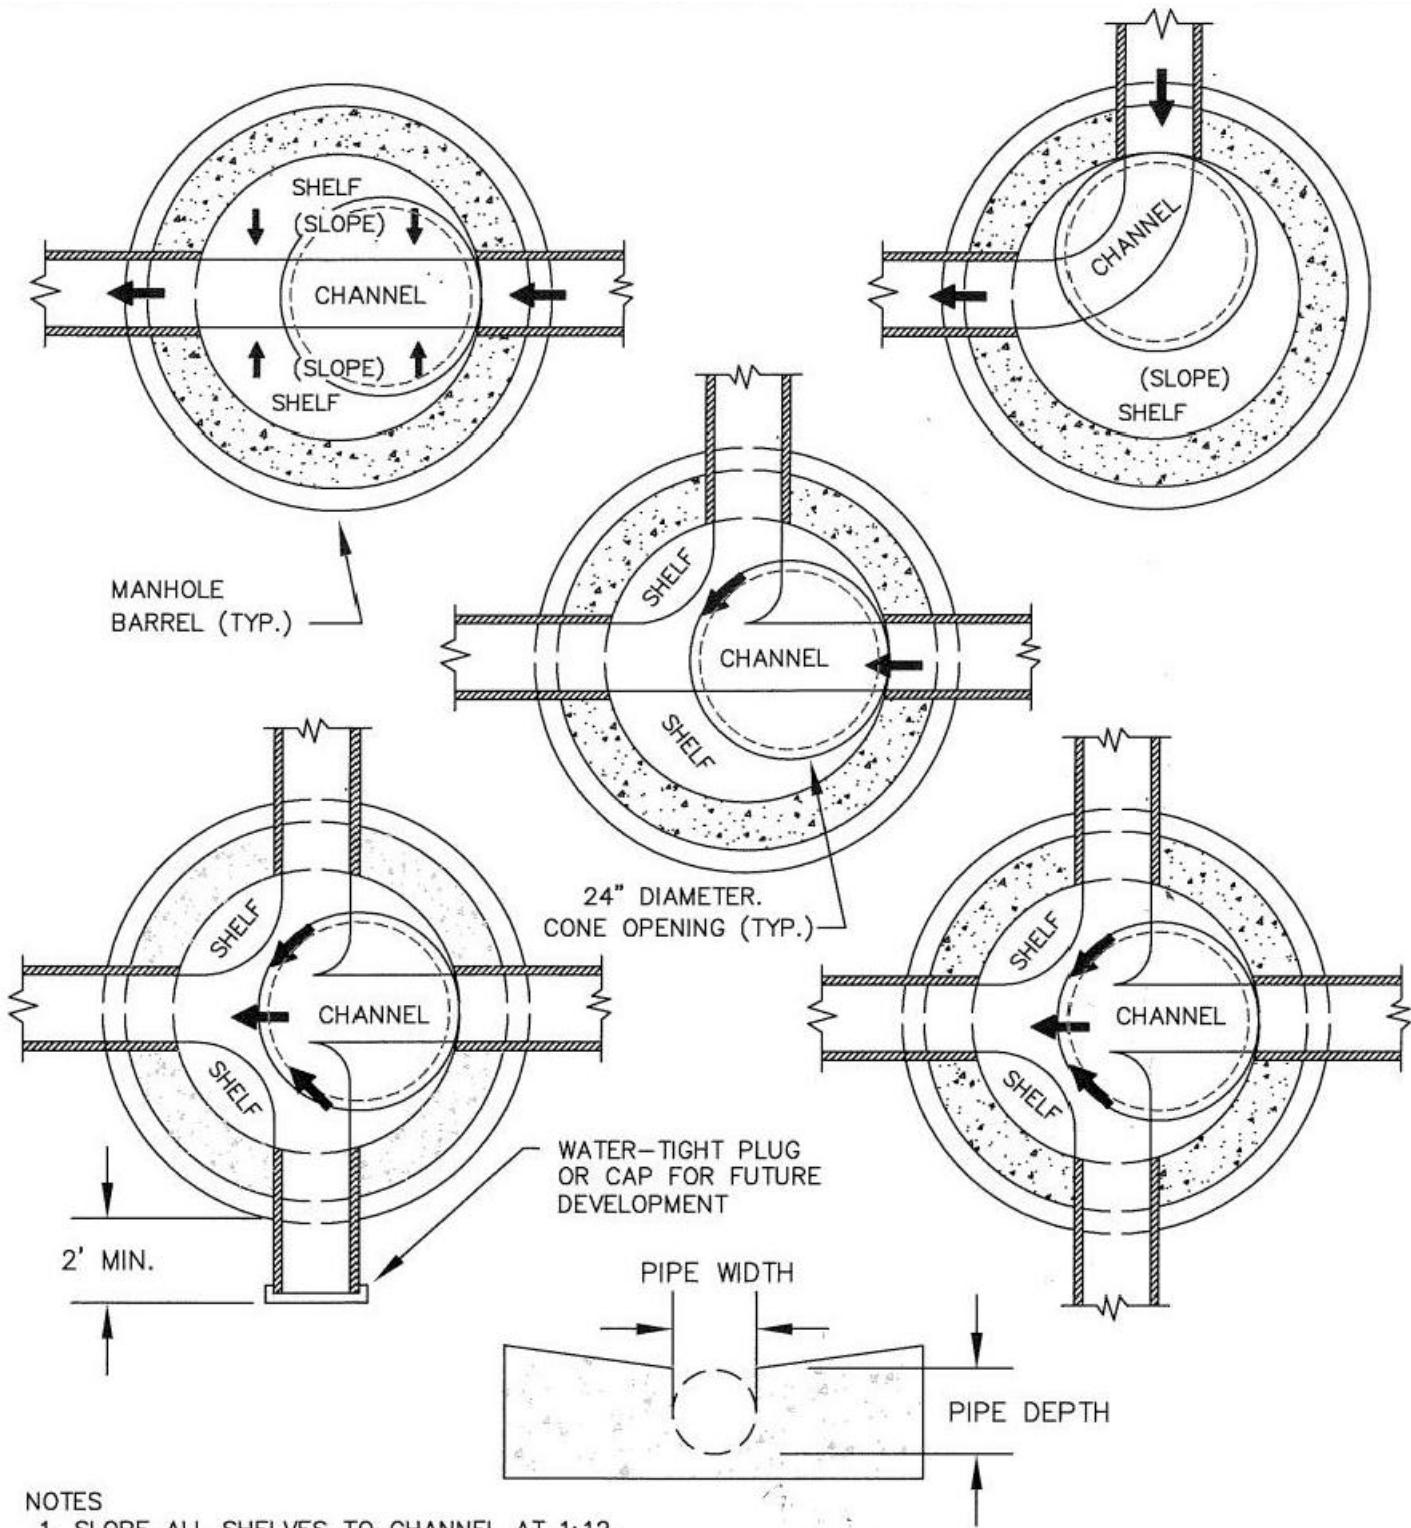

- NOTES**
1. SLOPE ALL SHELVES TO CHANNEL AT 1:12.
  2. SEE PLAN & PROFILE SHEETS FOR SLOPE OF CHANNEL.
  3. FOR PIPES OF DIFFERENT SIZES, THE TOP OF PIPE (CROWN) SHALL BE AT THE SAME ELEVATION.
  4. OFFSET CONE 24" DIAMETER OPENING CENTERED OVER UPSTREAM PIPE INVERT.

11 WASTEWATER MANHOLE CHANNEL DETAIL  
 NOT TO SCALE

NO.	REVISION	BY	DATE	DESIGN




**ENGINEERING AND ENVIRONMENTAL SOLUTIONS**  
 111 MAIN ST. SUITE 175  
 LEWISTON, IDAHO 83501  
 208.780.3990  
 IDAHO OFFICES  
 BOISE · LEWISTON · COEUR D'ALENE

**EAST ORCHARDS SEWER EXPANSION**  
 LEWISTON, IDAHO  
 CIVIL DETAILS

VERIFY SCALE	BAR IS ONE INCH ON FULL SIZE DRAWING
PROJECT :	181.0020.00
DATE :	1/22/2018
DRAWING NO.	CD-6



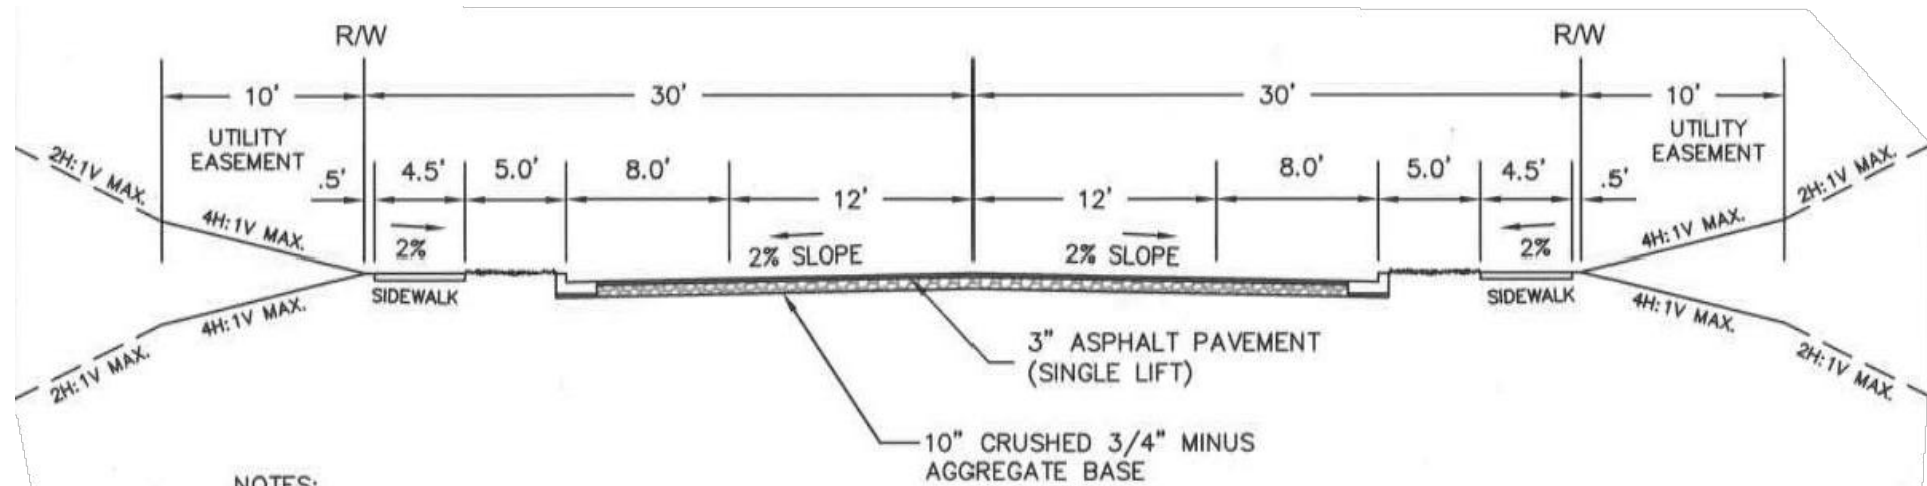


NOTES:

1. 60' RIGHT OF WAY WIDTH
2. 8% GRADE MAX
3. 200' CENTERLINE RADIUS (MIN.) - SMALLER RADIUS MAY BE ALLOWED IF CURVE IS SUPERELEVATED (REFER TO AASHTO)
4. HIGH BACK CURB ONLY
5. THE PLANTING STRIP SHALL BE MAINTAINED BY THE ADJACENT PROPERTY OWNERS.
6. CITY ENGINEER MAY REQUIRE SOIL TEST AND/OR GEOTECHNICAL ENGINEERING EVALUATION TO VERIFY LOAD BEARING CAPACITY OF SUBGRADE.
7. ADD 10' OF PAVEMENT WIDTH & RIGHT-OF-WAY WIDTH (5' EACH SIDE OF CENTERLINE WHEN BIKE LANES ARE REQUIRED)
8. TRAFFIC CALMING AND ENTRANCE FEATURES SHALL BE EVALUATED ON A CASE BY CASE BASIS; FINAL APPROVAL SHALL BE BY CITY ENGINEER.
9. ASPHALT PAVEMENT MAYBE WATER TESTED FOR PROPER DRAINAGE PRIOR TO FINAL APPROVAL.
10. CITY ENGINEER MAY REQUIRE CORING OF THE ASPHALT PAVEMENT TO VERIFY PAVEMENT THICKNESS OR DENSITY.
11. ANY VARIATION TO PROPOSED ROAD CROSS-SECTION MUST HAVE WRITTEN APPROVAL FROM CITY ENGINEER.
12. ALL TREE AND UTILITY PLACEMENT MUST MEET DWG NO. 1-1.
13. A 0.5' STRIP TO BE LOCATED BEHIND THE SIDEWALK FOR PLACEMENT OF PROPERTY PINS.

12 RESIDENTIAL COLLECTOR  
NOT TO SCALE

Path: E:\Projects\111 Lewiston\_1810020 Phase I\CD\111 Lewiston\_City Detls.dwg File Name: Lewiston\_City Detls.dwg Plot Date: 2/14/2018 2:14 PM Duse


NO.	REVISION	BY	DATE	DESIGN

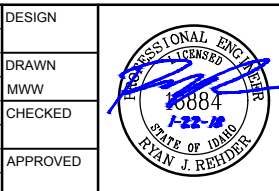

ENGINEERING AND ENVIRONMENTAL SOLUTIONS  
111 MAIN ST. SUITE 175  
LEWISTON, IDAHO 83501  
208.780.3990  
IDAHO OFFICES  
BOISE · LEWISTON · COEUR D'ALENE

EAST ORCHARDS SEWER EXPANSION  
LEWISTON, IDAHO  
CIVIL DETAILS


VERIFY SCALE	BAR IS ONE INCH ON FULL SIZE DRAWING
PROJECT :	181.0020.00
DATE :	1/22/2018
DRAWING NO.	CD-7

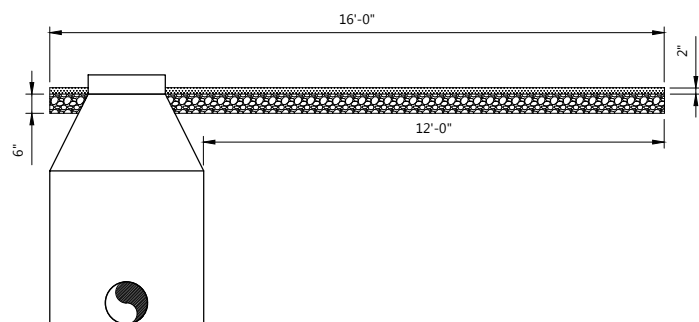

**KEY NOTES**

1. PROVIDE APPROXIMATELY 6 INCHES OF PIT RUN OR OTHER STRUCTURAL MATERIAL TO PROVIDE A ROAD BASE. OFFSET FROM OUTSIDE EDGE OF MANHOLE TO PROVIDE APPROXIMATELY 12 FEET OF CLEARANCE ALONG ONE SIDE OF MANHOLE AS SHOWN IN THE DRAWINGS TO ALLOW MAINTENANCE VEHICLES TO DRIVE PAST THE MANHOLE.
2. OVERLAY PIT RUN WITH APPROXIMATELY 2 INCHES OF WELL-GRADED 3-INCH MINUS GRAVEL TO CREATE A SURFACE SUITABLE FOR DRIVING.
3. EXTEND MANHOLE FRAME AND COVER ABOVE THE SURFACE IF THE FINISHED GRAVEL ROAD. DO NOT EXTEND HIGHER THAN 6 INCHES.
4. CONTRACTOR TO SUBMIT SIEVE ANALYSES FOR PROPOSED PIT RUN AND 3-INCH MINUS MATERIALS TO ENGINEER FOR APPROVAL PRIOR TO INSTALLATION.


**C998 OFFROAD GRAVEL ACCESSWAY**  
TYP NOT TO SCALE

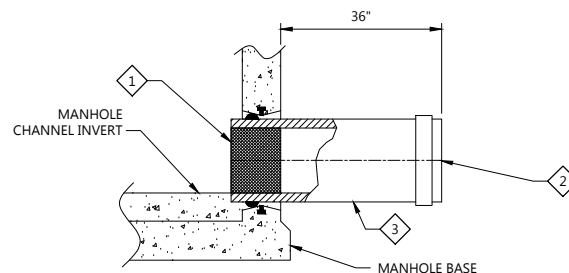

**KEY NOTES**

1. INSTALL A RUBBER RING OR GASKET COLLAR WHERE THE PIPE IS IN CONTACT WITH MANHOLE BASE AND/OR MANHOLE CHANNEL TO PROVIDE A WATERTIGHT SEAL. USE KOR-N-SEAL OR EQUAL.
2. INSTALL FACTORY GASKETED SDR 35 END CAP TO PROVIDE A WATERTIGHT SEAL. MUST PASS THE TESTING PROCEDURES DETAILED IN SPECIFICATION SECTION 15956 PIPING SYSTEMS TESTING.
3. STUB-OUT PIPING TO BE 8-INCH SDR 35 PVC.
4. INSTALL STUB-OUT PIPING AT MINIMUM 0.4% SLOPE TO MANHOLE.

 **C999 MANHOLE STUB-OUT FOR FUTURE CONNECTION**  
TYP NOT TO SCALE



**KEY NOTES**

1. SURFACE RESTORATION SHALL INCLUDE DRAINAGE SWALE ALONG ROADWAY SHOULDER IN THE LOCATIONS PROVIDED.
2. PROVIDE 3-INCHES MINIMUM 3/4-MINUS GRAVEL TO FORM THE SWALE.
3. DEPTH TO FROM BOTTOM OF SWALE TO TOP OF ASPHALT TO BE 8-INCHES MINIMUM WITH A MINIMUM 4:1 SLOPE FROM THE EDGE OF ASPHALT TO THE BOTTOM OF THE SWALE.
4. MATCH SLOPE OF SWALE PARALLEL TO ROADWAY WITH THE EDGE OF ASPHALT TO PROMOTE THE FLOW OF RUNOFF. CLEAR SWALE OF DEBRIS OR RIDGES THAT MAY IMPEDE FLOW.

Shoulder Drainage Locations	
From Station	To Station
26+25	35+90.08
49+59	62+87.76
72+88.01	88+69.30
88+69.30	101+94.30

**C997 ROADWAY SHOULDER DRAINAGE**  
TYP NOT TO SCALE

Path: E:\Projects\111 Lewiston - 1810020 Phase I\CD\CD-8.dwg File Name: CD-8.dwg Plot Date: 2/15/2018 11:48 AM Duce

NO.	REVISION	BY	DATE	DESIGN

PROFESSIONAL ENGINEER  
LICENSED  
10884  
1-22-18  
STATE OF IDAHO  
RYAN J. REIDER



ENGINEERING AND ENVIRONMENTAL SOLUTIONS  
111 MAIN ST. SUITE 175  
LEWISTON, IDAHO 83501  
208.780.3990  
IDAHO OFFICES  
BOISE · LEWISTON · COEUR D'ALENE



**EAST ORCHARDS SEWER EXPANSION**  
LEWISTON, IDAHO  
TYPICAL DETAILS

VERIFY SCALE	
BAR IS ONE INCH ON FULL SIZE DRAWING	1"
PROJECT :	181.0020.00
DATE :	1/22/2018
DRAWING NO.	CD-8